


1 2 3 4 5 6 7 8 9 10 11 12 13 14

F.A.P. RTE.	SECTION	COUNTY	TOTAL SHEETS	SHEET NO.
2993	02-0002-00-WR	DU PAGE	49	28
FEDERAL RD. DIST. NO. 1		ILLINOIS	FEDERAL AID PROJECT	
CONTRACT: 8 59 36				

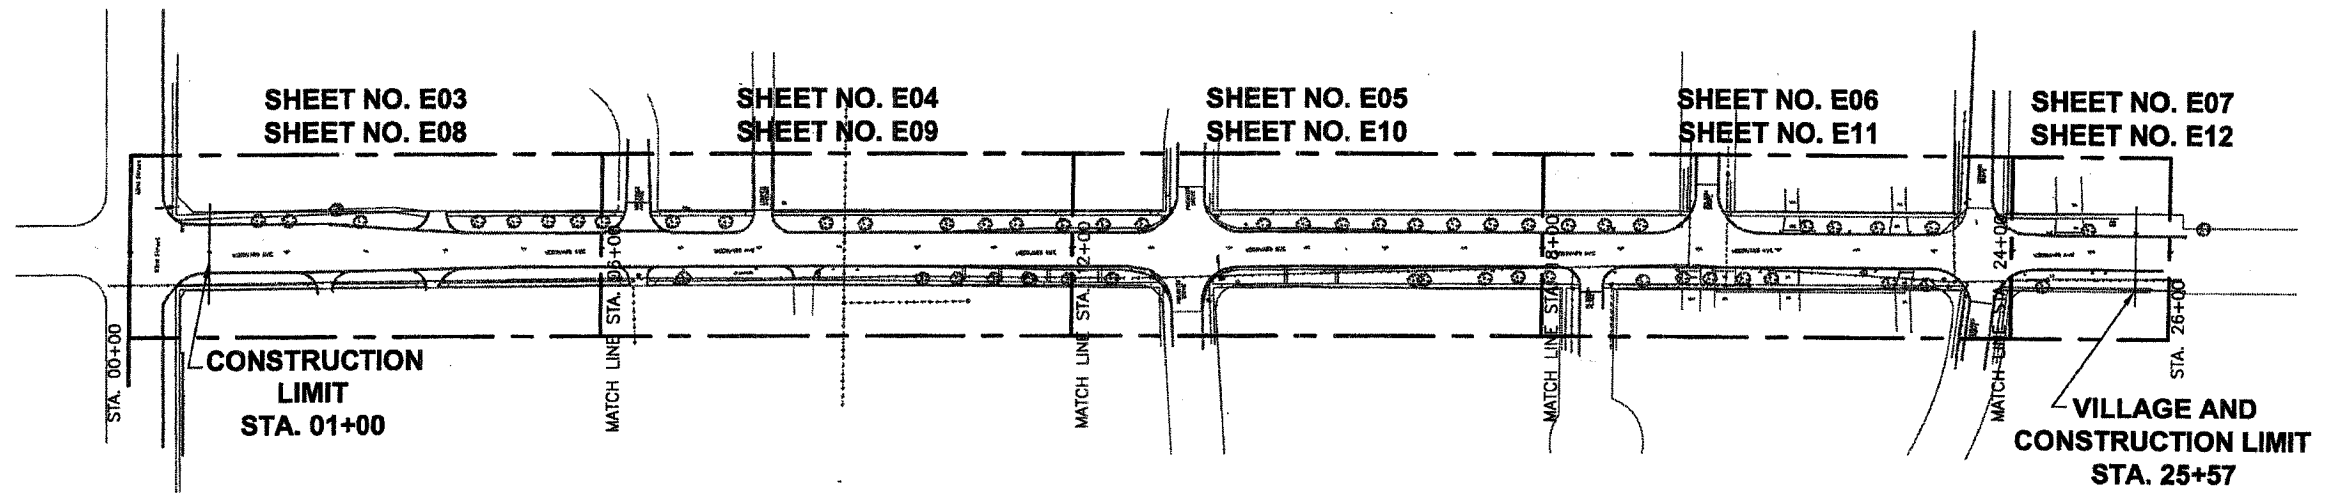

0 100 200  
SCALE IN FEET



**PARTIAL WOODWARD AVENUE LIGHTING LAYOUT - KEY PLAN**  
SCALE AS NOTED

1/8" = 1' (Vertical Scale)  
 1" = 100' (Horizontal Scale)

COPYRIGHT © 2007 BURNS AND MCDONNELL ENGINEERING COMPANY, INC.



*David E. Mertz*

date 04 / 10 / 2007	detailed BMH
designed FO	checked DEM
VILLAGE OF DOWNERS GROVE WOODWARD AVENUE LIGHTING LAYOUT STATION 00+00 TO STATION 25+00	
project 45190	contract
drawing <b>E02</b>	rev. <b>0</b>
sheet	of sheets
file I:\DOWNERS...45190\CAD\ E02	