
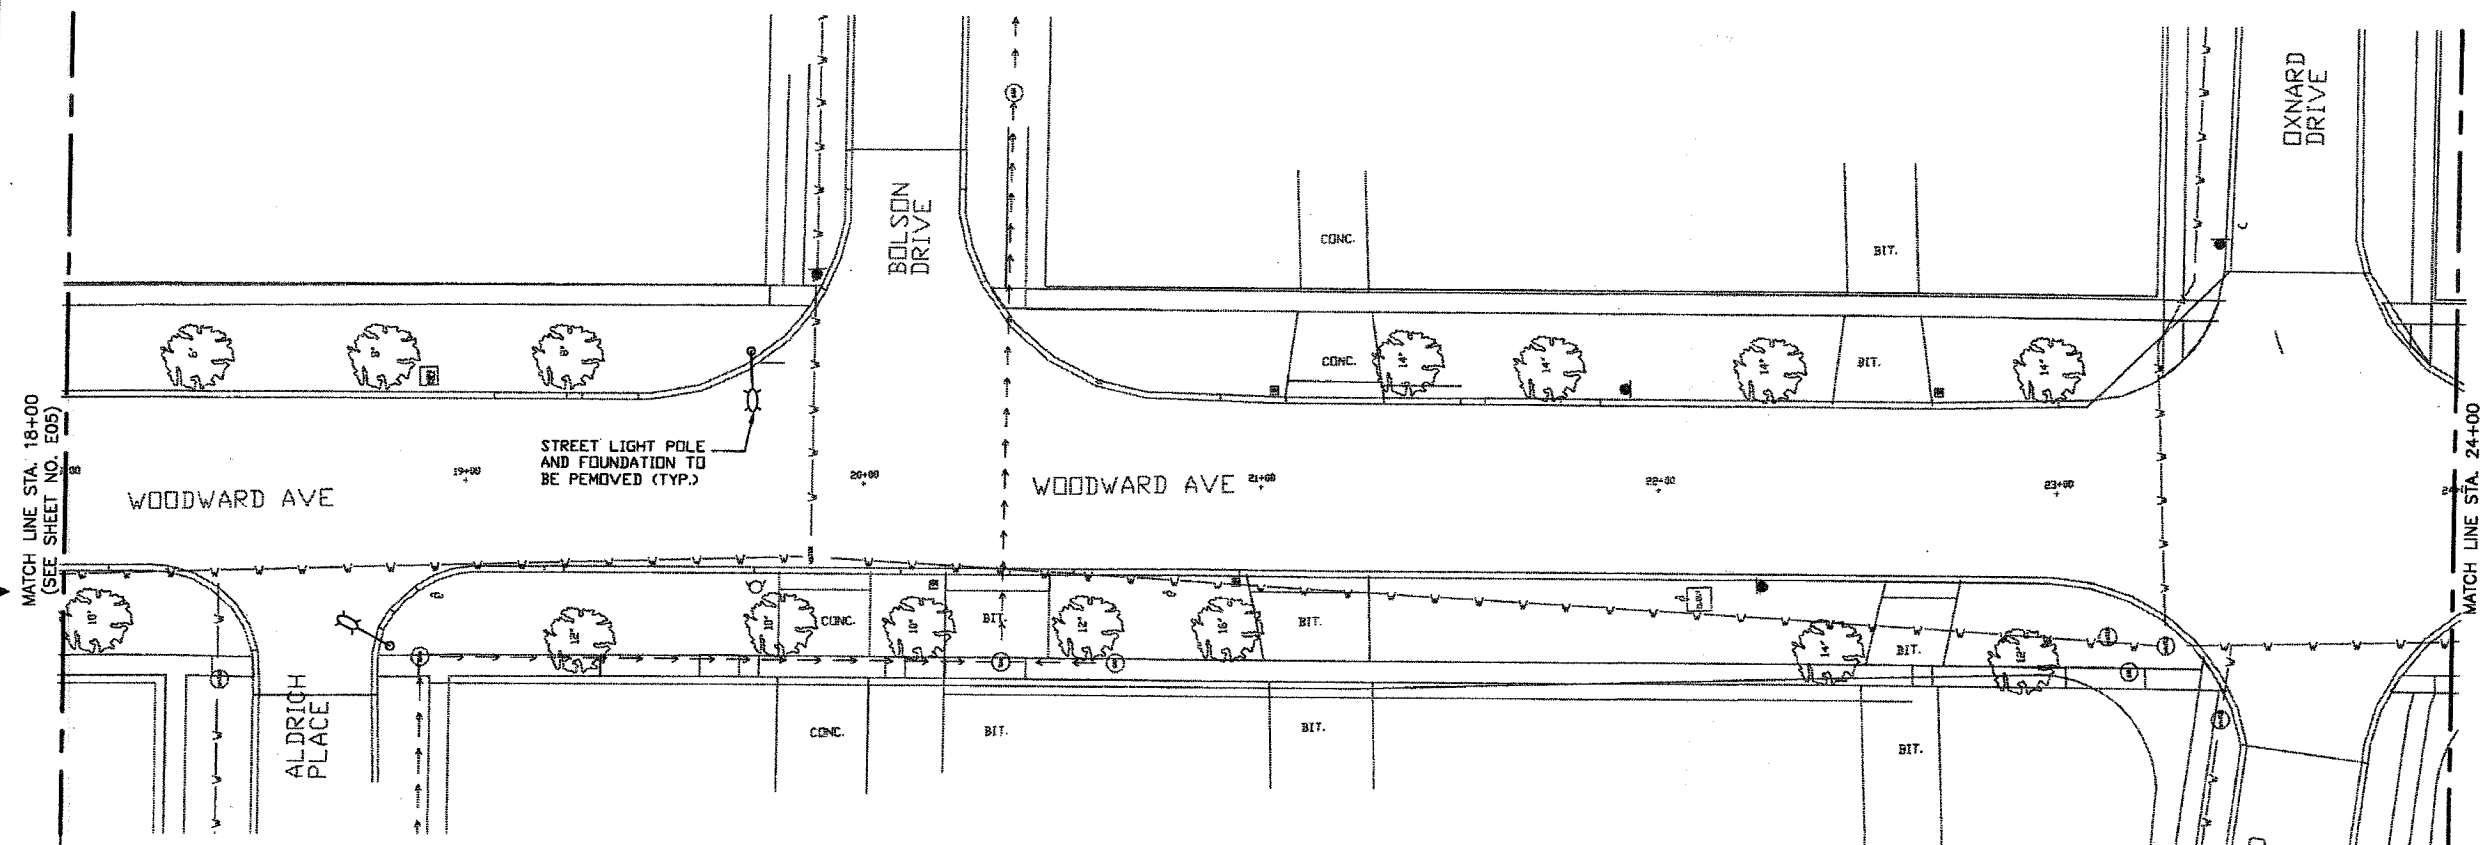


1 2 3 4 5 6 7 8 9 10 11 12 13 14

F.A.P. RTE.	SECTION	COUNTY	TOTAL SHEETS	SHEET NO.
2563	02-0002-00-WR	DU PAGE	49	32
FEDERAL RD. DIST. NO. 1		ILLINOIS	FEDERAL AID PROJECT	
CONTRACT: 03A36				

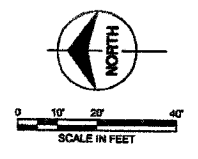

MATCH LINE STA. 18+00  
(SEE SHEET NO. E05)

MATCH LINE STA. 24+00  
(SEE SHEET NO. E07)

STREET LIGHT POLE  
AND FOUNDATION TO  
BE REMOVED (TYP.)

**PARTIAL WOODWARD AVENUE LIGHTING LAYOUT - EXISTING**  
SCALE AS NOTED

Scale For Manufacturing

COPYRIGHT © 2007 BURNS AND MCDONNELL ENGINEERS COMPANY, INC.



*David E. Mertz*

date 04/10/2007	detailed BMH
designed FO	checked DEM
VILLAGE OF DOWNERS GROVE WOODWARD AVENUE LIGHTING LAYOUT STATION 18+00 TO STATION 24+00	
project 45190	contract
drawing <b>E06</b>	rev. <b>0</b>
sheet of sheets	
file: H:\DOWNERS...45190\CAD\ E06	