
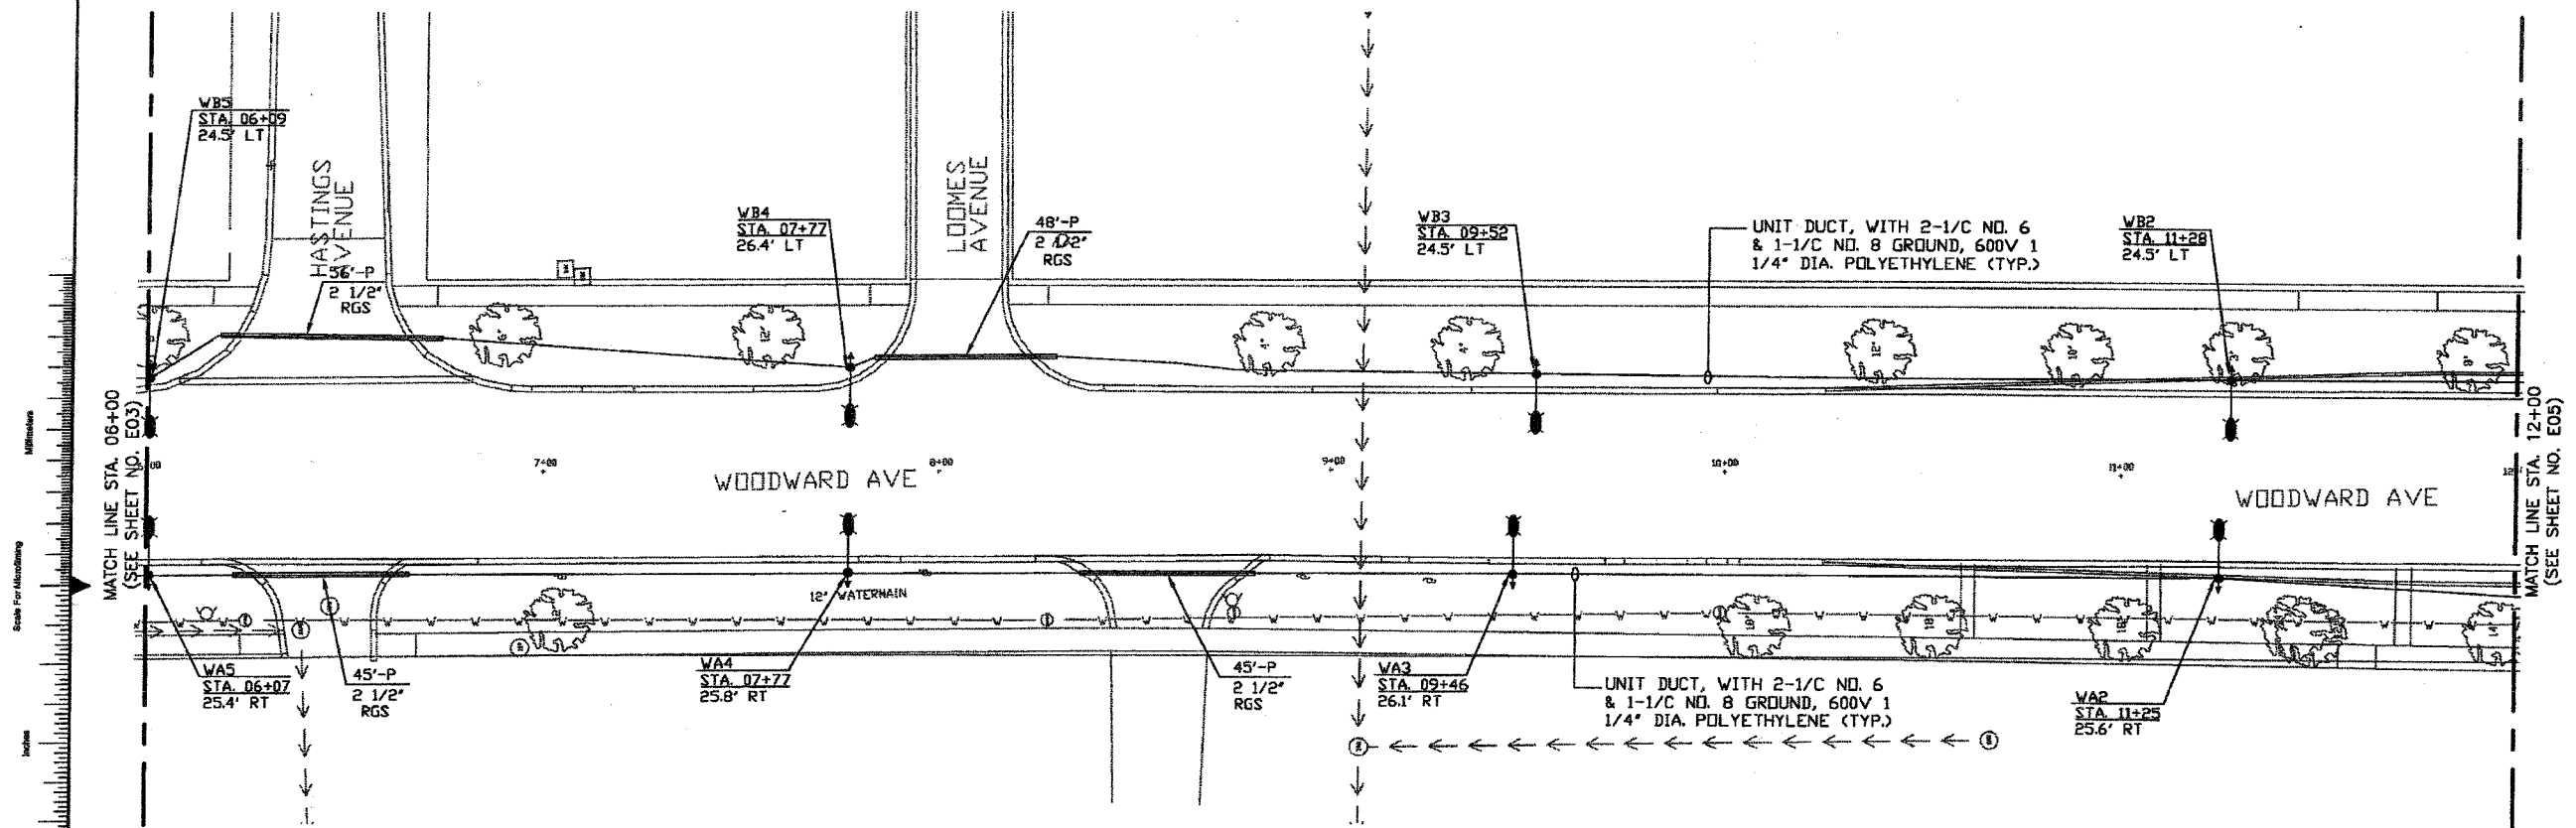


1 2 3 4 5 6 7 8 9 10 11 12 13 14

F.A.P. RTE.	SECTION	COUNTY	TOTAL SHEETS	SHEET NO.
2503	02-0092-00-WR	ILLINOIS	49	33
FEDERAL RD. DIST. NO. 1		ILLINOIS	FEDERAL AID PROJECT	
CONTRACT: 05936				

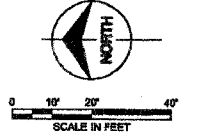

**PARTIAL WOODWARD AVENUE LIGHTING LAYOUT - PROPOSED PLAN**  
SCALE AS NOTED

Scale For Manufacturing  
Millimeters  
Inches

COPYRIGHT © 2007 BURNS AND MCDONNELL ENGINEERING COMPANY, INC.



*David E. Mertz*

date 04/10/2007	designed FO
checked BMH	checked DEM
VILLAGE OF DOWNERS GROVE WOODWARD AVENUE LIGHTING LAYOUT STATION 06+00 TO STATION 12+00	
project 45190	contract
drawing <b>E09</b>	rev. <b>0</b>
sheet of sheets	
file (D:\DOWNERS_V45190\CAD\E09	