
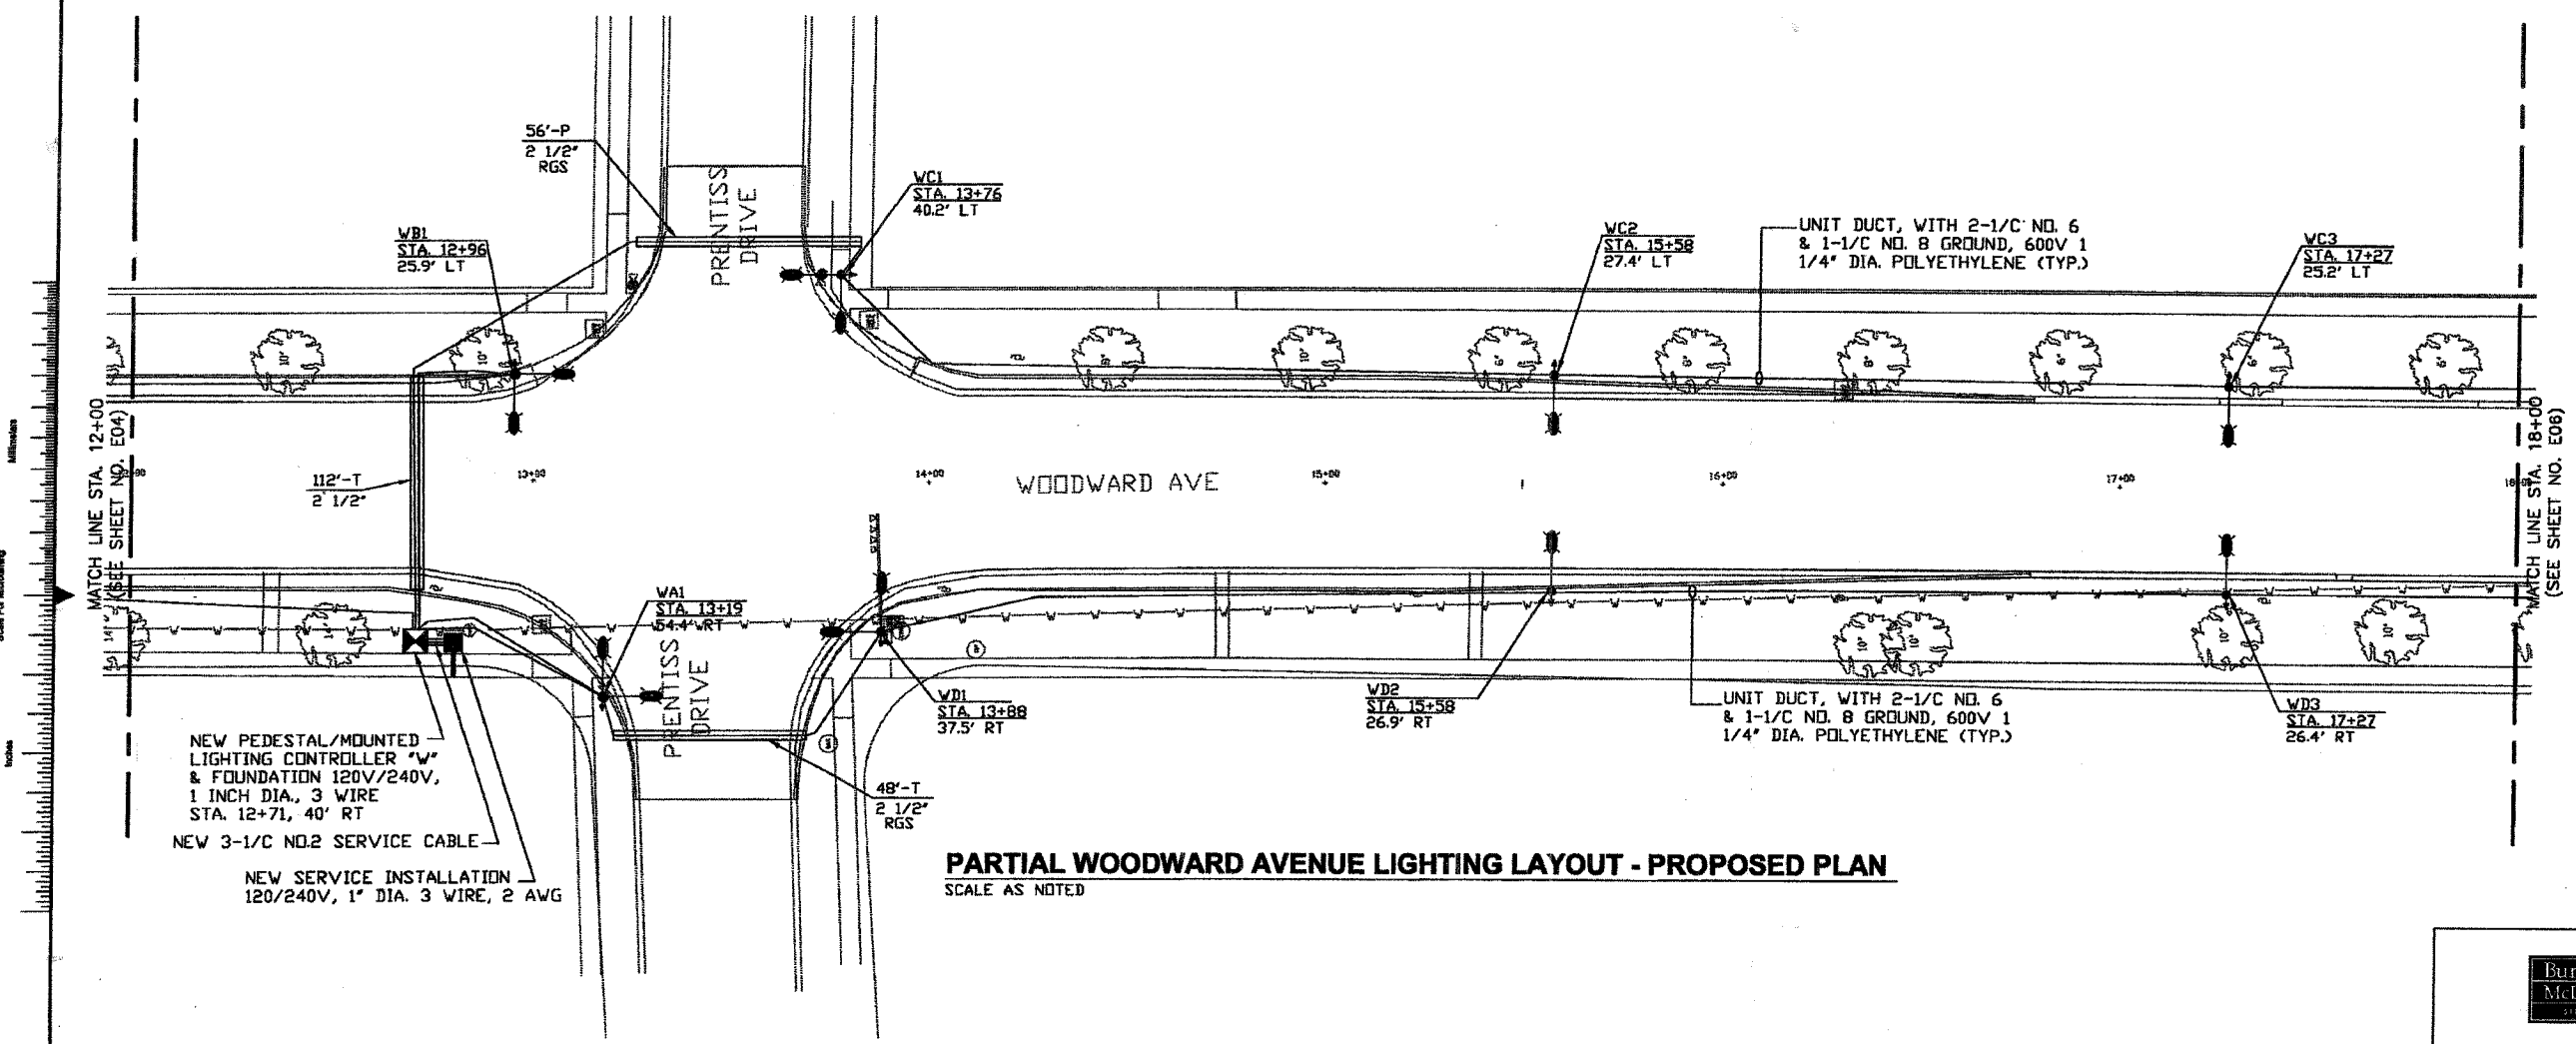


1 2 3 4 5 6 7 8 9 10 11 12 13 14

F.A.P. RTE.	SECTION	COUNTY	TOTAL SHEETS	SHEET NO.
2593	02-00092-00-WR	DU PAGE	49	36
FEDERAL RD. DIST. NO. 1		ILLINOIS	FEDERAL AID PROJECT	
CONTRACT: 03934				

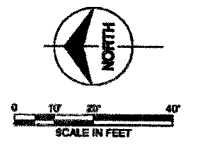

NEW PEDESTAL/MOUNTED LIGHTING CONTROLLER "W" & FOUNDATION 120V/240V, 1 INCH DIA, 3 WIRE STA. 12+71, 40' RT
 NEW 3-1/C NO.2 SERVICE CABLE
 NEW SERVICE INSTALLATION 120/240V, 1" DIA. 3 WIRE, 2 AWG

PARTIAL WOODWARD AVENUE LIGHTING LAYOUT - PROPOSED PLAN
 SCALE AS NOTED

COPYRIGHT © 2007 BURNS AND MCDONNELL ENGINEERING COMPANY, INC.



David E. Mertz

date 04 / 10 / 2007	detailed BMH
designed FO	checked DEM
VILLAGE OF DOWNERS GROVE WOODWARD AVENUE LIGHTING LAYOUT STATION 12+00 TO STATION 18+00	
project 45190	contract
drawing E10	rev. 0
sheet of sheets	
file I:\DOWNERS...45190\CAD\ E10	