



F.A.P. RTE.	SECTION	COUNTY	TOTAL SHEETS	SHEET NO.
2583	02-00092-00-WR	DU PAGE	49	38
FEDERAL RD. DIST. NO. 1		ILLINOIS	FEDERAL AID PROJECT	
CONTRACT: 83736				

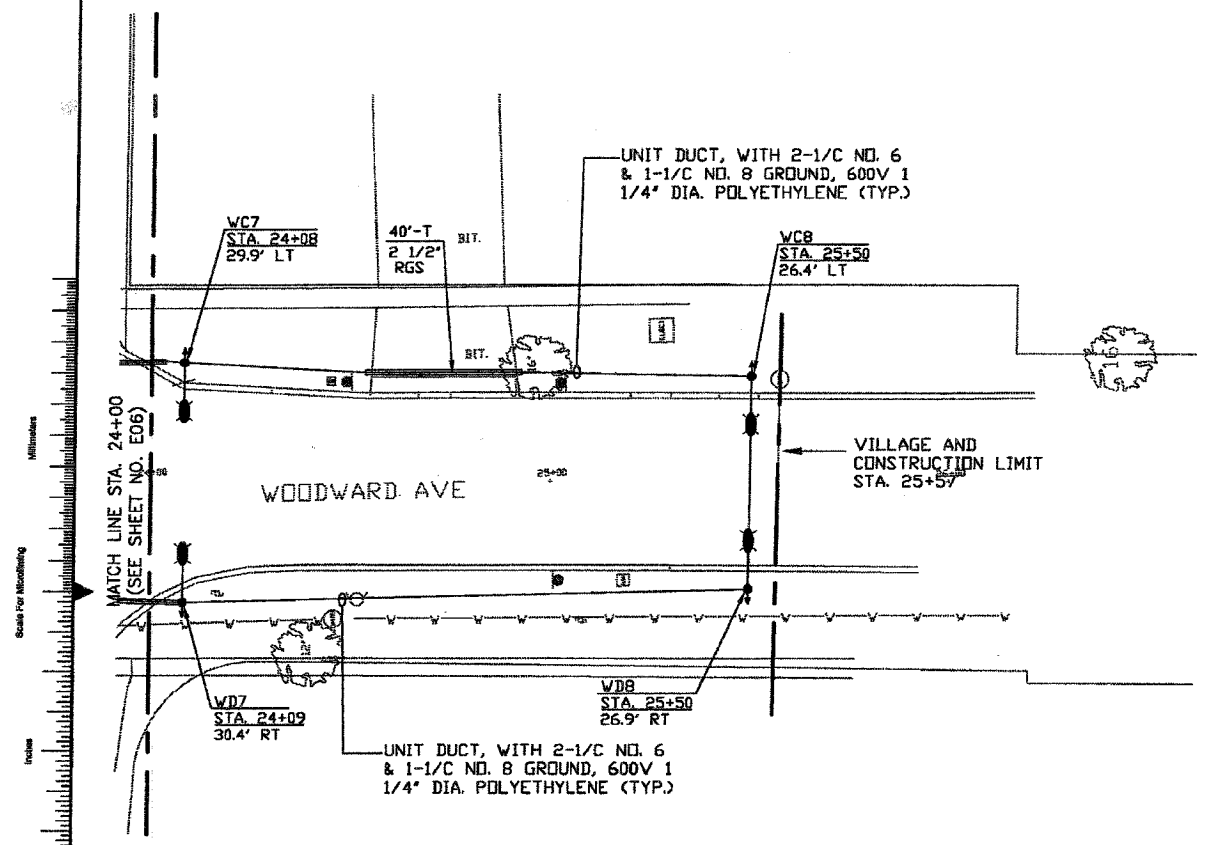

**PARTIAL WOODWARD AVENUE LIGHTING LAYOUT - PROPOSED PLAN**  
SCALE AS NOTED

COPYRIGHT © 2007 BURNS AND MCDONNELL ENGINEERING COMPANY, INC.

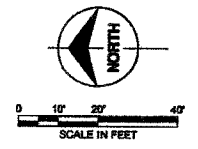

*D. E. Mertz*

date 04 / 10 / 2007	detailed BMH
designed FO	checked DEM
VILLAGE OF DOWNERS GROVE WOODWARD AVENUE LIGHTING LAYOUT STATION 24+00 TO STATION 26+00	
project 45190	contract
drawing E12	rev. 0
sheet	of sheets
file	H:\DOWNERS...W5190\CAD\ E12