



F.A.P. RTE.	SECTION	COUNTY	TOTAL SHEETS	SHEET NO.
2593	02-00092-00-WR		49	29
FEDERAL RD. DIST. NO. 1		ILLINOIS	FEDERAL AID PROJECT	
CONTRACT: 8 39 36				



CIRCUIT	POLE NUMBER	PHASE 1 (BLACK) AMP	PHASE 2 (RED) AMP	BREAKER SIZE	REMARKS
A	3	11.1	11.1	20	
B	2, 4	11.1	11.1	30	
C	5, 7	11.1	11.1	20	
D	8	11.9	11.9	30	
E	9, 11	0	0	20	SPARE
F	12	0	0	30	SPARE
TOTAL		45.2	45.2		

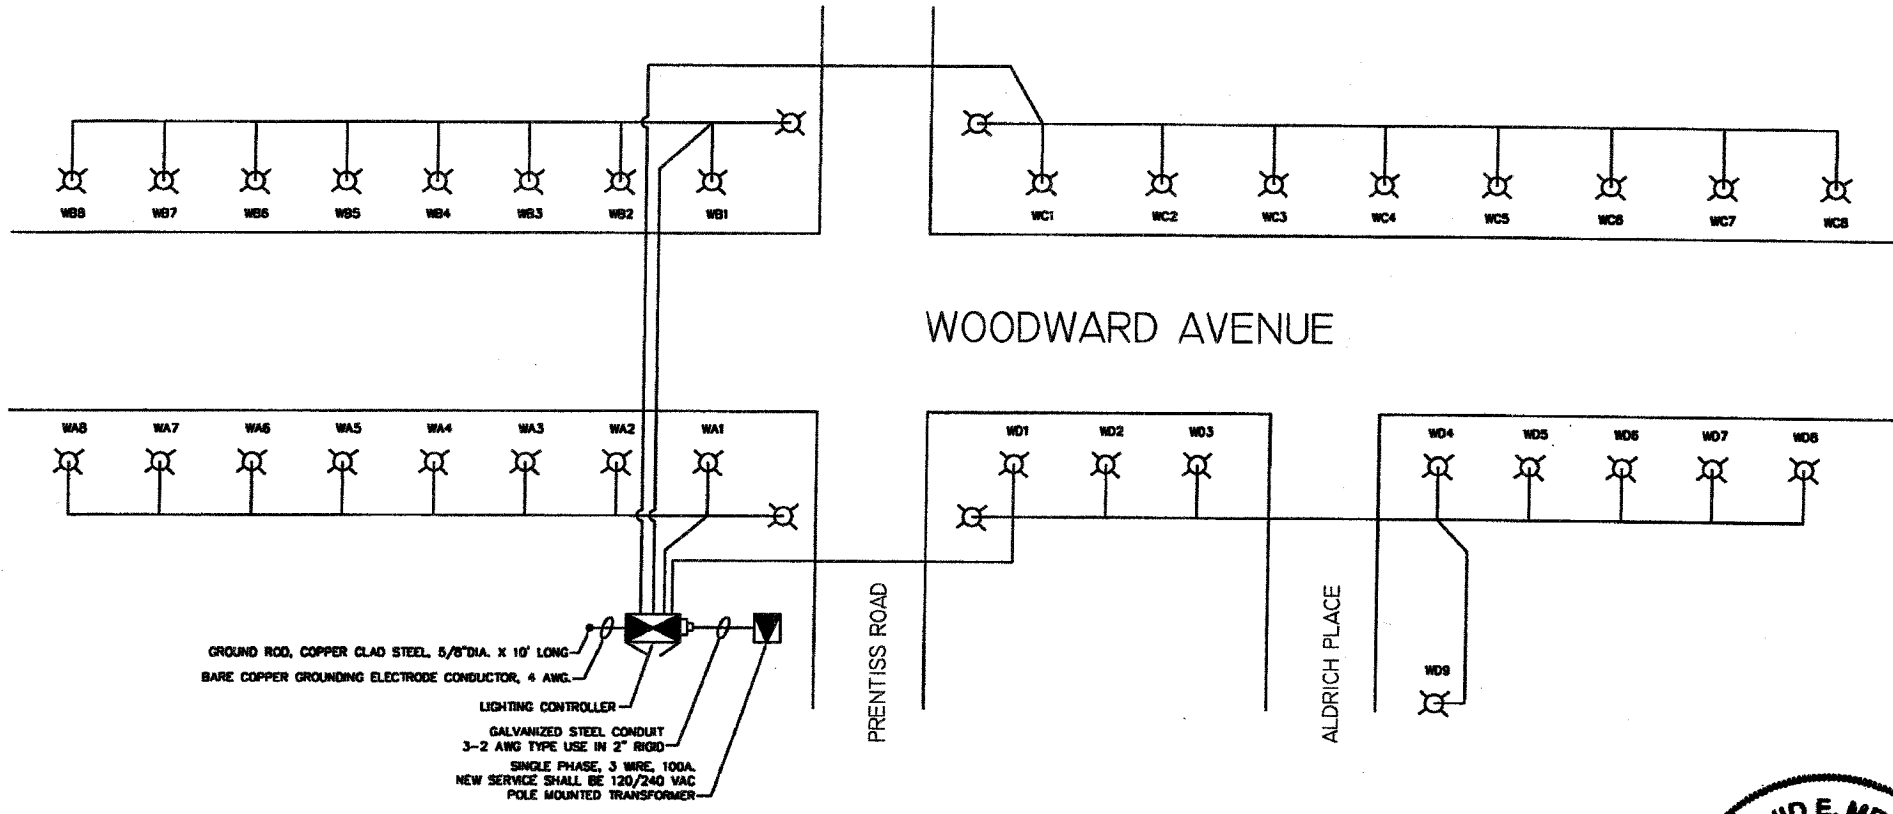

ONE LINE DIAGRAM (N.T.S.)

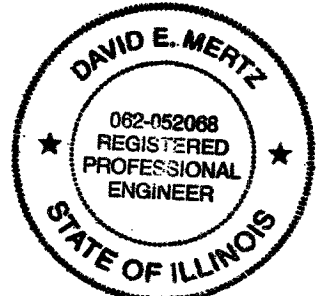

D. E. Mertz

date 04 / 10 / 2007	detailed B. HAAS
designed D. MERTZ	checked A. RAHMAN
VILLAGE OF DOWNERS GROVE WOODWARD AVENUE PHOTOMETRICS ONE LINE DIAGRAM	
project 45180	contract
drawing E13	rev.
sheet 13 of 18 sheets	
file I:\DOWNERS...W5190\CADA E13	

Scale For Mounting
Millimeters
Inches
COPYRIGHT © 2007 BURNS AND McDONNELL ENGINEERING COMPANY, INC.