 

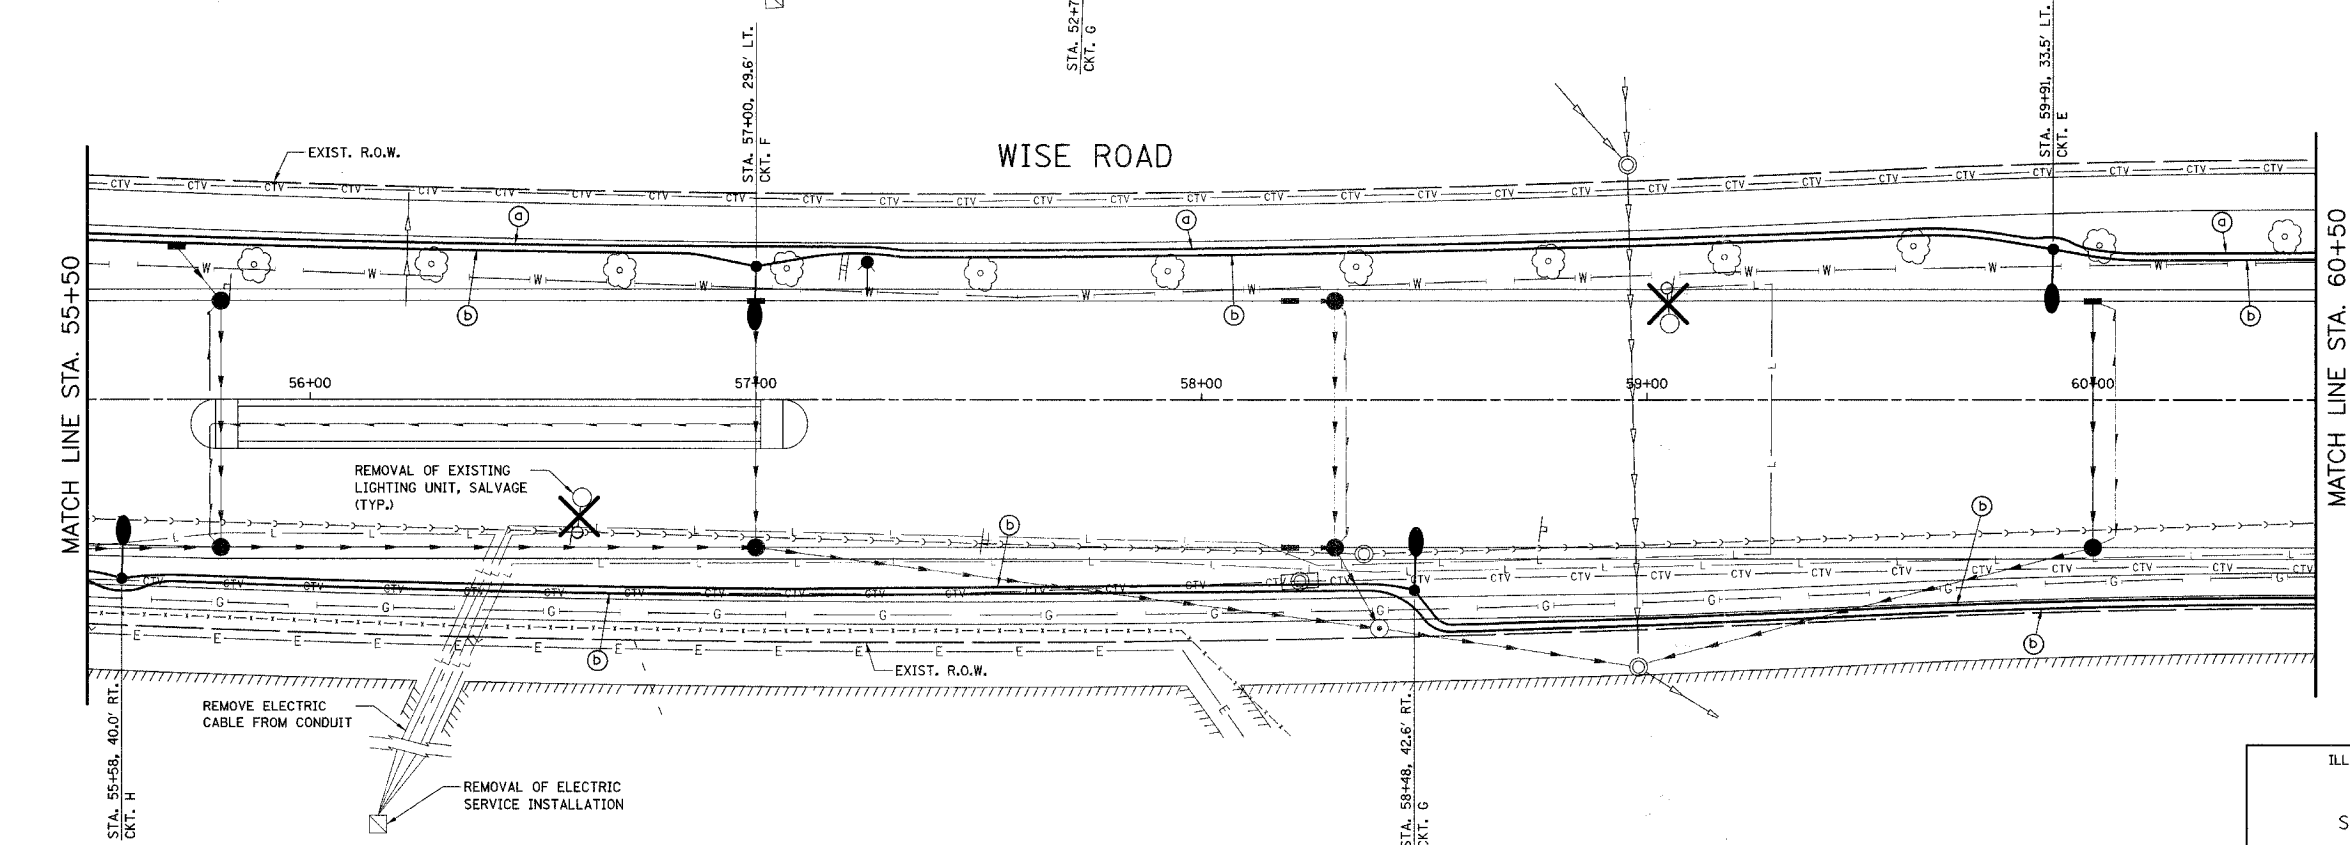


F.A.U. RTE.	SECTION	COUNTY	TOTAL SHEETS	SHEET NO.
1338	05-00083-00-FF	COOK	167	110

LIGHTING PLAN - STA. 50+50 TO STA. 60+50  
 FED. ROAD DIST. NO. 7 ILLINOIS FED. AID PROJECT M-8003(512)

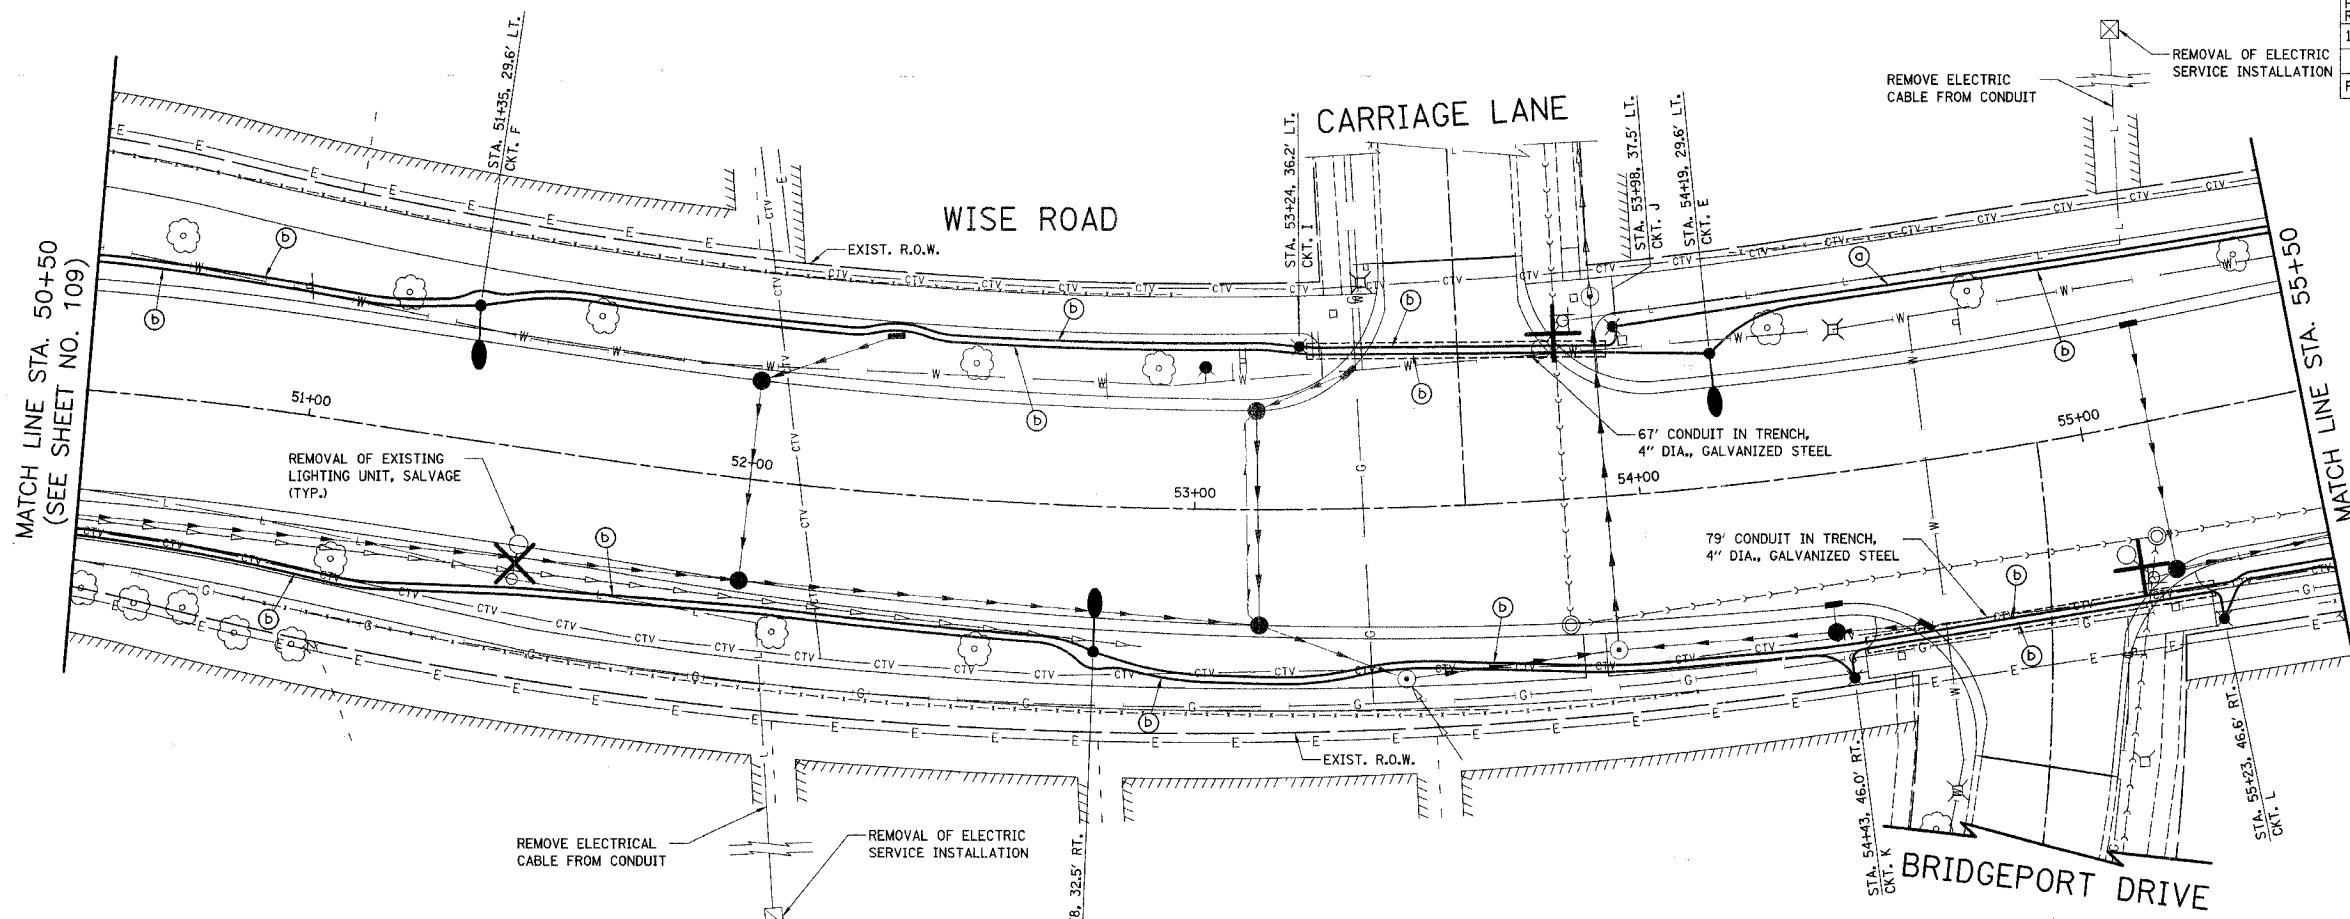

ILLINOIS DEPARTMENT OF TRANSPORTATION  
 LIGHTING PLAN  
 STA. 50+50 TO STA. 60+50  
 WISE ROAD

DATE: 9/28/07  
 DESIGNED BY: SJC  
 CHECKED BY: DNM

SCALE IN FEET