



F.A.U. RTE.	SECTION	COUNTY	TOTAL SHEETS	SHEET NO.
1512	05-00093-00-WR	DUPAGE	72	29
STA. 100+00		TO STA. 104+00		
FED. ROAD DIST. NO. 1 ILLINOIS FED. AID PROJECT				
PROJECT NO.: M-8003 (699)				

PLAN	SURVEYED	DATE
	BY	
	PLOTTED	
	BY	
	NOTE BOOK	
	NO. OF PAGES	
	DATE	
	BY	
	PLOTTED	
	BY	
	NOTE BOOK	
	NO. OF PAGES	
	DATE	
	BY	

PROFILE	SURVEYED	DATE
	BY	
	PLOTTED	
	BY	
	NOTE BOOK	
	NO. OF PAGES	
	DATE	
	BY	
	PLOTTED	
	BY	
	NOTE BOOK	
	NO. OF PAGES	
	DATE	
	BY	

PLOT DATE = #DATE#
 FILE NAME = #FILE#
 PLOT SCALE = #SCALE#
 USER NAME = #USER#

- DRAINAGE LEGEND:
- △ XX DRAINAGE STRUCTURE NUMBER
 - ⊙ XX STORM SEWER NUMBER
 - A DRAINAGE STRUCTURE ADJUSTMENT

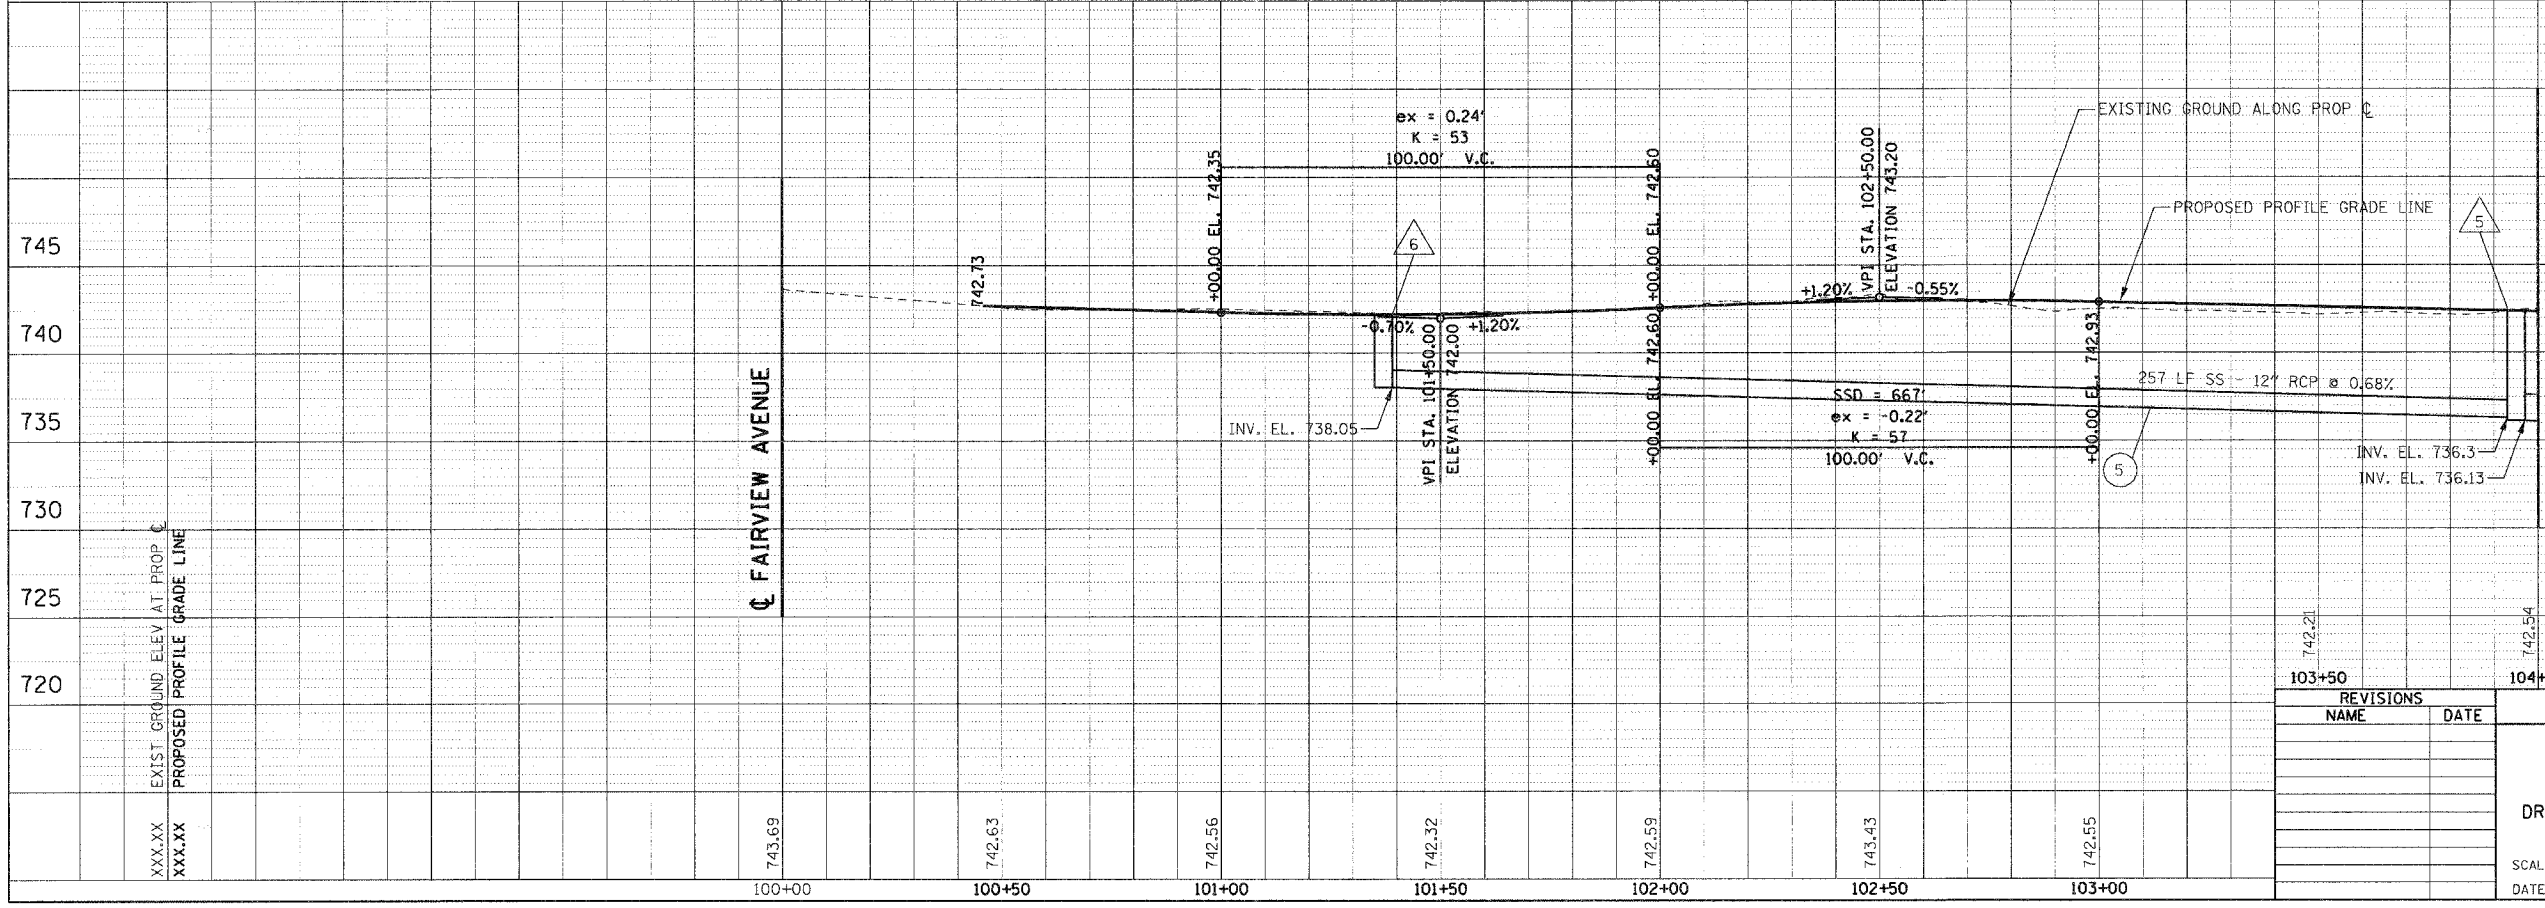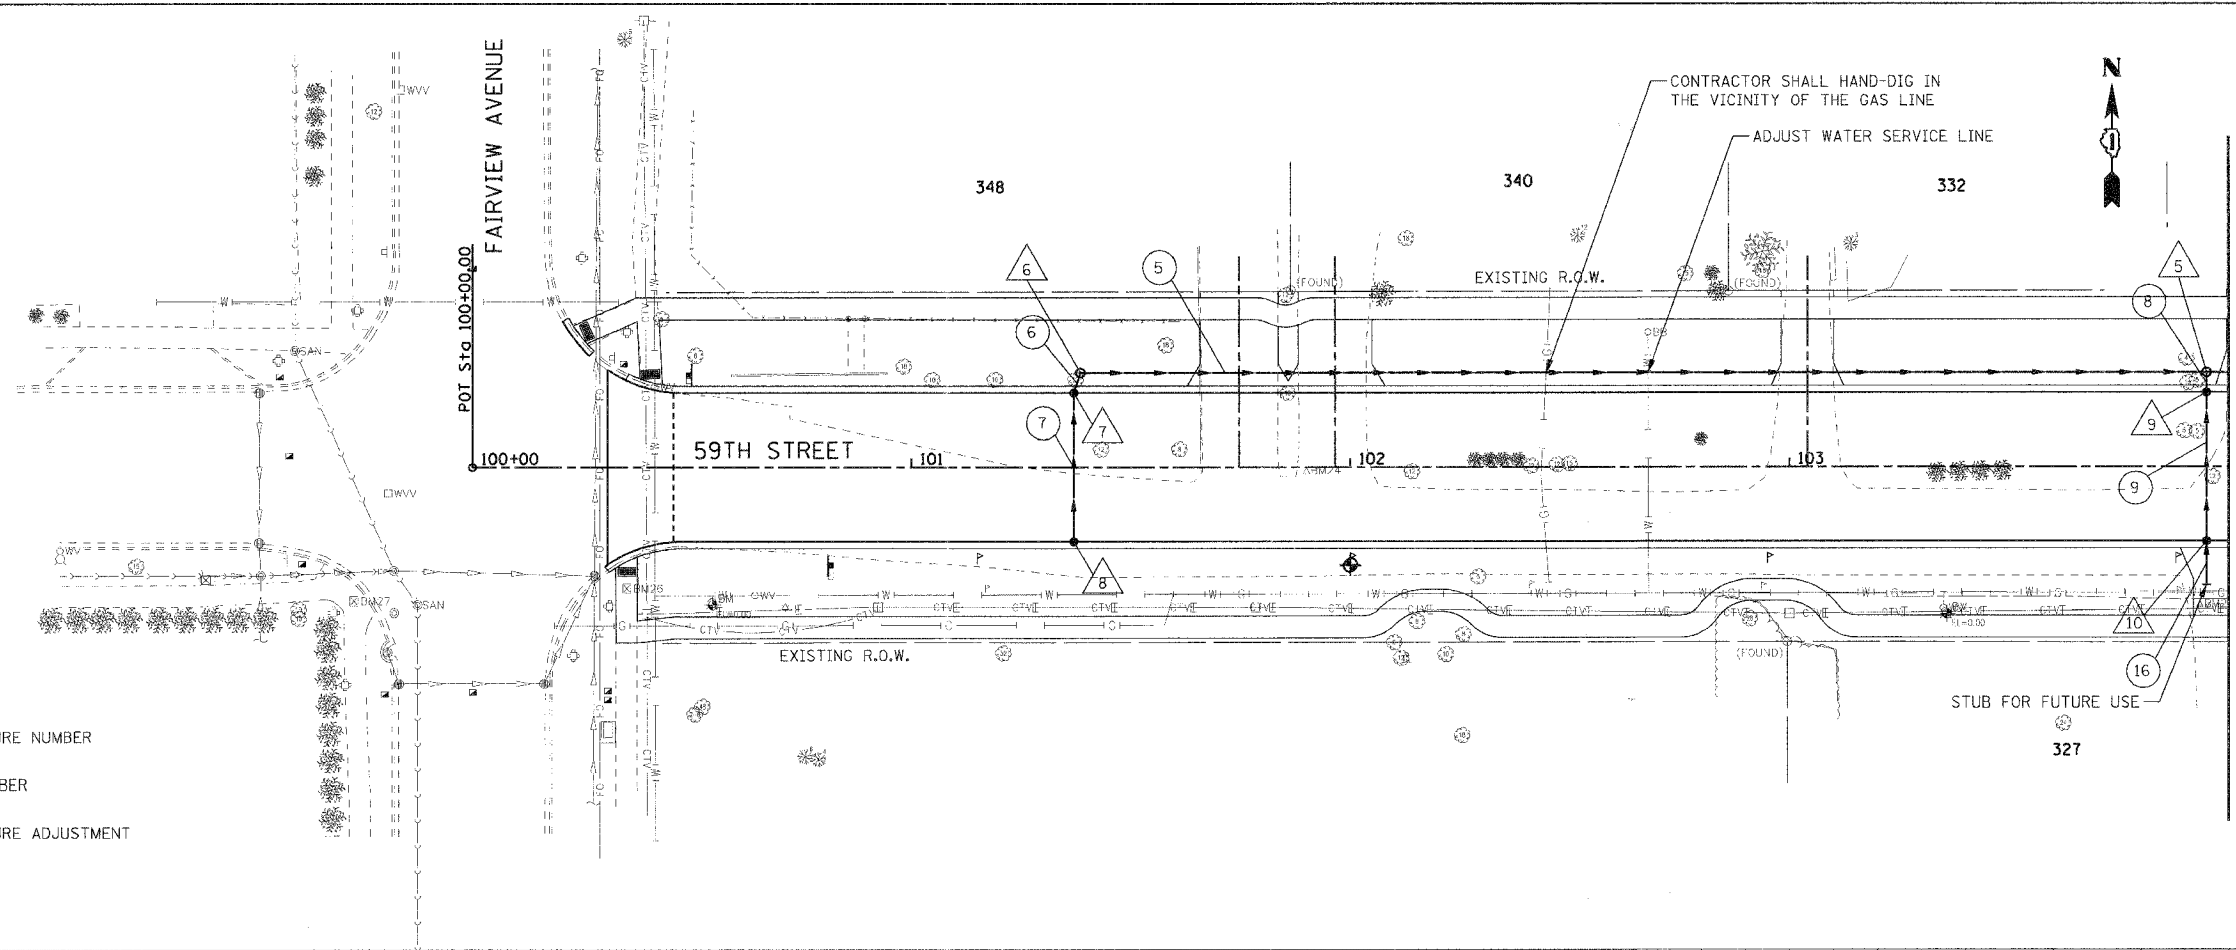

REVISIONS	
NAME	DATE

ILLINOIS DEPARTMENT OF TRANSPORTATION
 VILLAGE OF WESTMONT
 59TH STREET RECONSTRUCTION
 DRAINAGE AND UTILITY PLAN AND PROFILE
 SHEET 1 OF 6
 SCALE: HORIZ. 1"=20'
 VERT. 1"=5'
 DATE: 09/21/07
 DRAWN BY: DEB
 CHECKED BY: AJB

MATCHLINE STA 104+00
 SEE SHEET 2 OF 6

MATCHLINE STA 104+00
 SEE SHEET 2 OF 6