

STORM SEWER REMOVAL - 8"
 STA. 72+02.85 TO STA. 71+99.44 - 65.2 FT

STORM SEWER REMOVAL - 10"
 STA. 72+96.42 TO STA. 75+46.99 - 254.5 FT
 STA. 75+46.99 TO STA. 75+45.99 - 24.9 FT
 STA. 77+98.46 TO STA. 77+86.82 - 82.8 FT

STORM SEWER REMOVAL - 15"
 STA. 70+00.00 TO STA. 70+10.45 - 68.2 FT
 STA. 70+10.45 TO STA. 70+12.15 - 12.8 FT

STORM SEWER REMOVAL - 18"
 STA. 75+43.12 TO STA. 75+45.99 - 69.6 FT
 STA. 81+20.17 TO STA. 81+45.19 - 158.6 FT

STORM SEWER REMOVAL - 24"
 STA. 68+00.00 TO STA. 70+12.15 - 217.2 FT
 STA. 70+12.15 TO STA. 72+11.50 - 204.3 FT
 STA. 72+11.50 TO STA. 75+45.77 - 342.4 FT
 STA. 75+45.77 TO STA. 77+94.38 - 248.6 FT
 STA. 77+94.38 TO STA. 78+53.91 - 59.5 FT
 STA. 78+53.91 TO STA. 81+43.08 - 289.2 FT
 STA. 81+43.08 TO STA. 82+00.00 - 56.9 FT

REMOVAL LEGEND



- PAVEMENT REMOVAL
- SHOULDER REMOVAL
- HMA SURFACE REMOVAL, 4"
- DRAINAGE STR. ADJUSTMENT
- DRAINAGE STR. REMOVAL
- CONCRETE MEDIAN REMOVAL
- PAVED DITCH REMOVAL
- STORM SEWER REMOVAL
- LINEAR ITEM REMOVAL
- ITEM REMOVAL

REMOVING INLETS
 STA. 72+02.85, 65.47' LT

REMOVING CATCH BASINS
 STA. 70+00.12, 65.25' LT
 STA. 70+14.84, 73.81' RT
 STA. 77+98.46, 0.00' LT
 STA. 78+01.13, 66.23' RT

REMOVING MANHOLES
 STA. 70+00.00, 0.20' LT
 STA. 70+12.15, 79.42' RT
 STA. 71+99.44, 0.37' LT
 STA. 72+11.50, 81.50' RT
 STA. 72+96.42, 47.57' RT
 STA. 75+46.99, 58.02' RT
 STA. 75+45.77, 82.91' RT
 STA. 77+94.38, 81.76' RT
 STA. 78+53.91, 82.46' RT
 STA. 81+43.08, 80.94' RT

REMOVING FLARED END SECTIONS - 18"
 STA. 75+43.12, 152.50' RT

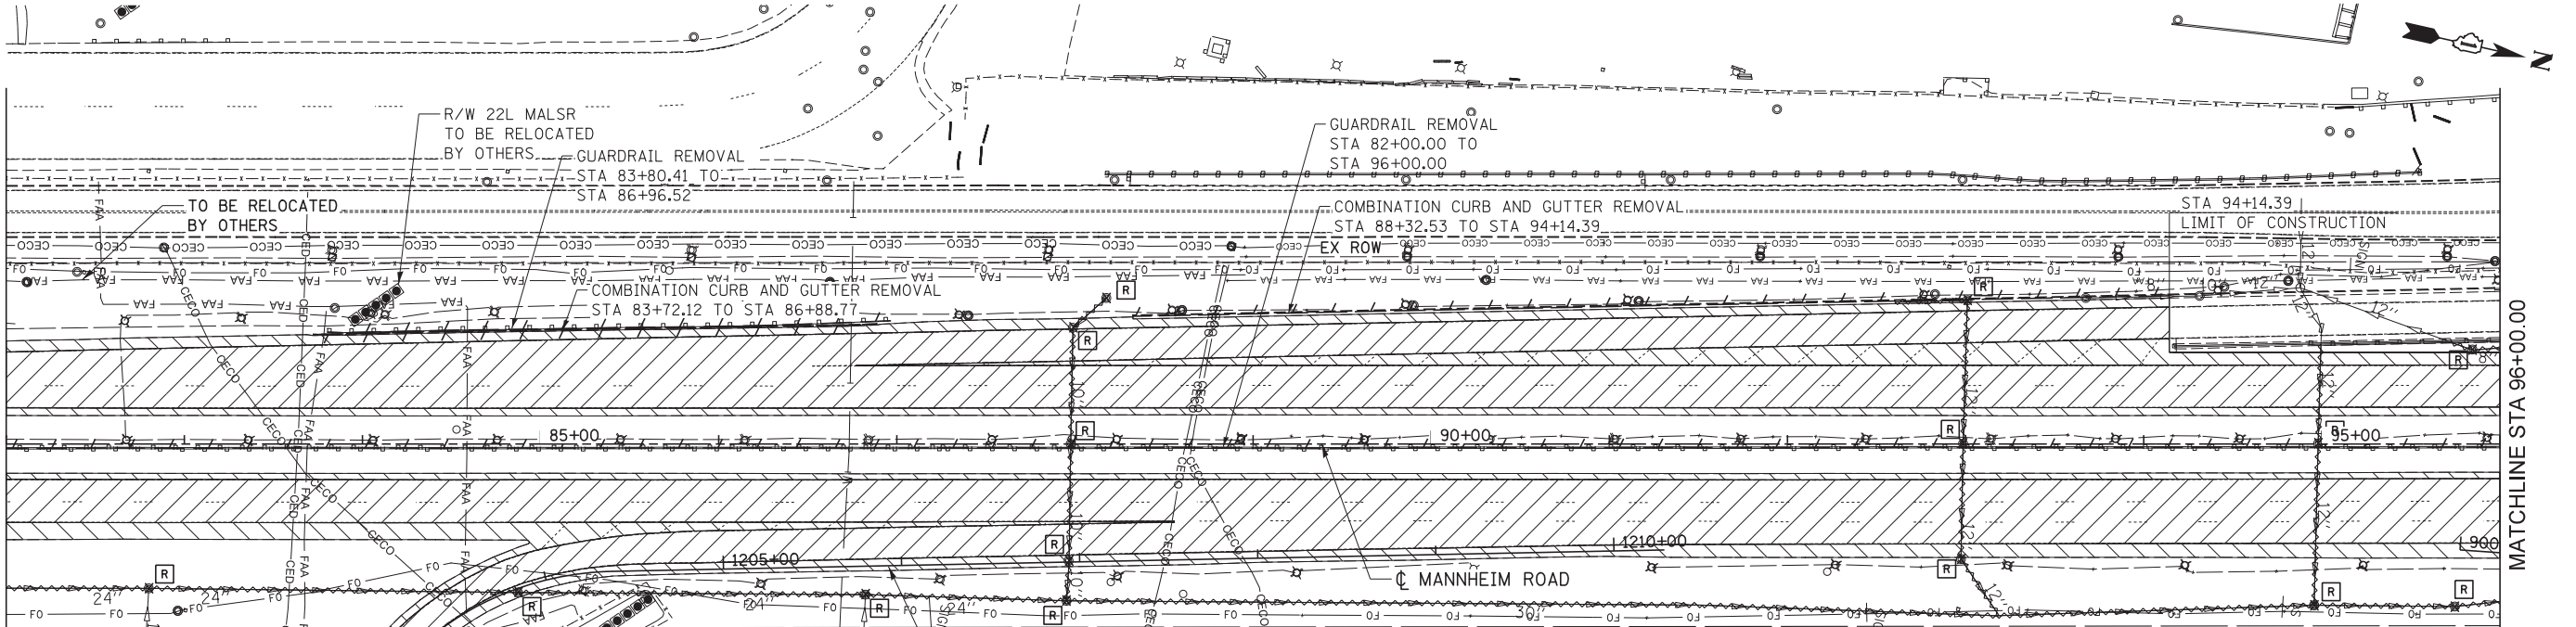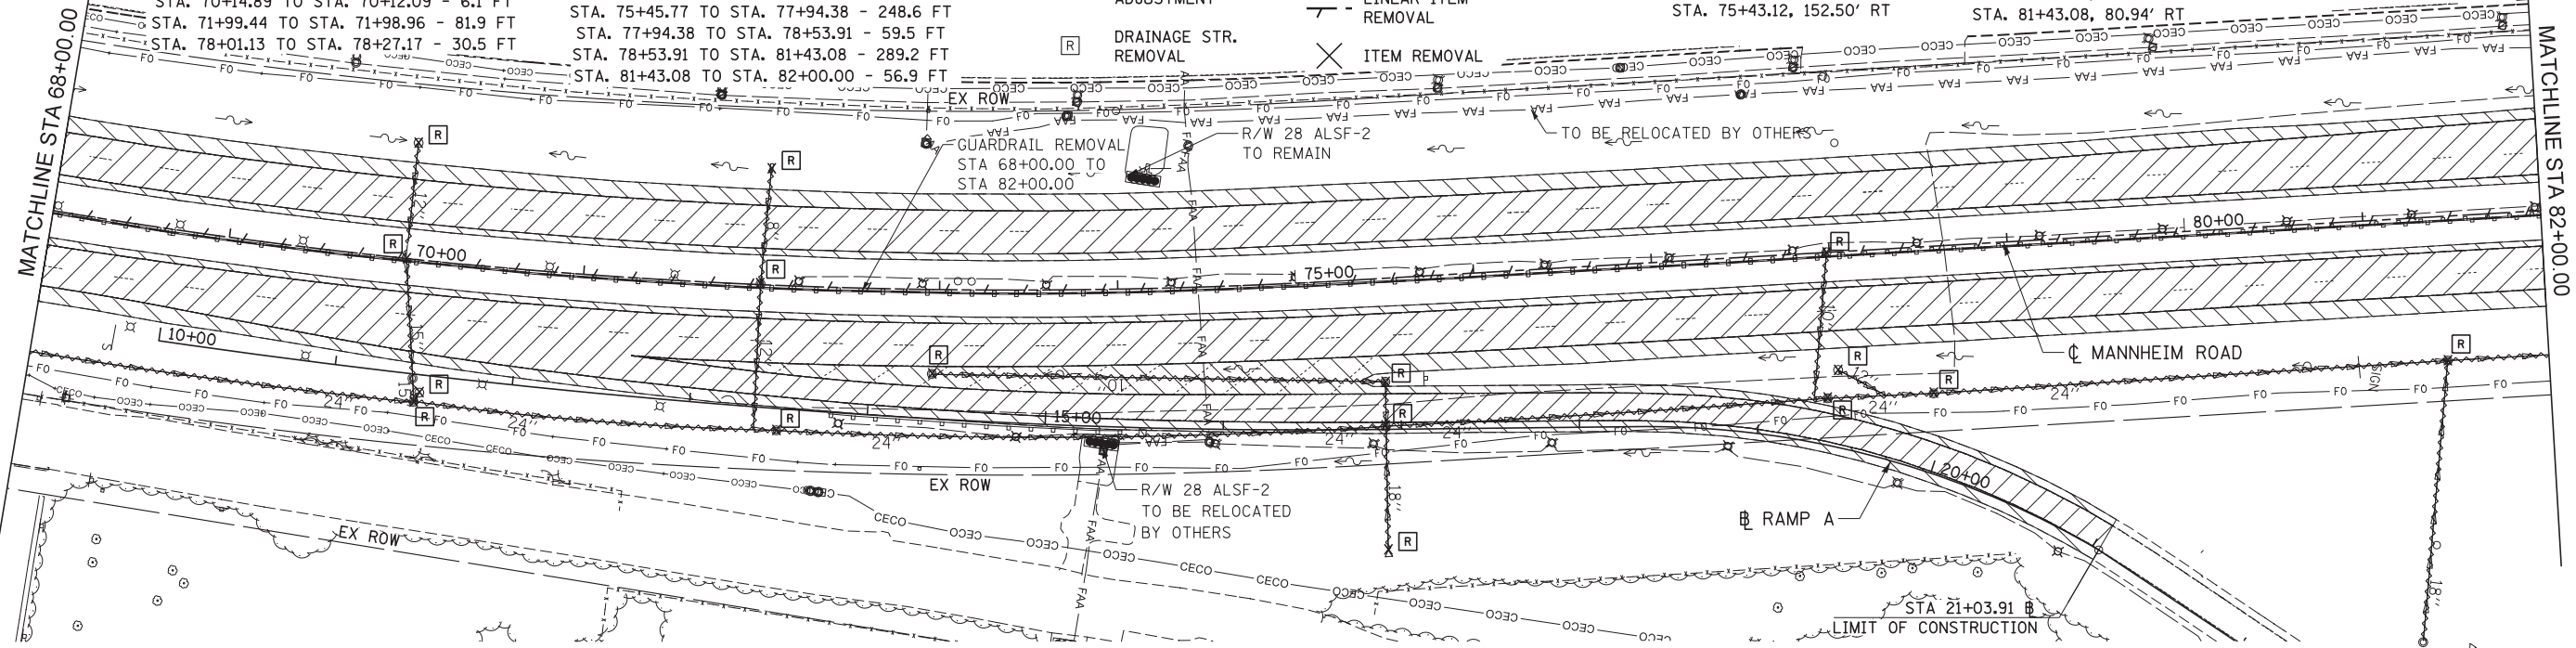

- NOTES**
- SEE PAVEMENT MARKING AND SIGNING PLANS, LIGHTING PLANS, LANDSCAPING PLANS, AND TRAFFIC SIGNAL PLANS FOR ADDITIONAL REMOVALS NOT SHOWN ON THIS SHEET.
 - REMOVAL AND DISPOSAL OF EXISTING SHOULDER STABILIZATION UNDER EXISTING GUARDRAIL SHALL NOT BE MEASURED FOR PAYMENT BUT SHALL BE INCLUDED IN THE COST OF SHOULDER REMOVAL.
 - REMOVAL AND DISPOSAL OF EXISTING BURIED MOUNTABLE CURB SHALL NOT BE MEASURED FOR PAYMENT BUT SHALL BE INCLUDED IN THE COST OF SHOULDER REMOVAL.

STORM SEWER REMOVAL - 12"
 STA. 82+00.00 TO STA. 82+80.00 - 80.0 FT
 STA. 82+80.00 TO STA. 84+87.42 - 207.4 FT
 STA. 84+87.42 TO STA. 86+82.36 - 195.0 FT
 STA. 86+82.36 TO STA. 87+95.22 - 112.9 FT

STORM SEWER REMOVAL - 30"
 STA. 87+95.22 TO STA. 94+95.67 - 700.6 FT
 STA. 94+95.67 TO STA. 95+74.63 - 79.0 FT

STORM SEWER REMOVAL - 10"
 STA. 88+17.60 TO STA. 87+98.87 - 25.2 FT
 STA. 87+98.87 TO STA. 87+97.61 - 65.1 FT
 STA. 87+97.61 TO STA. 87+96.69 - 66.4 FT
 STA. 87+96.69 TO STA. 87+95.22 - 22.6 FT

REMOVING MANHOLES
 STA. 93+01.00, 80.70' LT
 STA. 92+98.59, 0.25' LT
 STA. 92+97.39, 64.59' RT
 STA. 95+84.53, 52.77' LT
 STA. 94+97.91, 0.30' LT
 STA. 94+95.67, 90.57' RT
 STA. 95+74.63, 91.28' RT

REMOVING MANHOLES
 STA. 82+80.00, 81.08' RT
 STA. 84+87.42, 83.42' RT
 STA. 86+82.36, 84.61' RT
 STA. 88+17.60, 82.00' LT
 STA. 87+98.87, 65.13' LT
 STA. 87+97.61, 0.00' LT
 STA. 87+96.69, 66.33' RT
 STA. 87+95.22, 88.07' RT



USER NAME = micosir	DESIGNED LLS/MMK	REVISED -
PLOT SCALE = 50:1	DRAWN MMK	REVISED -
PLOT DATE = 19-OCT-2012	CHECKED LLS	REVISED -
	DATE 10/19/12	REVISED -

STATE OF ILLINOIS
 DEPARTMENT OF TRANSPORTATION

**REMOVAL PLAN
 MANNHEIM ROAD**

SCALE: 1" = 50' SHEET NO. 3 OF 6 SHEETS STA. 68+00.00 TO STA. 96+00.00

F.A.P. RTE. 330	SECTION 0105 WRS&HB	COUNTY COOK	TOTAL SHEETS 605	SHEET NO. 60
CONTRACT NO. 60G37				ILLINOIS FED. AID PROJECT

REM-03