


F:\PROJECTS\2012\10-18-2012\1322023\BAJZEK\10-18-2012\1322023\TEMPORARY SIGN-4.DGN  
 F:\PROJECTS\2012\10-18-2012\1322023\BAJZEK\10-18-2012\1322023\TEMPORARY SIGN-4.DGN  
 F:\PROJECTS\2012\10-18-2012\1322023\BAJZEK\10-18-2012\1322023\TEMPORARY SIGN-4.DGN

**SIGN DETAIL**  
TEMP\_SIGN - 6

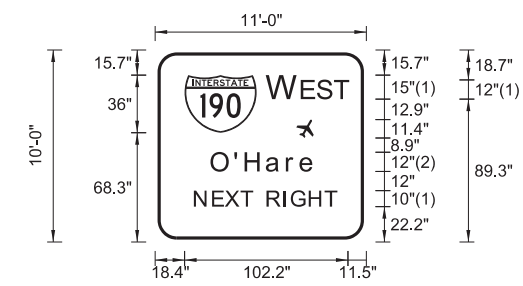


SIGN NUMBER	Temp_Sign - 6
WIDTH x HGHT.	11'-0" x 10'-0"
BORDER WIDTH	2"
CORNER RADIUS	12"
MOUNTING	Ground
BACKGROUND	TYPE: Reflective COLOR: Green
LEGEND/BORDER	TYPE: Reflective COLOR: White/White

SYMBOL	ROT	X	Y	WID	HT
M1_1	0	18.4	68.3	45	36
Airport	330	88.2	65	11.7	12

Panel Style: Guide\_Expressway\_Temporary.ssi  
 Dimensions are in inches.tenths  
 FONT:  
 (1) ClearviewHwy-4-W  
 (2) ClearviewHwy-5-W  
 Letter locations are panel edge to lower left corner

LETTER POSITIONS (X)											LENGTH	SERIES-SIZE
W	E	S	T									ClearviewHwy-4-W
70.6	91.8	101.8	112.5								49.9	15,12
O	'	H	a	r	e							ClearviewHwy-5-W
35.6	50.4	56.9	70.1	82.9	91.4						64.6	129.8
N	E	X	T		R	I	G	H	T			ClearviewHwy-4-W
24.9	36.2	44.2	53.9	60.6	70.3	80.4	85.4	96.6	106.5		88.2	10

**SIGN DETAIL**  
TEMP\_SIGN - 7

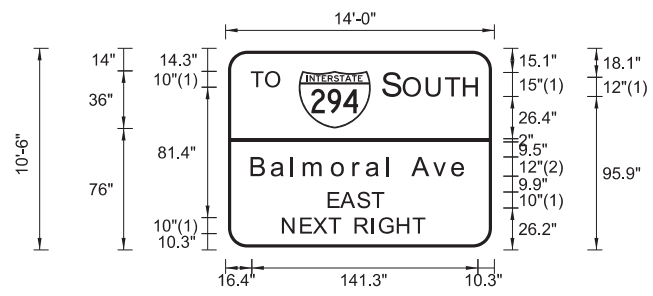

SIGN NUMBER	Temp_Sign - 7
WIDTH x HGHT.	14'-0" x 10'-6"
BORDER WIDTH	2"
CORNER RADIUS	12"
MOUNTING	Ground
BACKGROUND	TYPE: Reflective COLOR: Green
LEGEND/BORDER	TYPE: Reflective COLOR: White/White

SYMBOL	ROT	X	Y	WID	HT
M1_1	0	45.7	76	45	36

Panel Style: Guide\_Expressway\_Temporary.ssi  
 Dimensions are in inches.tenths  
 FONT:  
 (1) ClearviewHwy-4-W  
 (2) ClearviewHwy-5-W  
 Letter locations are panel edge to lower left corner

LETTER POSITIONS (X)											LENGTH	SERIES-SIZE	
T	O											ClearviewHwy-4-W	
16.4	25.4										17.7	10	
S	O	U	T	H								ClearviewHwy-4-W	
98.6	111.5	125.9	137.8	149.1							59.1	15,12	
B	a	I	m	o	r	a	I		A	v	e	ClearviewHwy-5-W	
16.7	29.2	42	49.4	67	80.4	88.7	101.4	105.2	117.2	130.4	142.2	134.3	129.8
E	A	S	T									ClearviewHwy-4-W	
64.5	72.4	82.9	91.8									34	10
N	E	X	T		R	I	G	H	T			ClearviewHwy-4-W	
36	47.3	55.2	64.9	71.6	81.3	91.4	96.4	107.6	117.5			88.2	10

FILE NAME =	USER NAME = *USER*	DESIGNED - MAM	REVISED -
*FILEL*		DRAWN - MAM	REVISED -
	PLOT SCALE = *SCALE*	CHECKED - KDA	REVISED -
	PLOT DATE = *DATE*	DATE - 10/19/12	REVISED -

**STATE OF ILLINOIS**  
**DEPARTMENT OF TRANSPORTATION**

**TEMPORARY INFORMATION SIGN**  
**MANNHEIM ROAD**

SCALE: N.T.S. SHEET NO. OF SHEETS STA. TO STA.

F.A. RTE.	SECTION	COUNTY	TOTAL SHEETS	SHEET NO.
	0105 WRS&HB	COOK	605	166
CONTRACT NO. 60G37				
ILLINOIS FED. AID PROJECT				



TENG & ASSOCIATES, INC.  
ENGINEERS/ARCHITECTS/PLANNERS  
CHICAGO, ILLINOIS