

SIGN NUMBER	CN-3
WIDTH x HGHT.	29'-6" x 12'-0"
BORDER WIDTH	2"
CORNER RADIUS	12"
MOUNTING	Overhead
BACKGROUND	TYPE: Reflective COLOR: Green
LEGENDBORDER	TYPE: Reflective COLOR: White/White


SYMBOL	ROT	X	Y	WID	HT
M1_1	0	22	93	45	36
M1_1	0	212.6	93	36	36
M1_1	0	268.6	93	45	36

FONT:
(1) ClearviewHwy-5-W

Letter locations are panel edge to lower left corner

Panel Style: guide_exp_advance_a.ssi
Dimensions are in inches.tenths

LETTER POSITIONS (X)													LENGTH	SERIES-SIZE	
E	A	S	T											EM 2000	
85	100.2	117.6	132											58.1	18.15
C	h	i	c	a	g	o									ClearviewHwy-5-W
20	42.2	63.2	74.2	92.3	112.7	134								129.4	2016.3
T	o	l	l	w	a	y	s								ClearviewHwy-5-W
192.1	211.5	233.7	246	256.1	283.3	302.1	321.3							141.9	2016.3
1	M	I	L	E											EM 2000
148.3	165.7	180.2	186	196.8										57.4	18.12

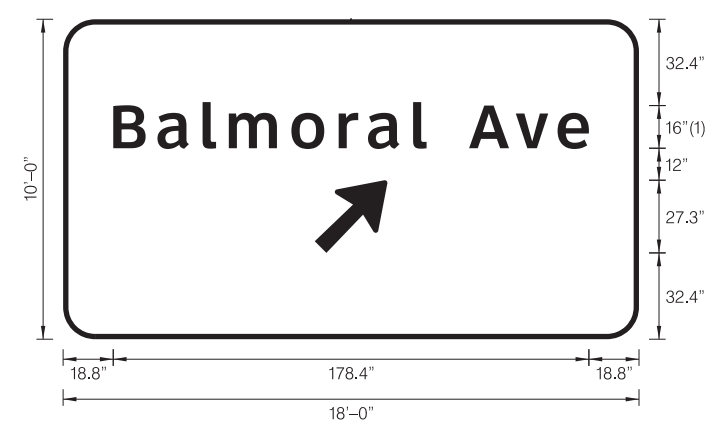

SIGN NUMBER	CS-2
WIDTH x HGHT.	18'-0" x 10'-0"
BORDER WIDTH	2"
CORNER RADIUS	12"
MOUNTING	Ground
BACKGROUND	TYPE: Reflective COLOR: Green
LEGENDBORDER	TYPE: Reflective COLOR: White/White

SYMBOL	ROT	X	Y	WID	HT
ARMED	45	94.4	32.4	22.3	35.1

FONT:
(1) ClearviewHwy-5-W

Letter locations are panel edge to lower left corner

Panel Style: guide_exp_advance_a.ssi
Dimensions are in Inches.tenths

LETTER POSITIONS (X)													LENGTH	SERIES-SIZE		
B	a	l	m	o	r	a	l		A	v	e				ClearviewHwy-5-W	
18.8	35.4	52.3	62.2	85.6	103.4	114.4	131.3	138.1	152.3	169.8	185.5				-1.5	1616



USER NAME = mkosir	DESIGNED DJJ	REVISED -
	DRAWN MMK	REVISED -
PLOT SCALE = 3:1	CHECKED LLS	REVISED -
PLOT DATE = 08-OCT-2012	DATE 10/19/12	REVISED -

STATE OF ILLINOIS
DEPARTMENT OF TRANSPORTATION

OVERHEAD SIGN STRUCTURES
SIGN PANEL DETAILS

SCALE: 1" = 3' SHEET NO. 1 OF 5 SHEETS STA. TO STA.

F.A.P. RTE.	SECTION	COUNTY	TOTAL SHEETS	SHEET NO.
330	0105 WRS&HB	COOK	605	216
				CONTRACT NO. 60G37
ILLINOIS FED. AID PROJECT				

SGN-PD-01