

SIGN NUMBER	TN-1-1
WIDTH x HIGHT.	14'-0" x 10'-6"
BORDER WIDTH	2"
CORNER RADIUS	12"
MOUNTING	Overhead
BACKGROUND	TYPE: Reflective COLOR: Green
LEGEND/BORDER	TYPE: Reflective COLOR: White/White

SYMBOL	ROT	X	Y	WID	HT
M1_1	0	18.7	72	45	36
6-53	0	120.2	44	29.3	30

Panel Style: guide_exp_advance_a.ssi
 Dimensions are in inches,tenths
 Letter locations are panel edge to lower left corner

FONT:
 (1) ClearviewHwy-5-W

LETTER POSITIONS (X)													LENGTH	SERIESSIZE		
W	E	S	T												EM 2000	
81.7	103.5	117.3	131.7												61.1	18,15
O	'	H	a	r	e											ClearviewHwy-5-W
18.4	38	46.8	64.2	81.2	92.5										85.8	16/13
1	M	I	L	E												EM 2000
55.3	72.7	87.2	93	103.8											57.4	18,12




SIGN NUMBER	name
WIDTH x HIGHT.	18'-0" x 10'-0"
BORDER WIDTH	2"
CORNER RADIUS	12"
MOUNTING	Overhead
BACKGROUND	TYPE: Reflective COLOR: Green
LEGEND/BORDER	TYPE: Reflective COLOR: Black,White/White

SYMBOL	ROT	X	Y	WID	HT
ARSHRT	45	93.8	6.5	20	22.5

Panel Style: guide_exp_advance_a.ssi
 Dimensions are in inches,tenths
 Letter locations are panel edge to lower left corner

FONT:
 (1) ClearviewHwy-5-W

LETTER POSITIONS (X)													LENGTH	SERIESSIZE			
B	a	l	m	o	r	a	l	A	v	e						ClearviewHwy-5-W	
19.6	36.2	53.1	62.9	86.4	104.2	115.2	132.1	138.9	153.1	170.6	186.3					-1.5	16/16
E	X	I	T														E 2000
44.4	55	67.9	72.1													36.7	12
O	N	L	Y														E 2000
123.8	136.7	149.5	159.5													47.9	12

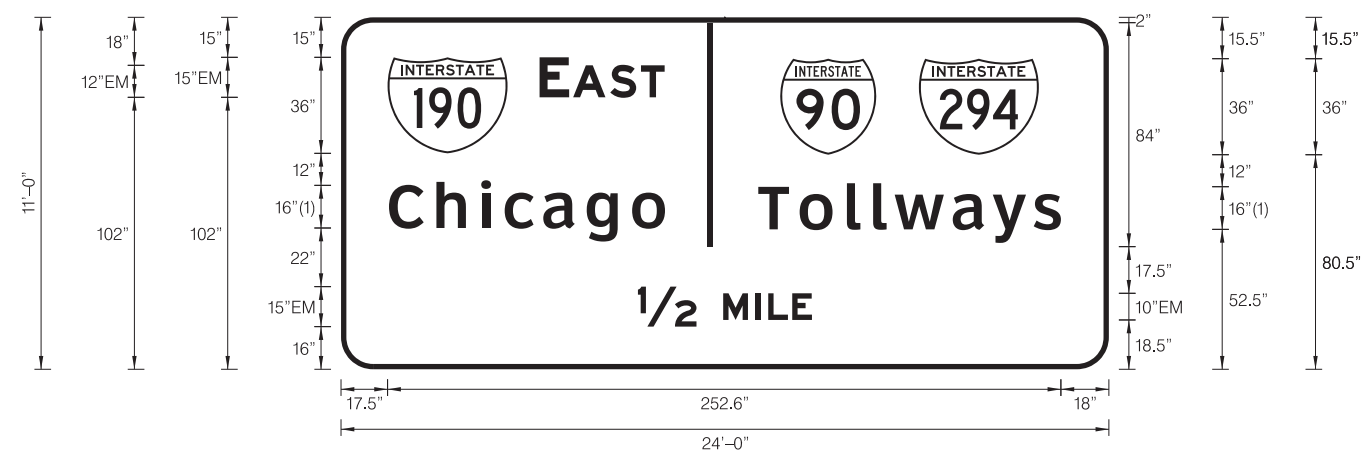

SIGN NUMBER	TN-1-2
WIDTH x HIGHT.	24'-0" x 11'-0"
BORDER WIDTH	2"
CORNER RADIUS	12"
MOUNTING	Overhead
BACKGROUND	TYPE: Reflective COLOR: Green
LEGEND/BORDER	TYPE: Reflective COLOR: White/White

SYMBOL	ROT	X	Y	WID	HT
M1_1	0	17.5	81	45	36
M1_1	0	164.7	80.5	36	36
M1_1	0	216.7	80.5	45	36

Panel Style: guide_exp_advance_a.ssi
 Dimensions are in inches,tenths

FONT:
 (1) ClearviewHwy-5-W

LETTER POSITIONS (X)													LENGTH	SERIESSIZE			
E	A	S	T													EM 2000	
74.5	87.1	101	112.5													46.9	15,12
C	h	i	c	a	g	o											ClearviewHwy-5-W
18	35.8	52.6	61.4	75.9	92.2	109.2										103.5	16/13
T	o	l	l	w	a	y	s										ClearviewHwy-5-W
156.5	172	189.8	199.6	207.7	229.5	244.5	259.8									113.5	16/13
12	M	I	L	E													EM 2000
111.4	143.3	155.4	160.2	169.2												65.3	15,10

Letter locations are panel edge to lower left corner



USER NAME = mkosir	DESIGNED DJJ	REVISED -
PLOT SCALE = 3:1	DRAWN MMK	REVISED -
PLOT DATE = 08-OCT-2012	CHECKED LLS	REVISED -
	DATE 10/19/12	REVISED -

STATE OF ILLINOIS
 DEPARTMENT OF TRANSPORTATION

OVERHEAD SIGN STRUCTURES	
SIGN PANEL DETAILS	
SCALE: 1" = 3'	SHEET NO. 2 OF 5 SHEETS
STA.	TO STA.

F.A.P. RTE.	SECTION	COUNTY	TOTAL SHEETS	SHEET NO.
330	0105 WRS&HB	COOK	605	217
CONTRACT NO. 60G37				
ILLINOIS FED. AID PROJECT				

SGN-PD-02