

SIGN NUMBER	TN-2-1
WIDTH x HIGHT.	14'-0" x 10'-6"
BORDER WIDTH	2"
CORNER RADIUS	12"
MOUNTING	Overhead
BACKGROUND	TYPE: Reflective COLOR: Green
LEGEND/BORDER	TYPE: Reflective COLOR: White/White


SYMBOL	ROT	X	Y	WID	HT
M1_1	0	18.7	72	45	36
6-53	0	120.2	44	29.3	30

Panel Style: guide_exp_advance_a.ssi
Dimensions are in inches.tenths

FONT:
(1) ClearviewHwy-5-W

Letter locations are panel edge to lower left corner

LETTER POSITIONS (X)											LENGTH	SERIES-SIZE	
W	E	S	T									EM 2000	
78.7	96.9	107.9	119.4									49.6	15,12
O	.	H	a	r	e							ClearviewHwy-5-W	
18.4	38	46.8	64.2	81.2	92.5							85.8	16/13
1/2	M	I	L	E								EM 2000	
51.4	83.3	95.4	100.2	109.2								65.3	15,10

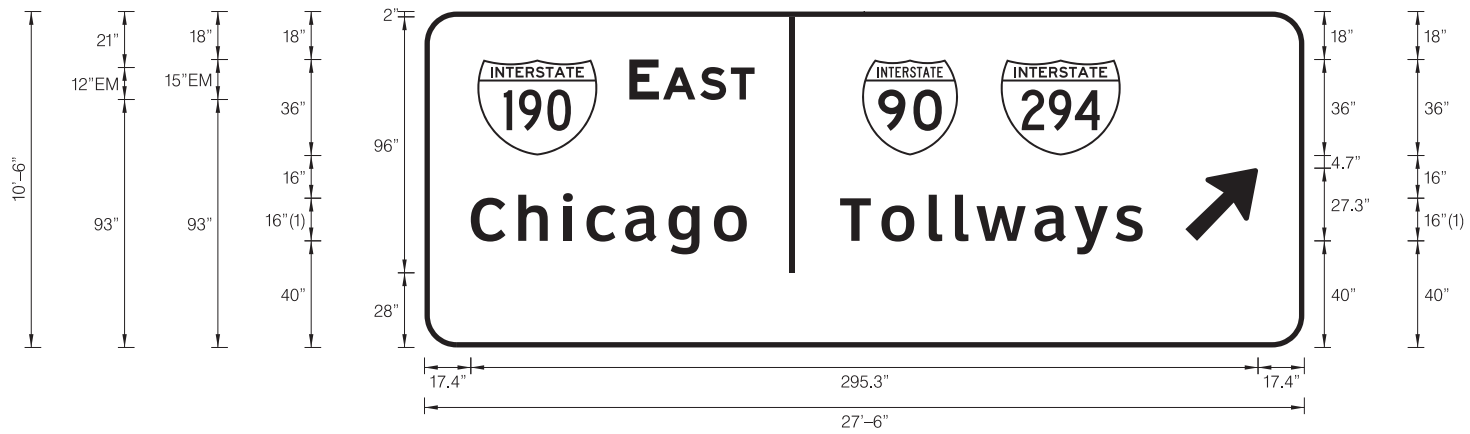

SIGN NUMBER	TN-2-2
WIDTH x HIGHT.	27'-6" x 10'-6"
BORDER WIDTH	2"
CORNER RADIUS	12"
MOUNTING	Overhead
BACKGROUND	TYPE: Reflective COLOR: Green
LEGEND/BORDER	TYPE: Reflective COLOR: White/White

SYMBOL	ROT	X	Y	WID	HT
M1_1	0	19.8	72	45	36
M1_1	0	164.1	72	36	36
M1_1	0	216.1	72	45	36
ARMED	45	285.4	40	22.3	35.1

Panel Style: guide_exp_advance_a.ssi
Dimensions are in inches.tenths

FONT:
(1) ClearviewHwy-5-W

Letter locations are panel edge to lower left corner

LETTER POSITIONS (X)											LENGTH	SERIES-SIZE	
E	A	S	T									EM 2000	
76.8	89.5	103.4	114.9									47	15,12
C	h	i	c	a	g	o						ClearviewHwy-5-W	
17.4	35.2	52	60.7	75.2	91.5	108.6						103.5	16/13
T	o	l	l	w	a	y	s					ClearviewHwy-5-W	
155.9	171.4	189.1	199	207	228.8	243.8	259.2					113.5	16/13

SGN-PD-03

HNTB	USER NAME = mkosir	DESIGNED DJJ	REVISED -	STATE OF ILLINOIS DEPARTMENT OF TRANSPORTATION	OVERHEAD SIGN STRUCTURES SIGN PANEL DETAILS			F.A.P. RTE.	SECTION	COUNTY	TOTAL SHEETS	SHEET NO.
		DRAWN MMK	REVISED -					330	0105 WRS&HB	COOK	605	218
	PLOT SCALE = 3:1	CHECKED LLS	REVISED -					CONTRACT NO. 60G37				
	PLOT DATE = 08-OCT-2012	DATE 10/19/12	REVISED -					SCALE: 1" = 3'	SHEET NO. 3 OF 5 SHEETS	STA.	TO STA.	ILLINOIS FED. AID PROJECT

FILE NAME = IP_PWP\dms47844\DI60G37-shit-sign-panels_03.dgn