

SIGN NUMBER	TN-3-1
WIDTH x HGHT.	14'-0" x 10'-6"
BORDER WIDTH	2"
CORNER RADIUS	12"
MOUNTING	Overhead
BACKGROUND	TYPE: Reflective COLOR: Green
LEGEND/BORDER	TYPE: Reflective COLOR: White/White


SYMBOL	ROT	X	Y	WID	HT
M1_1	0	18.7	72	45	36
6-53	0	120.2	44	29.3	30

Panel Style: guide\_exp\_advance\_a.ssi  
Dimensions are in inches.tenths

FONT:  
(1) ClearviewHwy-5-W

Letter locations are panel edge to lower left corner

LETTER POSITIONS (X)													LENGTH	SERIESIZE		
W	E	S	T												EM 2000	
78.7	96.9	107.9	119.4												49.6	15.12
O	.	H	a	r	e											ClearviewHwy-5-W
18.4	38	46.8	64.2	81.2	92.5										85.8	1613
N	E	X	T		R	I	G	H	T							EM 2000
39.4	50.3	59.1	68.9	76.3	86.3	96.5	100.9	111.4	121.3						89.3	10

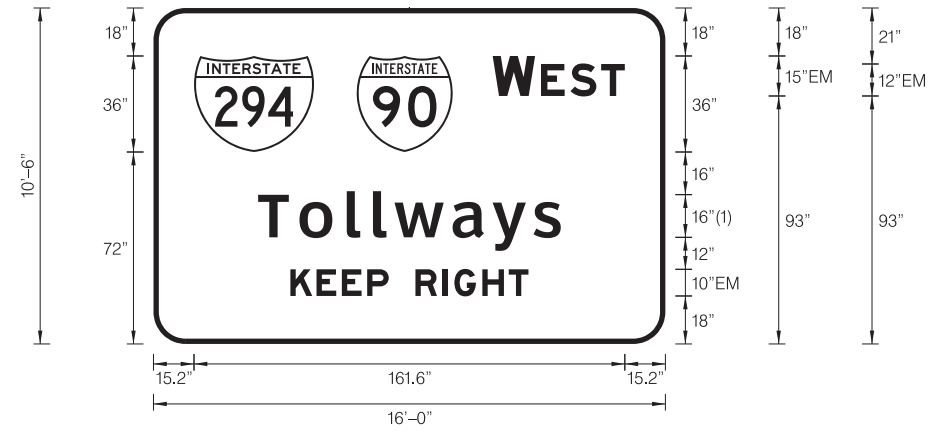

SIGN NUMBER	TN-3-3
WIDTH x HGHT.	16'-0" x 10'-6"
BORDER WIDTH	2"
CORNER RADIUS	12"
MOUNTING	Overhead
BACKGROUND	TYPE: Reflective COLOR: Green
LEGEND/BORDER	TYPE: Reflective COLOR: White/White


SYMBOL	ROT	X	Y	WID	HT
M1_1	0	15.2	72	45	36
M1_1	0	76.2	72	36	36

Panel Style: guide\_exp\_advance\_a.ssi  
Dimensions are in inches.tenths

FONT:  
(1) ClearviewHwy-5-W

Letter locations are panel edge to lower left corner

LETTER POSITIONS (X)													LENGTH	SERIESIZE			
W	E	S	T													EM 2000	
127.2	145.4	156.4	167.9													49.6	15.12
T	o	I	I	w	a	y	s										ClearviewHwy-5-W
39.3	54.8	72.5	82.3	90.4	112.2	127.2	142.6									113.5	1613
K	E	E	P		R	I	G	H	T								EM 2000
51.4	61.2	70.7	80.2	88.3	98.3	108.5	112.9	123.4	133.3							89.3	10

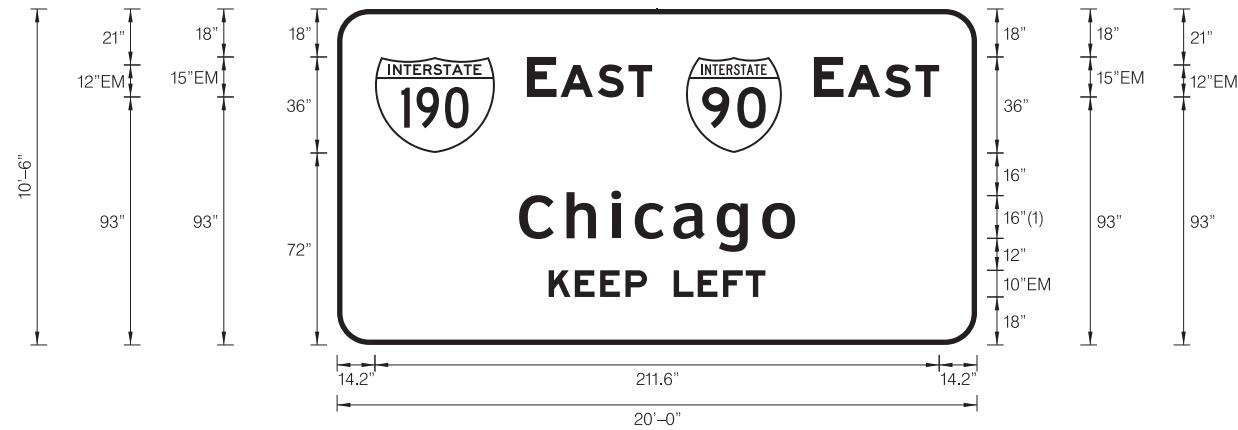

SIGN NUMBER	TN-3-2
WIDTH x HGHT.	20'-0" x 10'-6"
BORDER WIDTH	2"
CORNER RADIUS	12"
MOUNTING	Overhead
BACKGROUND	TYPE: Reflective COLOR: Green
LEGEND/BORDER	TYPE: Reflective COLOR: White/White

SYMBOL	ROT	X	Y	WID	HT
M1_1	0	14.2	72	45	36
M1_1	0	130.8	72	36	36

Panel Style: guide\_exp\_advance\_a.ssi  
Dimensions are in inches.tenths

FONT:  
(1) ClearviewHwy-5-W

Letter locations are panel edge to lower left corner

LETTER POSITIONS (X)													LENGTH	SERIESIZE			
E	A	S	T													EM 2000	
71.2	83.8	97.8	109.3													47	15.12
E	A	S	T														EM 2000
178.8	191.5	205.4	216.9													47	15.12
C	h	i	c	a	g	o											ClearviewHwy-5-W
68.3	86	102.8	111.6	126.1	142.4	159.4										103.5	1613
K	E	E	P		L	E	F	T									EM 2000
79.4	89.2	98.7	108.2	116.3	126.3	135.3	144.8	153.3								81.3	10

SGN-PD-04



USER NAME = mko51r  
DESIGNED DJJ  
DRAWN MMK  
PLOT SCALE = 3:1  
PLOT DATE = 08-OCT-2012

REVISIED -  
REVISIED -  
REVISIED -  
REVISIED -  
DATE 10/19/12

STATE OF ILLINOIS  
DEPARTMENT OF TRANSPORTATION

OVERHEAD SIGN STRUCTURES  
SIGN PANEL DETAILS

SCALE: 1" = 3' SHEET NO. 4 OF 5 SHEETS STA. TO STA.

F.A.P. RTE.	SECTION	COUNTY	TOTAL SHEETS	SHEET NO.
330	0105 WRS&HB	COOK	605	219
CONTRACT NO. 60G37				ILLINOIS FED. AID PROJECT