




| | |
|----------------|--|
| SIGN NUMBER | 214 |
| WIDTH x HIGHT. | 11'-2" x 6'-3" |
| BORDER WIDTH | 1.5" |
| CORNER RADIUS | 6" |
| MOUNTING | Ground |
| BACKGROUND | TYPE: Reflective COLOR: Blue |
| LEGENDBORDER | TYPE: Reflective COLOR: White/White |

| SYMBOL | ROT | X | Y | WID | HT |
|----------------------|-----|------|-----|-----|------|
| AR_Type A - Extended | 90 | 57.7 | 5.6 | 8.1 | 18.5 |

Panel Style: DOA_GENRAL.ssi
Dimensions are in inches.tenths

Letter locations are panel edge to lower left corner

| LETTER POSITIONS (X) | | | | | | | | | | | | | | | LENGTH | SERIESSIZE | | | | |
|----------------------|------|------|------|------|------|------|------|------|------|------|------|-------|-------|------|--------|------------|--------|-------|--------|--------|
| A | i | r | p | o | r | t | | | | | | | | | | | E 2000 | | | |
| 48.7 | 57.9 | 60.8 | 65.3 | 71.2 | 77.6 | 81.5 | | | | | | | | | | | 36.5 | 86 | | |
| M | a | i | n | t | e | n | a | n | c | e | | C | o | m | p | l | e | x | E 2000 | |
| 9.6 | 18.6 | 24.8 | 27.7 | 33.4 | 37.6 | 43.6 | 49.6 | 55.8 | 61.9 | 67.6 | 72.6 | 80.6 | 88.3 | 94.6 | 104.3 | 110.5 | 113.1 | 118.4 | 114.7 | 86 |
| E | a | s | t | | A | i | r | | C | a | r | g | o | | | | | | | E 2000 |
| 25.4 | 32.4 | 38.2 | 43.4 | 47.1 | 55.1 | 64.3 | 67.2 | 70.9 | 78.9 | 86.6 | 92.8 | 97.1 | 103.3 | | | | | | 83 | 86 |
| G | u | a | r | d | | P | o | s | t | | 1 | 1 | | | | | | | | E 2000 |
| 29.8 | 37.7 | 43.8 | 50 | 54.4 | 59.3 | 67.3 | 74.6 | 80.5 | 85.7 | 89.4 | 97.4 | 101.6 | | | | | | | 74.3 | 86 |

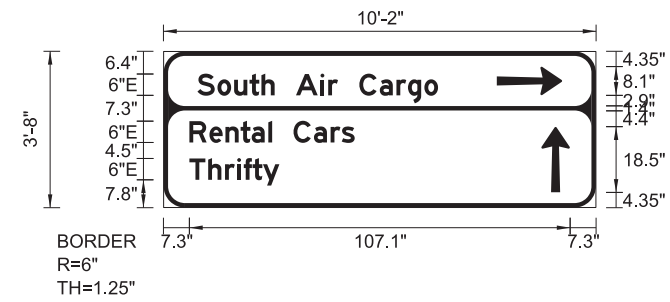


| | |
|----------------|--|
| SIGN NUMBER | 197 |
| WIDTH x HIGHT. | 10'-2" x 3'-8" |
| BORDER WIDTH | 1.25" |
| CORNER RADIUS | 6" |
| MOUNTING | Ground |
| BACKGROUND | TYPE: Reflective COLOR: Blue /Blue |
| LEGENDBORDER | TYPE: Reflective COLOR: White/White |

| SYMBOL | ROT | X | Y | WID | HT |
|----------------------|-----|-------|------|-----|------|
| AR_Type A - Extended | 270 | 93.7 | 31.6 | 8.1 | 18.5 |
| AR_Type A - Extended | 0 | 106.3 | 4.3 | 8.1 | 18.5 |

Panel Style: DOA_GENRAL.ssi
Dimensions are in inches.tenths

Letter locations are panel edge to lower left corner

| LETTER POSITIONS (X) | | | | | | | | | | | | | | | LENGTH | SERIESSIZE | | | | | |
|----------------------|------|------|------|------|------|------|------|------|------|------|------|------|------|------|--------|------------|--|--|--|--------|--------|
| S | o | u | t | h | | A | i | r | | C | a | r | g | o | | | | | | E 2000 | |
| 9.6 | 15.2 | 19.9 | 24.2 | 27.6 | 31.3 | 37.3 | 44.2 | 46.3 | 49.1 | 55.1 | 60.9 | 65.5 | 68.8 | 73.4 | | | | | | 67.7 | 64.5 |
| R | e | n | t | a | i | | C | a | r | s | | | | | | | | | | | E 2000 |
| 7.3 | 12.9 | 17.4 | 21.7 | 24.8 | 29.5 | 30.6 | 36.6 | 42.3 | 47 | 50.1 | | | | | | | | | | 46.5 | 64.5 |
| T | h | r | i | f | t | y | | | | | | | | | | | | | | | E 2000 |
| 7.3 | 12.6 | 17.3 | 20.7 | 22.6 | 25.1 | 28 | | | | | | | | | | | | | | 25.4 | 64.5 |

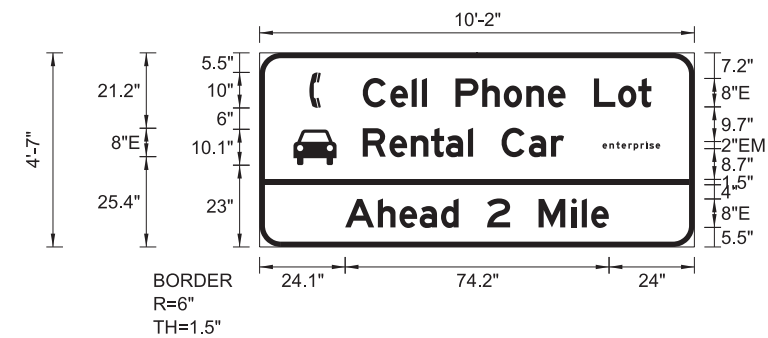


| | |
|----------------|--|
| SIGN NUMBER | 300 |
| WIDTH x HIGHT. | 10'-2" x 4'-7" |
| BORDER WIDTH | 1.5" |
| CORNER RADIUS | 6" |
| MOUNTING | Ground |
| BACKGROUND | TYPE: Reflective COLOR: Blue /Blue |
| LEGENDBORDER | TYPE: Reflective COLOR: White/White |

| SYMBOL | ROT | X | Y | WID | HT |
|--------------------|-----|-----|------|------|------|
| Telephone | 0 | 14 | 39.1 | 3.2 | 10 |
| Automobile (Front) | 0 | 9.5 | 23 | 12.2 | 10.1 |

Panel Style: DOA_GENRAL.ssi
Dimensions are in inches.tenths

Letter locations are panel edge to lower left corner

| LETTER POSITIONS (X) | | | | | | | | | | | | | | | LENGTH | SERIESSIZE | | | | | |
|----------------------|------|-------|-------|-------|-------|-------|-------|-------|-------|------|------|-------|-------|--|--------|------------|--|--|--|--------|---------|
| C | e | i | l | | P | h | o | n | e | | L | o | t | | | | | | | E 2000 | |
| 29 | 36.8 | 42.8 | 45.6 | 47.1 | 55.1 | 62.6 | 68.7 | 75 | 81.1 | 86 | 94 | 100.8 | 106.5 | | | | | | | 81.3 | 86 |
| e | n | t | e | r | p | r | i | s | e | | | | | | | | | | | | EM 2000 |
| 96.4 | 98.4 | 100.3 | 101.8 | 103.7 | 105.2 | 107.2 | 108.6 | 109.6 | 111.4 | | | | | | | | | | | 16.4 | 21.5 |
| R | e | n | t | a | i | | C | a | r | | | | | | | | | | | | E 2000 |
| 29 | 36.5 | 42.5 | 48.2 | 52.4 | 58.6 | 60 | 68 | 75.7 | 82 | | | | | | | | | | | 56.7 | 86 |
| A | h | e | a | d | | 2 | | M | i | l | e | | | | | | | | | | E 2000 |
| 24.1 | 33.3 | 39.3 | 45 | 51 | 56 | 64 | 70.5 | 78.5 | 87.7 | 90.6 | 93.3 | | | | | | | | | 74.2 | 86 |

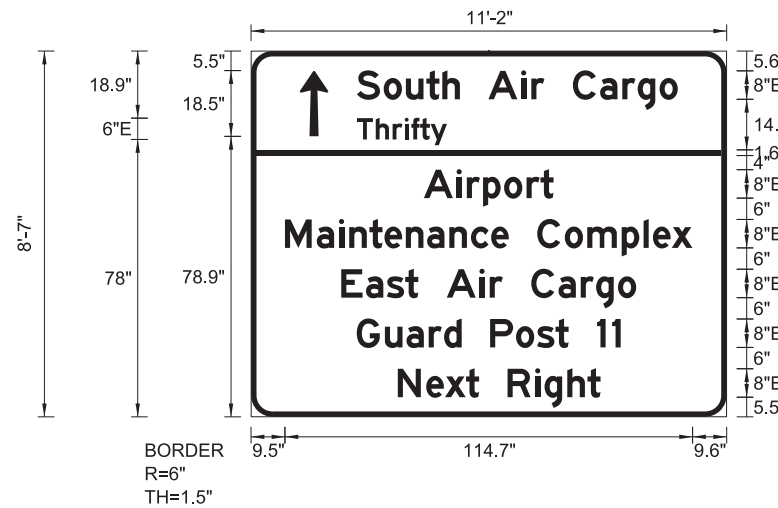

| | |
|----------------|--|
| SIGN NUMBER | 232 |
| WIDTH x HIGHT. | 11'-2" x 8'-7" |
| BORDER WIDTH | 1.5" |
| CORNER RADIUS | 6" |
| MOUNTING | Ground |
| BACKGROUND | TYPE: Reflective COLOR: Blue /Blue |
| LEGENDBORDER | TYPE: Reflective COLOR: White/White |

| SYMBOL | ROT | X | Y | WID | HT |
|----------------------|-----|------|------|-----|------|
| AR_Type A - Extended | 0 | 13.7 | 78.9 | 8.1 | 18.5 |

Panel Style: DOA_GENRAL.ssi
Dimensions are in inches.tenths

Letter locations are panel edge to lower left corner

| LETTER POSITIONS (X) | | | | | | | | | | | | | | | LENGTH | SERIESSIZE | | | | | | |
|----------------------|------|------|------|------|------|------|------|------|------|------|------|-------|-------|-------|--------|------------|-------|-------|--|-------|--------|------|
| S | o | u | t | h | | A | i | r | | C | a | r | g | o | | | | | | | E 2000 | |
| 29.8 | 37.3 | 43.6 | 49.3 | 53.8 | 58.8 | 66.8 | 76 | 78.8 | 82.5 | 90.5 | 98.2 | 104.4 | 108.8 | 114.9 | | | | | | | 90.3 | 86 |
| T | h | r | i | f | t | y | | | | | | | | | | | | | | | E 2000 | |
| 29.8 | 35.1 | 39.8 | 43.2 | 45.1 | 47.6 | 50.5 | | | | | | | | | | | | | | | 25.4 | 64.5 |
| A | i | r | p | o | r | t | | | | | | | | | | | | | | | E 2000 | |
| 48.6 | 57.8 | 60.7 | 65.3 | 71.2 | 77.5 | 81.4 | | | | | | | | | | | | | | | 36.6 | 86 |
| M | a | i | n | t | e | n | a | n | c | e | | C | o | m | p | l | e | x | | | E 2000 | |
| 9.5 | 18.5 | 24.7 | 27.6 | 33.3 | 37.5 | 43.5 | 49.5 | 55.8 | 61.9 | 67.5 | 72.5 | 80.5 | 88.3 | 94.6 | 104.3 | 110.4 | 113.1 | 118.3 | | 114.7 | 86 | |
| E | a | s | t | | A | i | r | | C | a | r | g | o | | | | | | | | E 2000 | |
| 25.4 | 32.3 | 38.2 | 43.4 | 47.1 | 55.1 | 64.3 | 67.1 | 70.8 | 78.8 | 86.5 | 92.7 | 97.1 | 103.2 | | | | | | | 83 | 86 | |
| G | u | a | r | d | | P | o | s | t | | 1 | 1 | | | | | | | | | E 2000 | |
| 29.7 | 37.7 | 43.7 | 50 | 54.3 | 59.3 | 67.3 | 74.5 | 80.5 | 85.7 | 89.3 | 97.3 | 101.6 | | | | | | | | 74.3 | 86 | |
| N | e | x | t | | R | i | g | h | t | | | | | | | | | | | | E 2000 | |
| 41.3 | 49.3 | 54.6 | 60.5 | 64.2 | 72.2 | 79.9 | 82.6 | 89 | 94.6 | | | | | | | | | | | 57.1 | 86 | |



| | | |
|-------------------------|------------------|-----------|
| USER NAME = micosir | DESIGNED LLS/MMK | REVISED - |
| | DRAWN MMK | REVISED - |
| PLOT SCALE = 3:1 | CHECKED LLS | REVISED - |
| PLOT DATE = 08-OCT-2012 | DATE 10/19/12 | REVISED - |

STATE OF ILLINOIS
DEPARTMENT OF TRANSPORTATION

GROUND MOUNTED SIGN STRUCTURES
SIGN PANEL DETAILS

SCALE: 1" = 3' SHEET NO. 5 OF 5 SHEETS STA. TO STA.

| | | | | |
|---------------------------|-------------|--------|--------------|--------------------|
| F.A.P. RTE. | SECTION | COUNTY | TOTAL SHEETS | SHEET NO. |
| 330 | 0105 WRS&HB | COOK | 605 | 220 |
| | | | | CONTRACT NO. 60G37 |
| ILLINOIS FED. AID PROJECT | | | | |