


NOTES:
 1. MAINTAIN EXISTING LIGHTING THRU STAGE 1 FROM LAWRENCE AVE TO RAMP A.

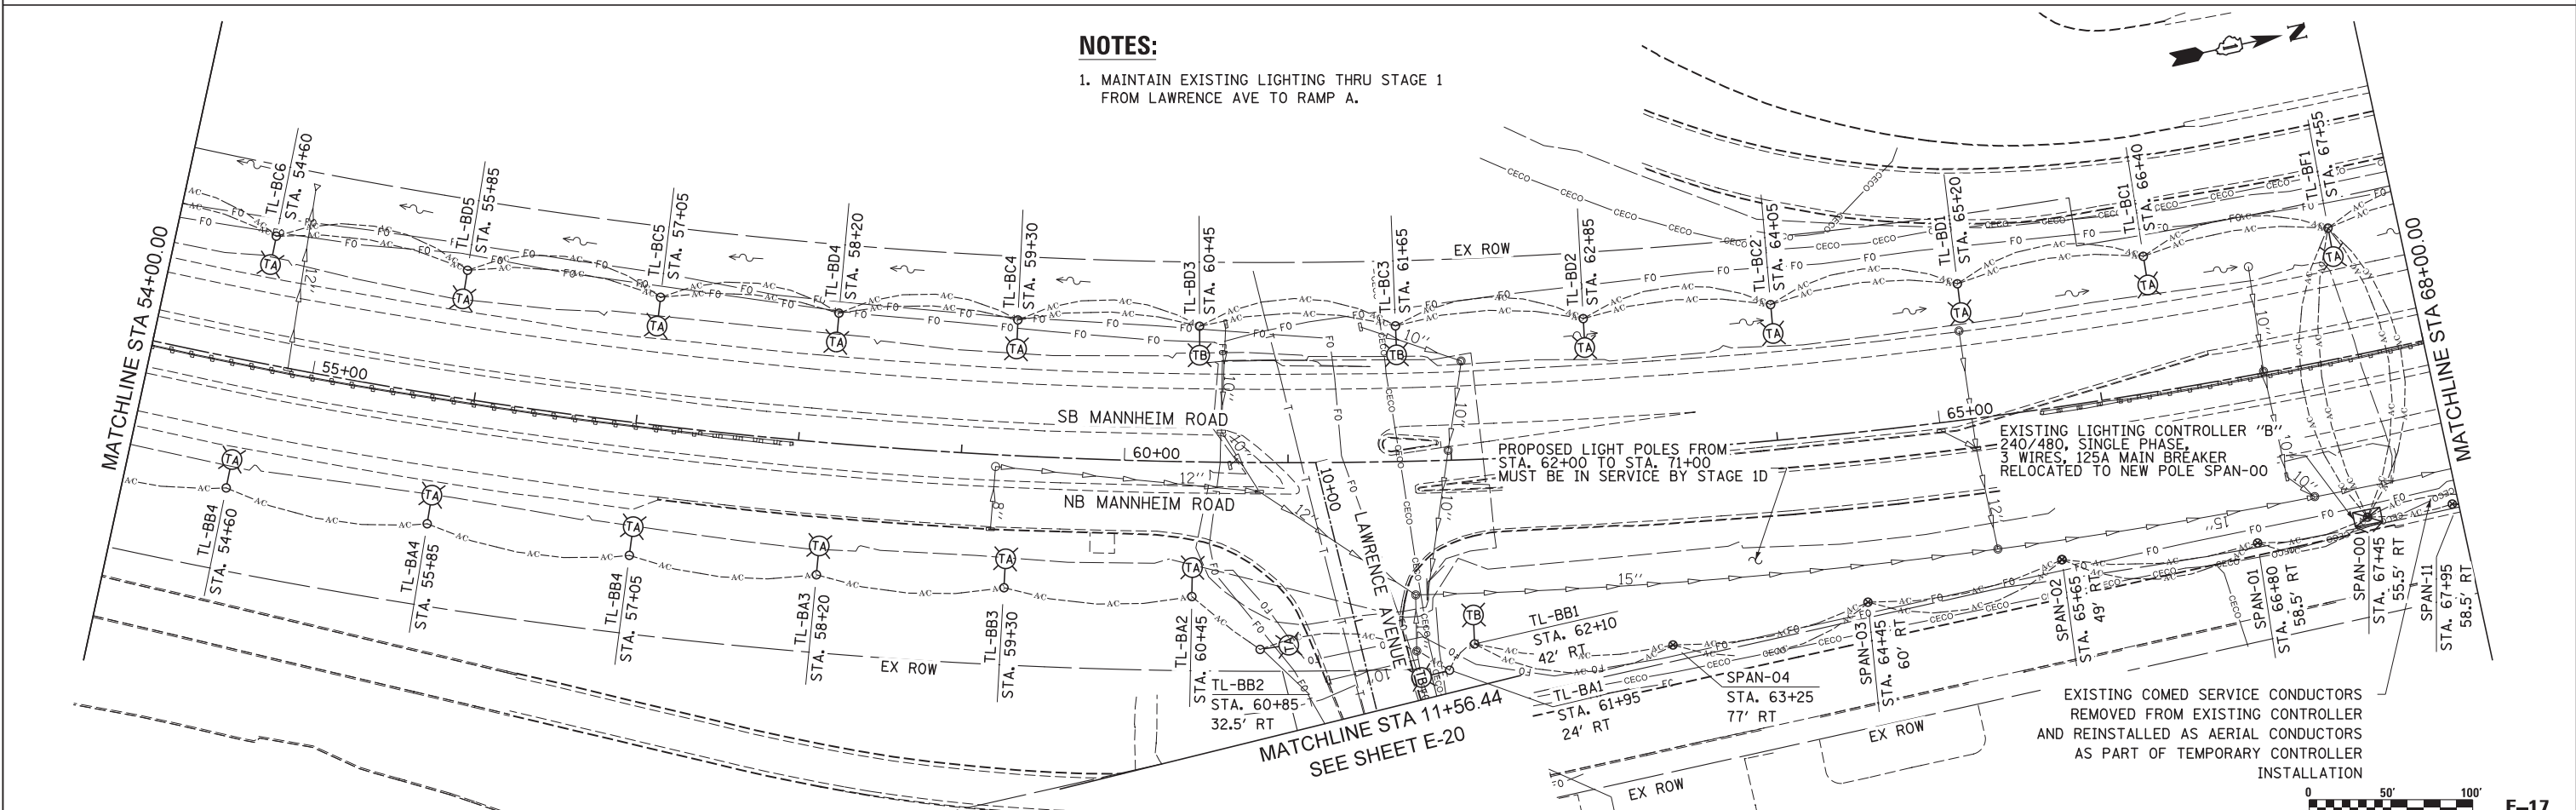

USER NAME = mkosir
 PLOT SCALE = 50:1
 PLOT DATE = 19-OCT-2012

DESIGNED KA
 DRAWN MMK
 CHECKED MCD
 DATE 10/19/12

REVISED -
 REVISED -
 REVISED -
 REVISED -

STATE OF ILLINOIS
 DEPARTMENT OF TRANSPORTATION

TEMPORARY LIGHTING PLAN
 PRESTAGE
 MANNHEIM ROAD

SCALE: 1" = 50' SHEET NO. 2 OF 5 SHEETS STA. 40+00.00 TO STA. 68+00.00

F.A.P. RTE.	SECTION	COUNTY	TOTAL SHEETS	SHEET NO.
330	0105 WRS&HB	COOK	605	303
				CONTRACT NO. 60G37
ILLINOIS FED. AID PROJECT				