
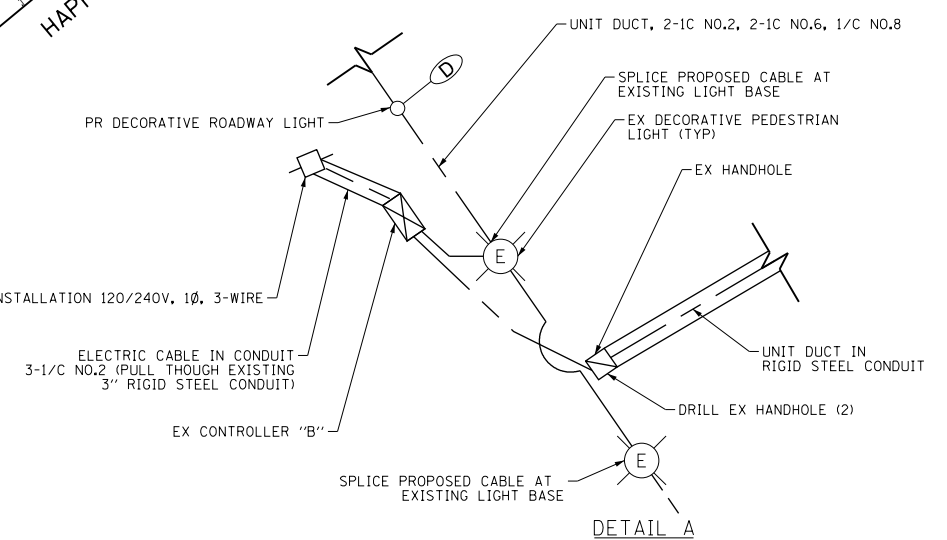


**NOTES:**  
 1. SEE SHEET NO. 424 FOR LEGEND AND GENERAL NOTES.

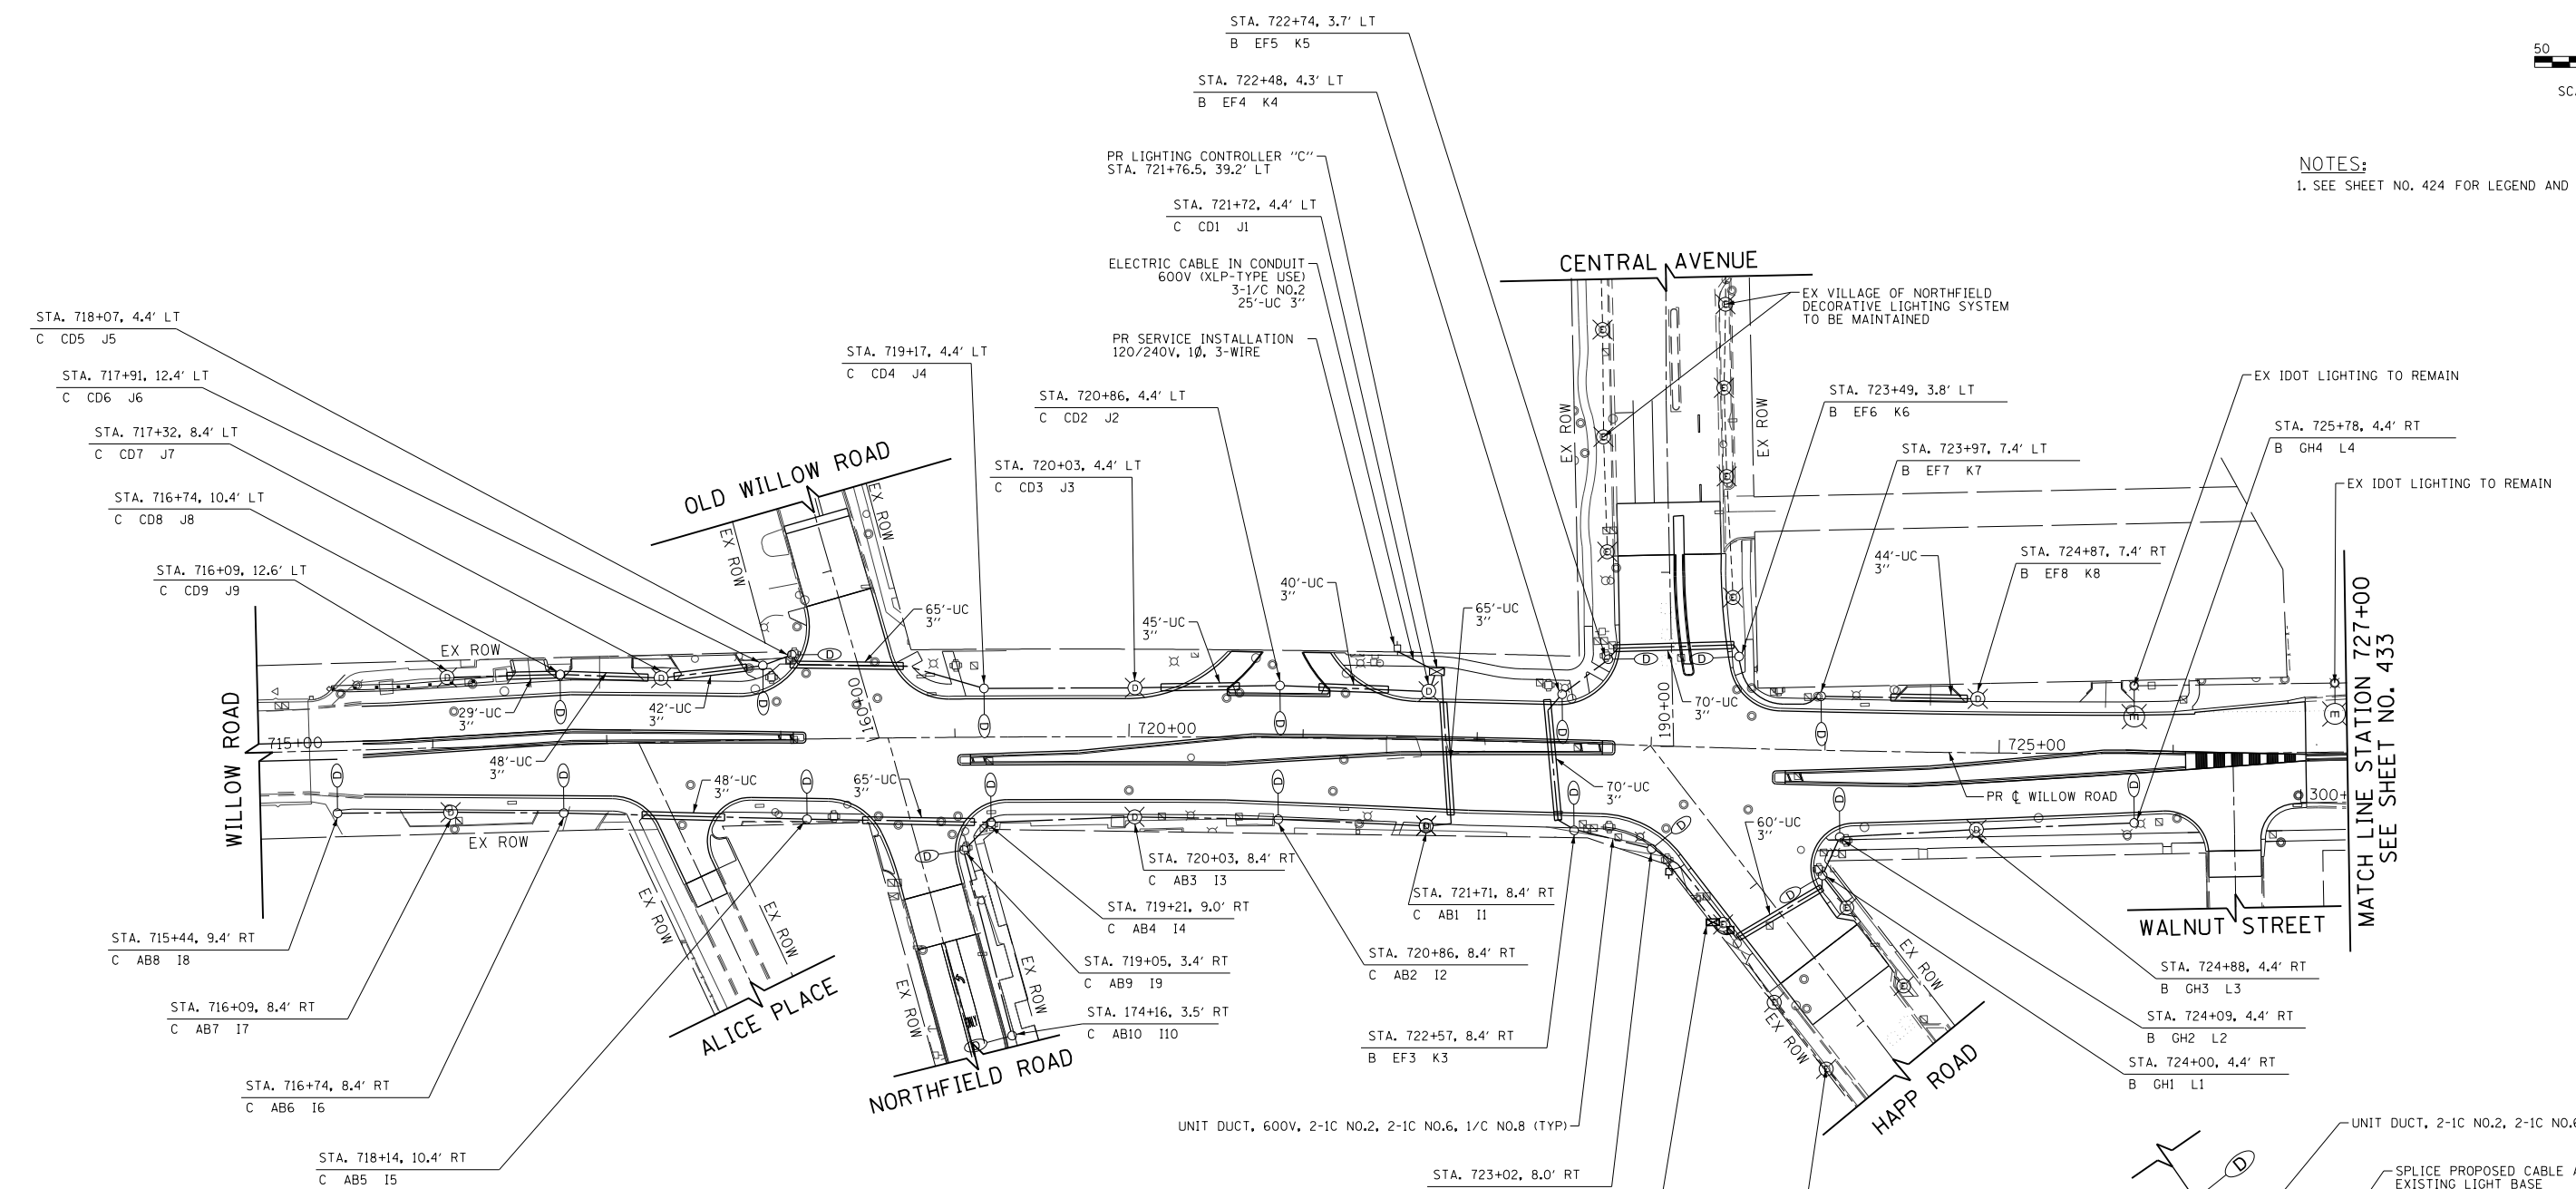

FILE NAME = G:\CH11\0158\Road\Road-CD\Lighting\0160135-SHT-LIGHT-07.dgn	USER NAME = BAWtor.t	DESIGNED - SRF	REVISED -	<b>STATE OF ILLINOIS DEPARTMENT OF TRANSPORTATION</b>	<b>LIGHTING PLAN WILLOW ROAD (DOWNTOWN)</b>			F.A.P. R.E. = 305	SECTION = (1920.01,1518,2022&1922.4BR)	COUNTY = COOK	TOTAL SHEETS = 919	SHEET NO. = 430
PLOT SCALE = 100.000' / in.	CHECKED - SRF	REVISIED -	REVISIED -		SCALE: 1" = 50'	SHEET NO. 430 OF 919 SHEETS	STA. 715+00	TO STA. 727+00	CONTRACT NO. 60T35			
PLOT DATE = 11/1/2012	DATE - 10/31/2012	REVISIED -	REVISIED -		FED. ROAD DIST. NO. 1 ILLINOIS FED. AID PROJECT							