



PLAN
 1:1
 1" = 20'
 1/8" = 10'
 1/16" = 5'
 1/32" = 2.5'
 1/64" = 1.25'

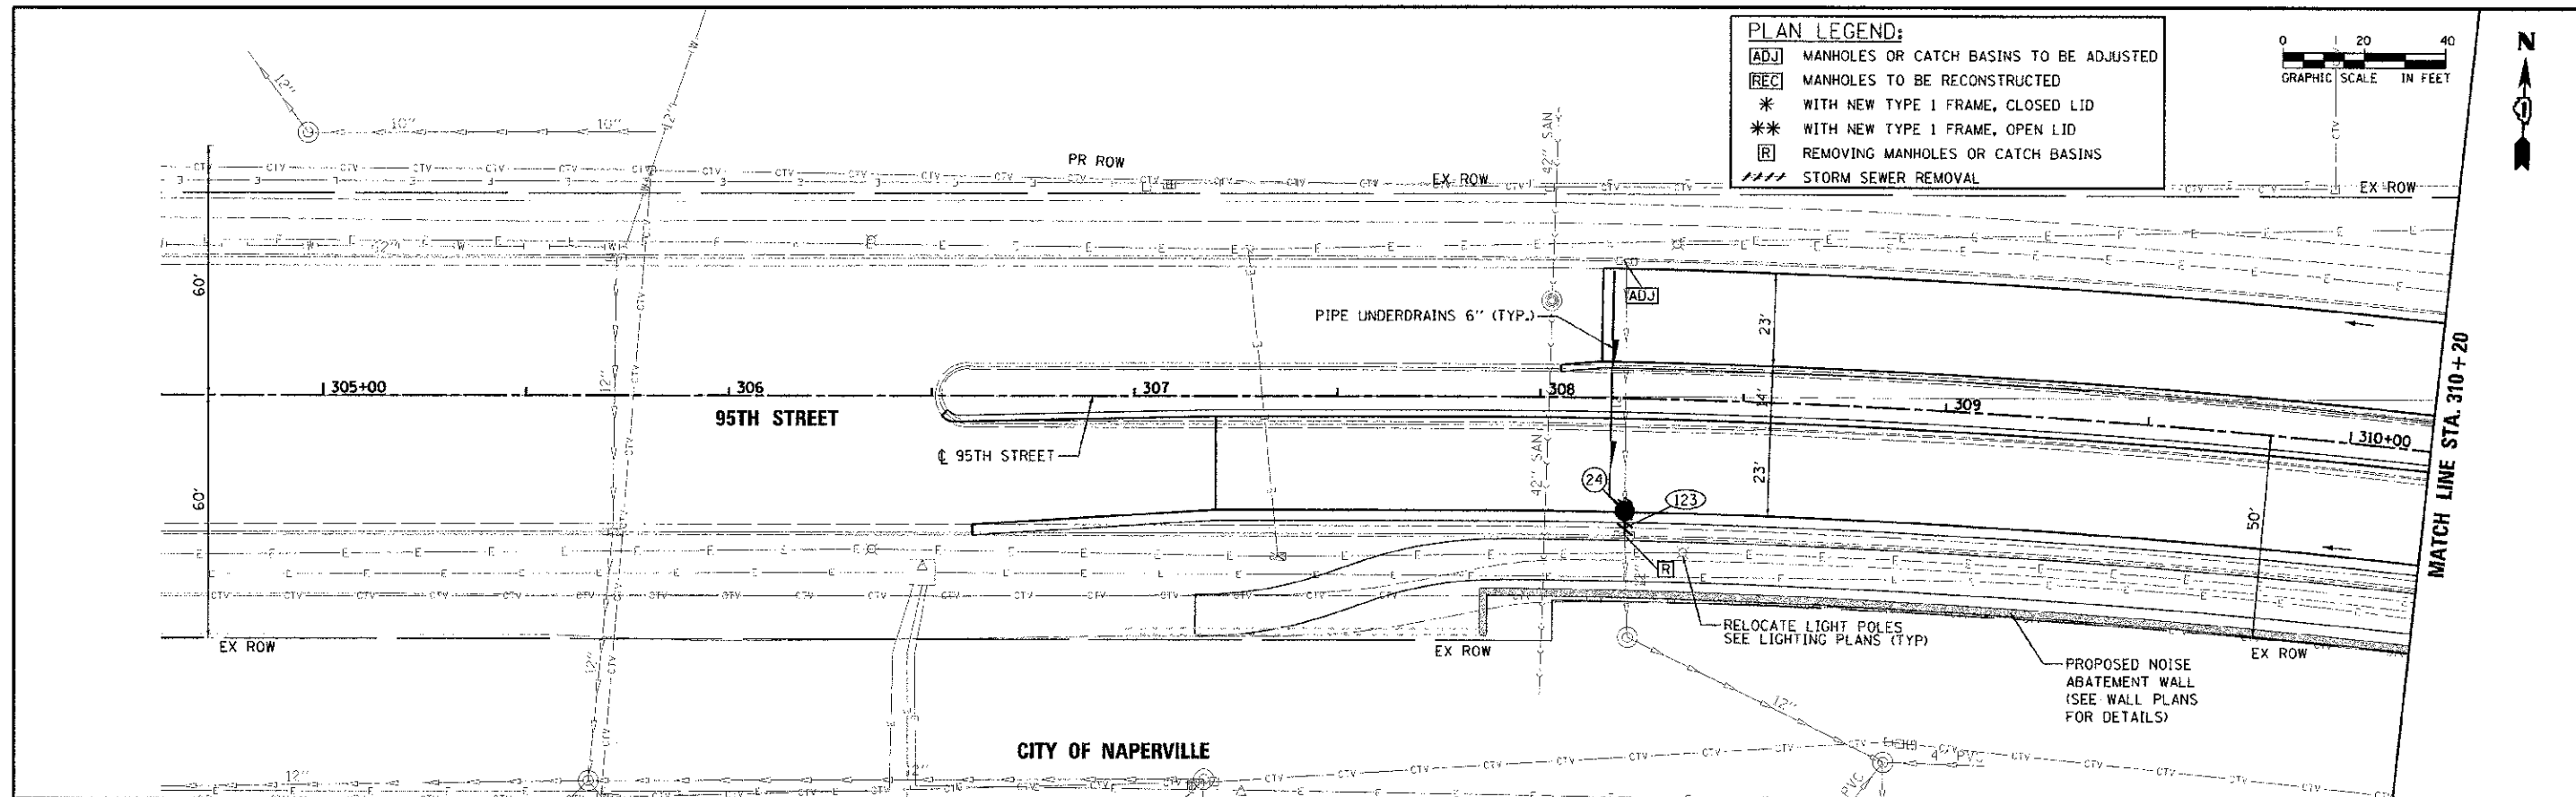

PLAN LEGEND:

- ADJ MANHOLES OR CATCH BASINS TO BE ADJUSTED
- REC MANHOLES TO BE RECONSTRUCTED
- * WITH NEW TYPE 1 FRAME, CLOSED LID
- ** WITH NEW TYPE 1 FRAME, OPEN LID
- R REMOVING MANHOLES OR CATCH BASINS
- STORM SEWER REMOVAL

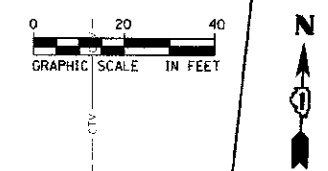


DRAINAGE STRUCTURE TABLE

STR. NO.	STA.	OFFSET	MH	CB	INL	OTHER	FRAME AND GRATE	N	S	E	W	RIM ELEV.
24	306+21.4	28.0	RT	TA			T-24	649.33	649.33			654.84

DRAINAGE PIPE TABLE

PIPE NO.	STR. NO. FROM	STR. NO. TO	DESCRIPTION	IN DIA.	FT LEN.	SLOPE	CU YD TBF
123	24	ex	SS, CLA, TY 2	12	5.0	0.17%	1.2

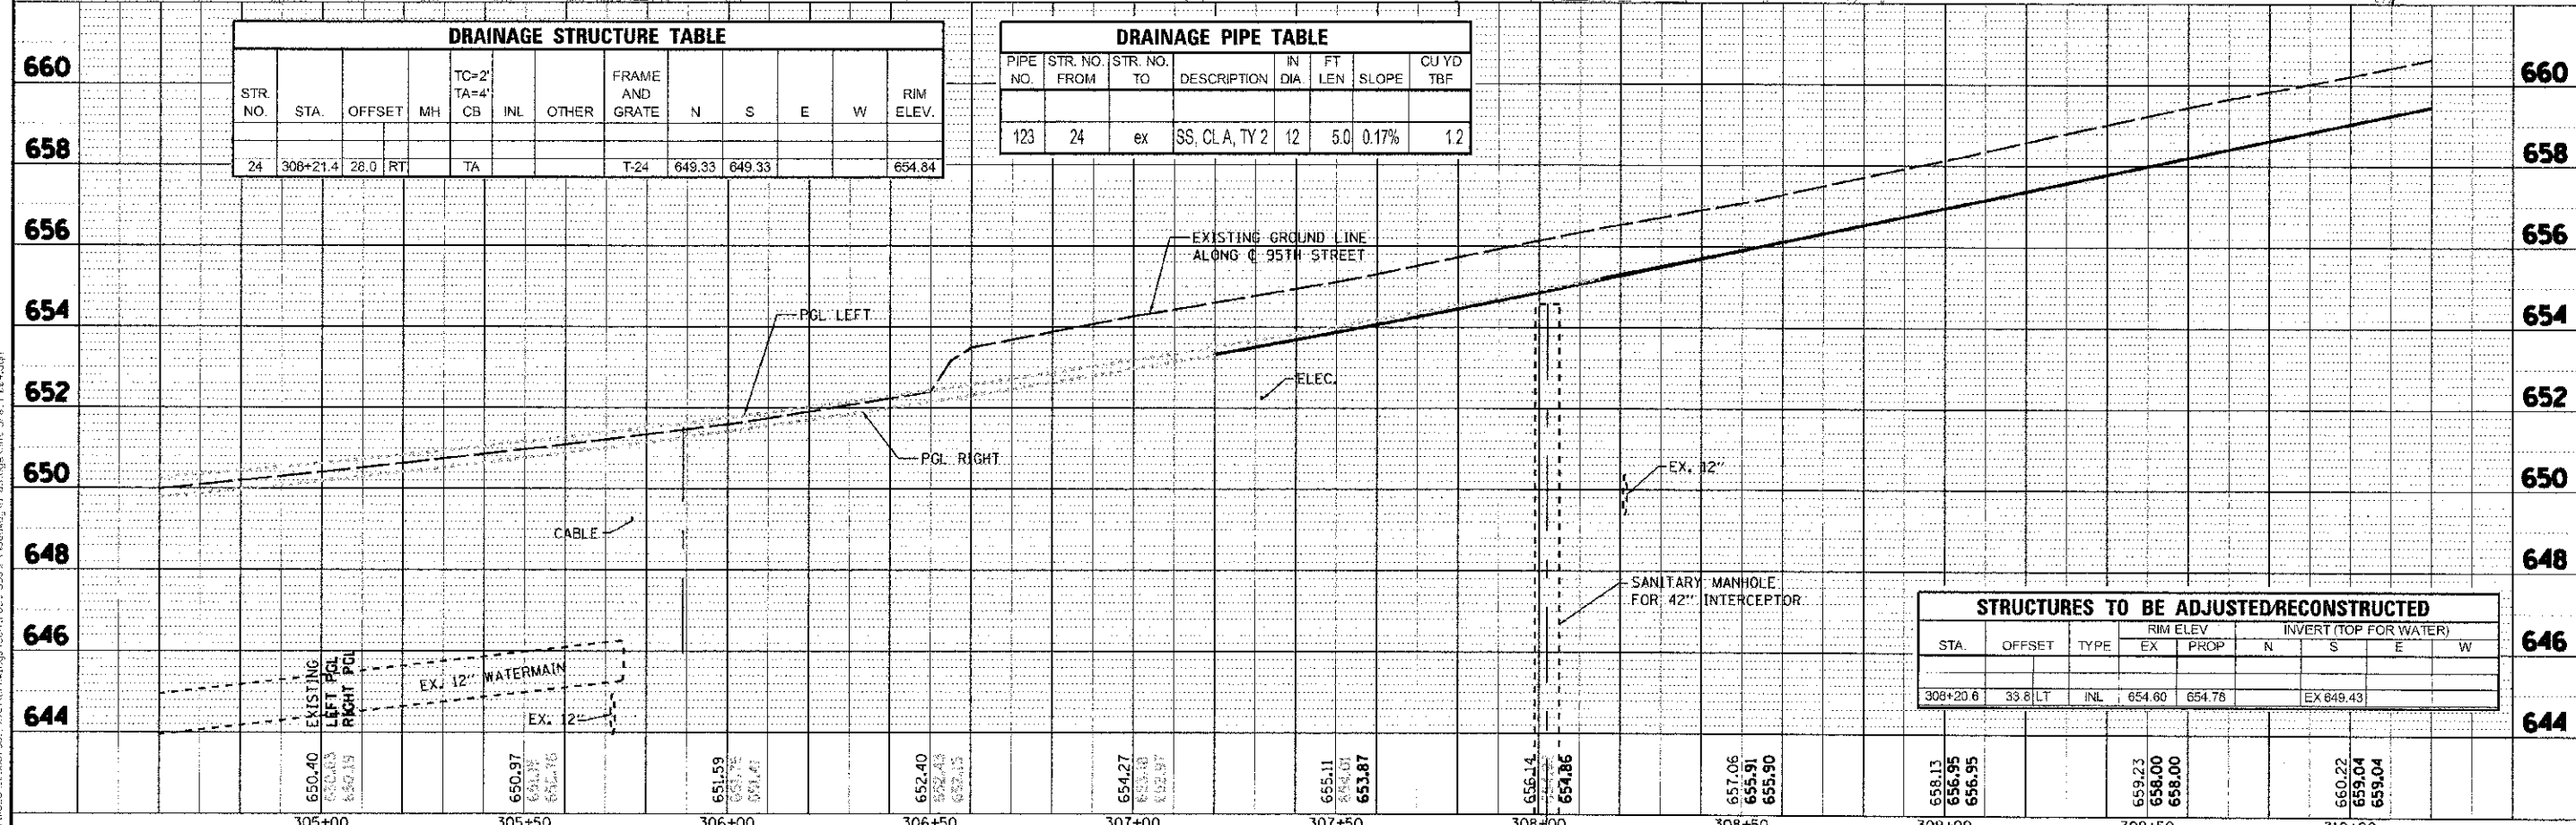

STRUCTURES TO BE ADJUSTED/RECONSTRUCTED

STA.	OFFSET	TYPE	RIM ELEV.		INVERT (TOP FOR WATER)				
			EX	PROP	N	S	E	W	
308+20.6	33.8	LT	INL	654.60	654.76			EX 649.43	

URS 100 S. WACKER DR., SUITE 500, CHICAGO, IL 60606

DESIGNED	JRP	REVISED	-
DRAWN	KB	REVISED	-
CHECKED	JRP	REVISED	-
DATE	10/19/2012	REVISED	-

STATE OF ILLINOIS
DEPARTMENT OF TRANSPORTATION

95TH STREET
DRAINAGE & UTILITY PLANS

SCALE: 1" = 20' DRAWING NO. 1 OF 18 STA. 304+60 TO STA. 310+20

F.A.U. RTE.	SECTION	COUNTY	TOTAL SHEETS	SHEET NO.
1644	01-00161-00-FP	WILL	328	72
CONTRACT NO. 63647				