


PLAN LEGEND:

- ADJ MANHOLES OR CATCH BASINS TO BE ADJUSTED
- REC MANHOLES TO BE RECONSTRUCTED
- * WITH NEW TYPE 1 FRAME, CLOSED LID
- ** WITH NEW TYPE 1 FRAME, OPEN LID
- R REMOVING MANHOLES OR CATCH BASINS
- STORM SEWER REMOVAL

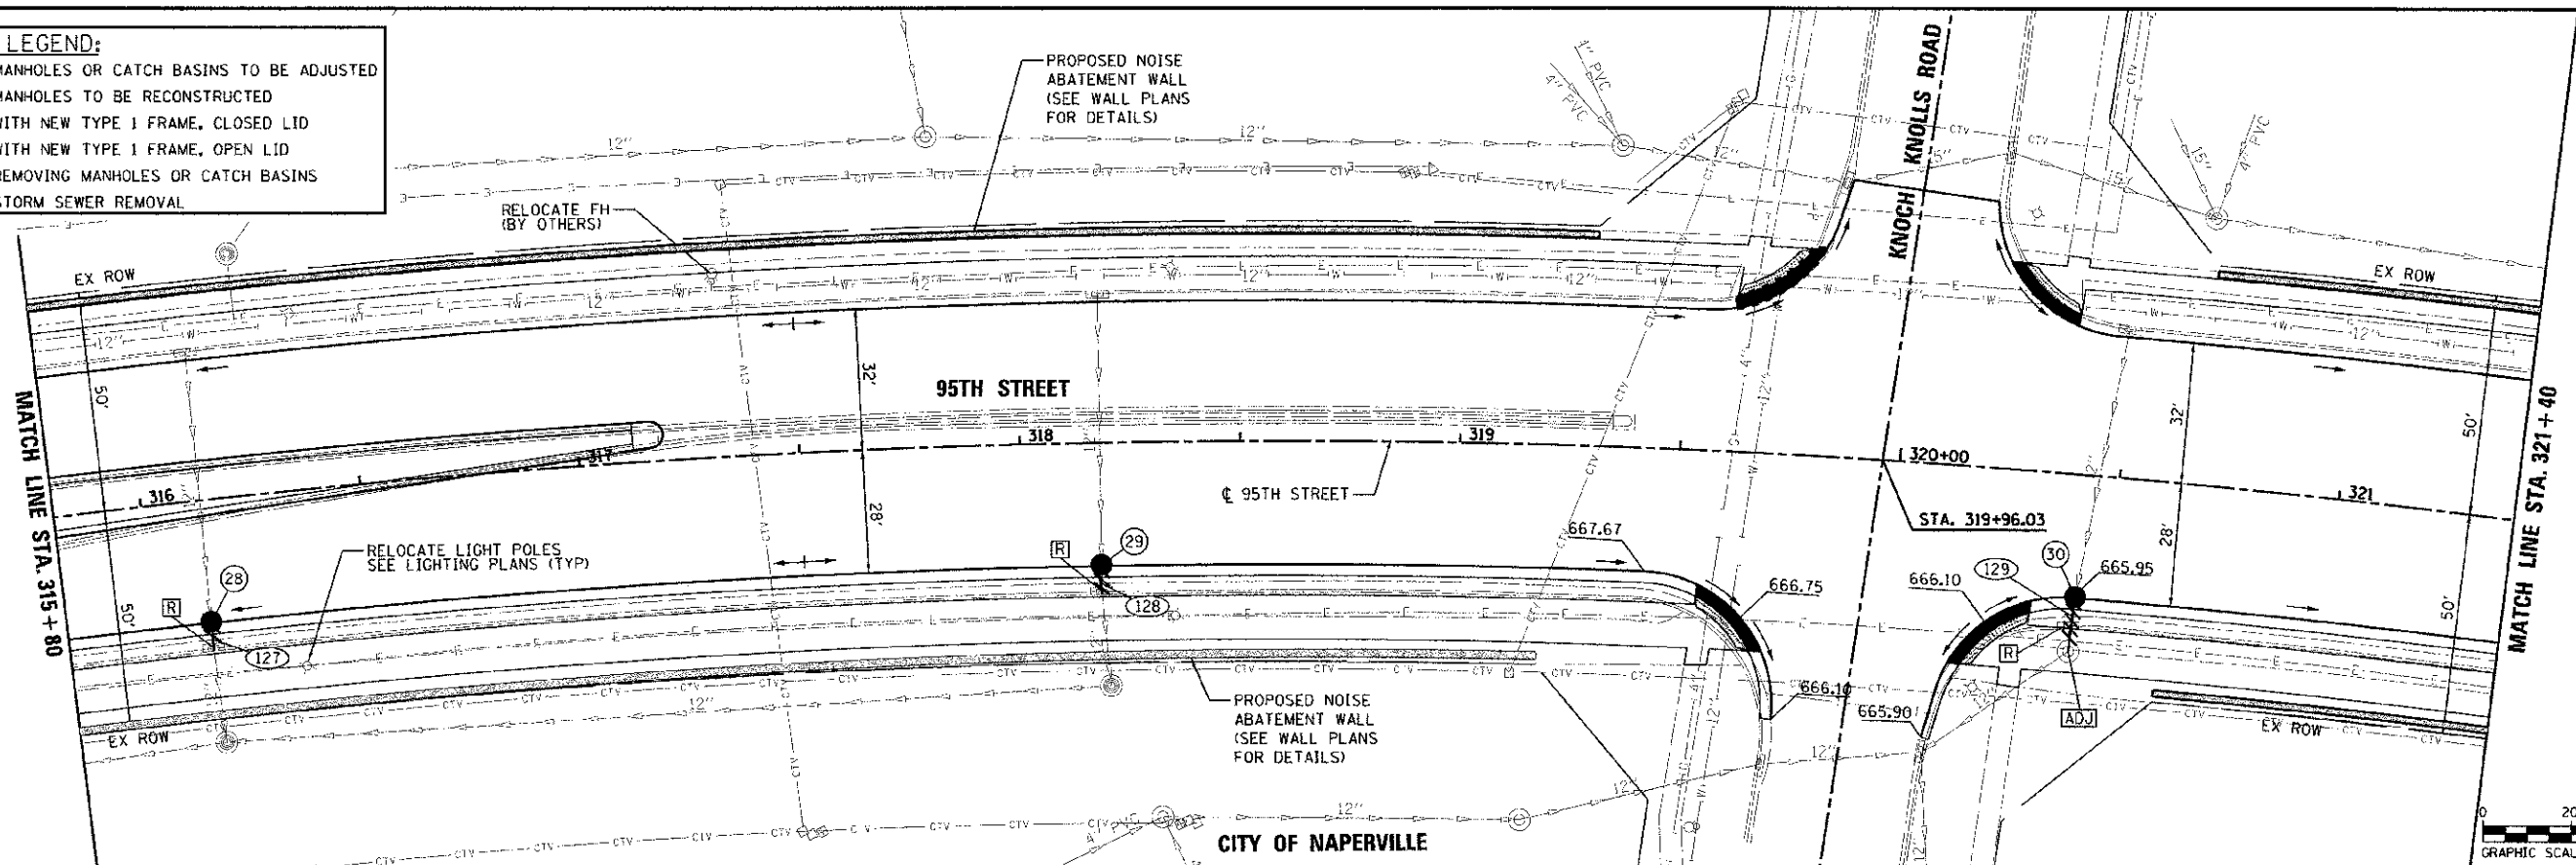

674

672

670

668

666

664

662

660

658

DRAINAGE STRUCTURE TABLE


STR. NO.	STA.	OFFSET	MH	CB	INL	OTHER	FRAME AND GRATE	N	S	E	W	RIM ELEV.
28	316+13.0	28.0	RT	TA			T-24	663.85	663.76			668.64
29	318+18.1	25.0	RT	TA			T-24	664.81	664.90			668.90
30	320+42.1	28.0	RT	TA			T-24	661.72	661.72			665.95

DRAINAGE PIPE TABLE

PIPE NO.	STR. NO. FROM	STR. NO. TO	DESCRIPTION	IN DIA.	FT LEN.	SLOPE	CU YD TBF
127	28	ex	SS, CL A, TY 2	12	6.0	0.33%	1.0
128	29	ex	SS, CL A, TY 1	12	6.0	0.33%	0.8
129	30	ex	SS, CL A, TY 2	12	9.0	1.45%	1.2

STRUCTURES TO BE ADJUSTED/RECONSTRUCTED

STA.	OFFSET	TYPE	RIM ELEV		INVERT (TOP FOR WATER)				
			EX	PROP	N	S	E	W	
320+41.0	40.1	RT	MH	666.26	666.70	EX 661.59			EX 661.55

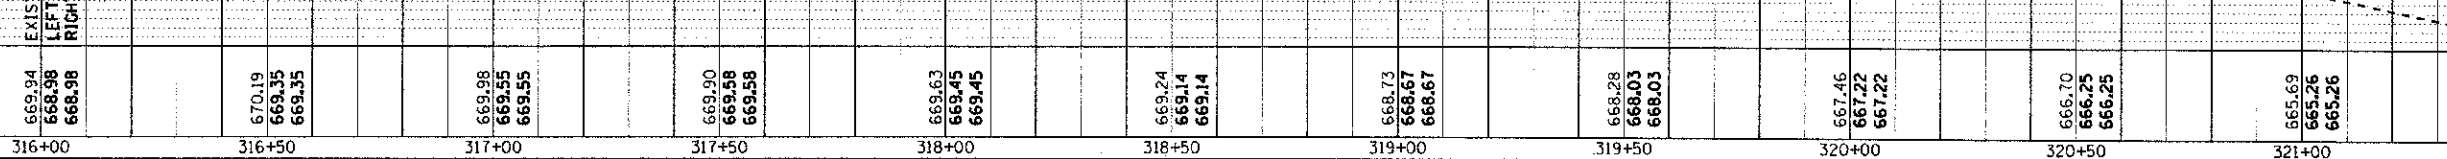

URS	100 S. WACKER DR. SUITE 500 CHICAGO, IL 60606 TEL (312) 939-4900 FAX (312) 939-4998	USER NAME: jrpou.pou	DESIGNED - JRP	REVISED -	STATE OF ILLINOIS DEPARTMENT OF TRANSPORTATION	DRAWN - KB	REVISED -	95TH STREET DRAINAGE & UTILITY PLANS	F.A.U. RTE. 1644	SECTION 01-00181-00-PP	COUNTY WILL	TOTAL SHEETS 328	SHEET NO. 74
	DATE 10/19/2012	CHECKED - JRP	REVISED -	SCALE: 1"=20'		DRAWING NO. 3 OF 18	STA. 315+80 TO STA. 321+40		CONTRACT NO. 63647				
	PLOT DATE 10/16/2012	REVISIONS:	ILLINOIS FED. AID PROJECT										