

PLAN LEGEND:

- ADJ MANHOLES OR CATCH BASINS TO BE ADJUSTED
- REC MANHOLES TO BE RECONSTRUCTED
- * WITH NEW TYPE 1 FRAME, CLOSED LID
- ** WITH NEW TYPE 1 FRAME, OPEN LID
- R REMOVING MANHOLES OR CATCH BASINS
- STORM SEWER REMOVAL

STRUCTURES TO BE ADJUSTED/RECONSTRUCTED


STA	OFFSET	TYPE	RIM ELEV		INVERT (TOP FOR WATER)			
			EX	PROP	N	S	E	W
332+92.4	38.1	LT WATER	660.27	660.09	EX 663.98	EX 663.98	EX 659.98	
333+17.2	50.5	LT SAN	660.13	600.10	EX 642.57	EX 642.57	EX 642.57	EX 642.72

DRAINAGE PIPE TABLE

PIPE NO.	STR. NO. FROM	STR. NO. TO	DESCRIPTION	IN DIA.	FT LEN	SLOPE	CU YD TBF
136	37	38	SS, CL. A, TY 2	12	57.0	0.33%	7.5
137	38	39	SS, CL. A, TY 2	12	10.0	0.40%	1.5
138	39	42	SS, CL. A, TY 2	12	96.0	0.68%	16.6
139	40	41	SS, CL. A, TY 2	12	57.0	0.33%	7.5
140	41	42	SS, CL. A, TY 2	12	10.0	0.40%	1.5
141	42	45	SS, CL. A, TY 2	12	96.0	1.31%	16.6
142	43	44	SS, CL. A, TY 2	12	57.0	0.33%	7.5
143	44	45	SS, CL. A, TY 2	12	10.0	0.40%	1.5
144	45	48	SS, CL. A, TY 2	15	246.0	1.19%	63.7

DRAINAGE STRUCTURE TABLE

STR. NO.	STA	OFFSET	MH	TC=2' TA=4' CB	INL	OTHER	FRAME AND GRATE	RIM ELEV.		
								N	S	E
37	335+05.0	28.0	RT		TA		T-24	655.78		658.86
38	335+05.0	32.0	LT		TA		T-24	655.49	655.69	658.86
39	335+15.0	42.5	LT	4			T-1-CL	655.35	655.45	660.33
40	336+05.0	28.0	RT		TA		T-24	655.03		658.04
41	336+05.0	32.0	LT		TA		T-24	654.74	654.84	658.04
42	336+15.0	42.5	LT	4			T-1-CL	654.70	654.70	658.45
43	337+05.0	28.0	RT		TA		T-24	653.67		657.75
44	337+05.0	32.0	LT		TA		T-24	653.38	653.48	657.75
45	337+15.0	42.5	LT	4			T-1-CL	653.34	653.14	658.16

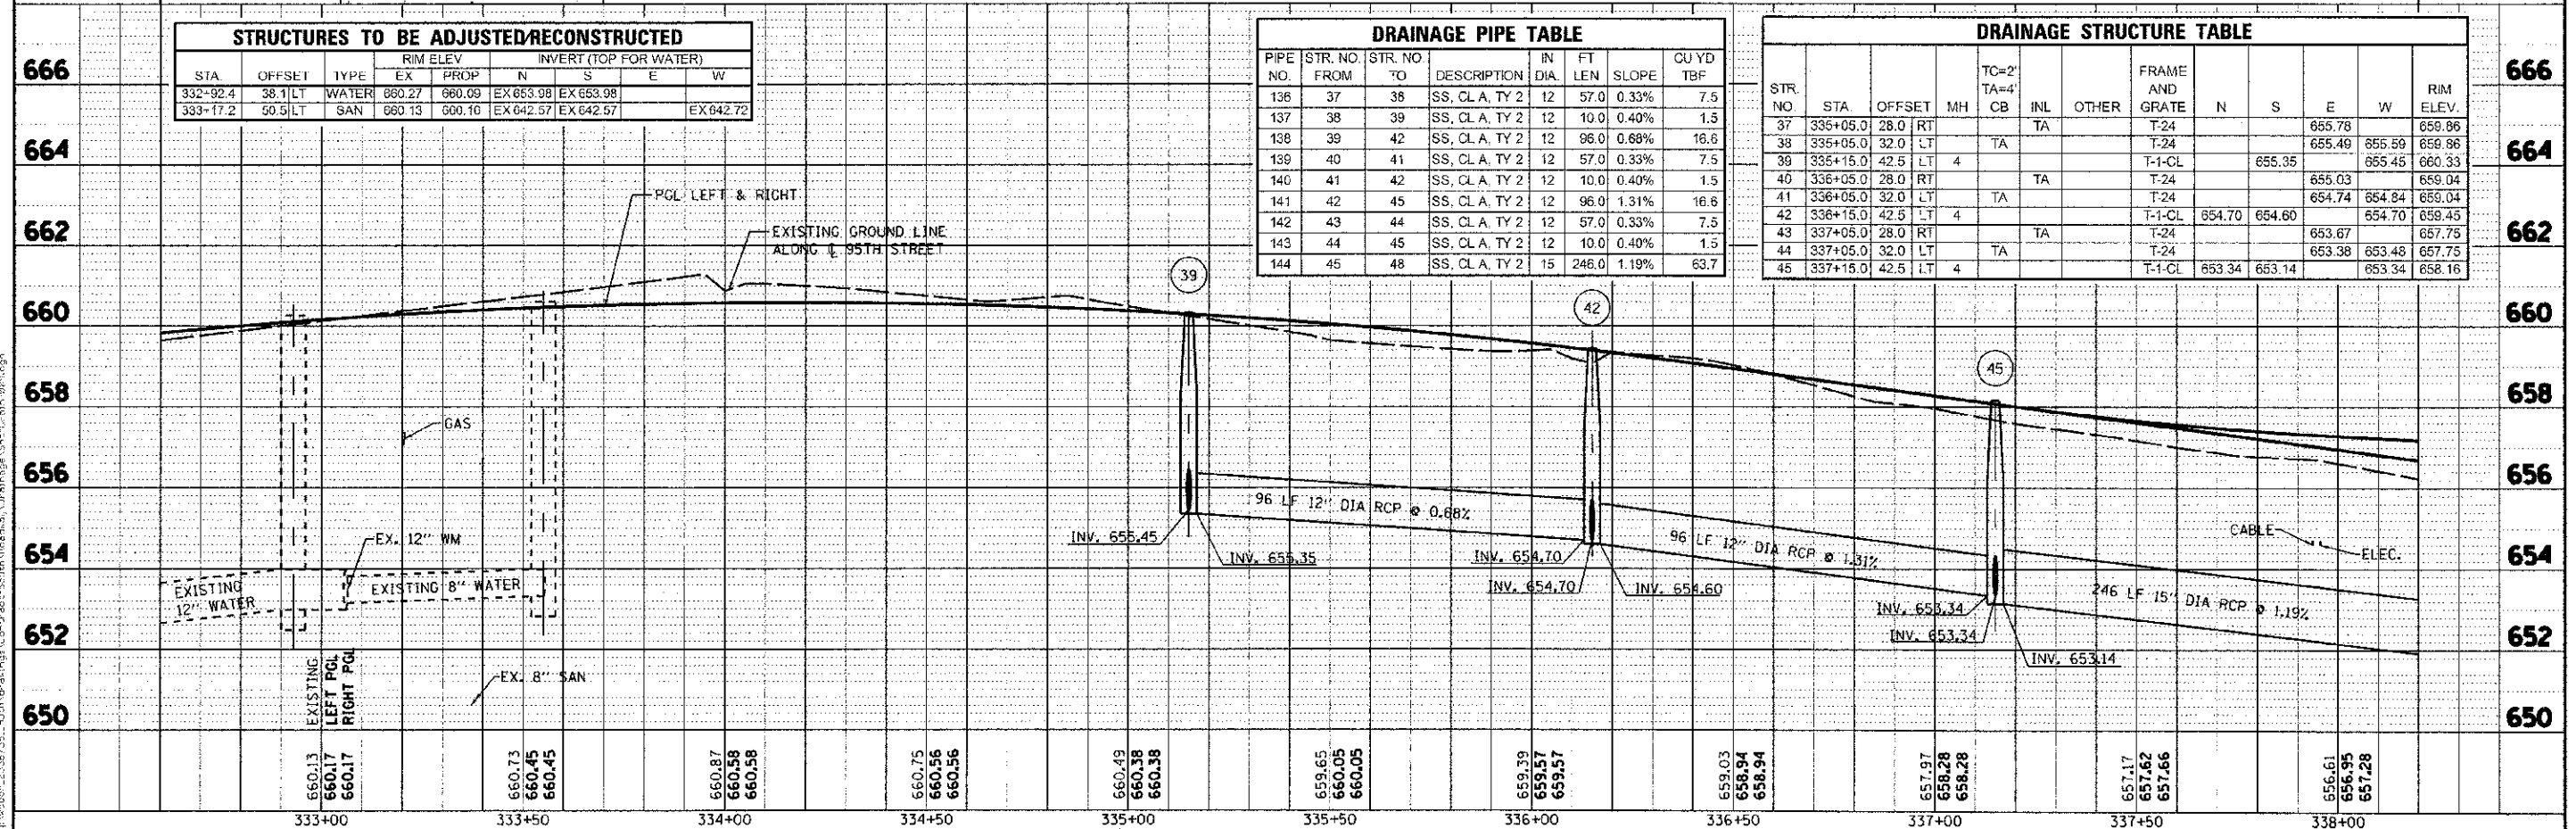

URS	100 S. WACKER DR. SUITE 500 CHICAGO, IL 60606 TEL (312) 939-4000 FAX (312) 939-4998	DESIGNED - JRP	REVISED -	STATE OF ILLINOIS DEPARTMENT OF TRANSPORTATION	95TH STREET DRAINAGE & UTILITY PLANS	F.A.U. RTE. 1644	SECTION 01-00181-00-FF	COUNTY WILL	TOTAL SHEETS 328	SHEET NO. 77
		DRAWN - KB	REVISED -							
PLOT SCALE = 28,0000 / 7 IN.		CHECKED - JRP	REVISED -	CONTRACT NO. 63647						
PLOT DATE = 10/16/2012		DATE = 10/19/2012	REVISED -							