


PLAN	DATE
REVISED	
DATE	
NO.	
BY	
CHECKED	
DATE	
BY	
CHECKED	
DATE	
BY	
CHECKED	
DATE	
BY	
CHECKED	
DATE	


PROJECT	NO.
DATE	
BY	
CHECKED	
DATE	
BY	
CHECKED	
DATE	
BY	
CHECKED	
DATE	

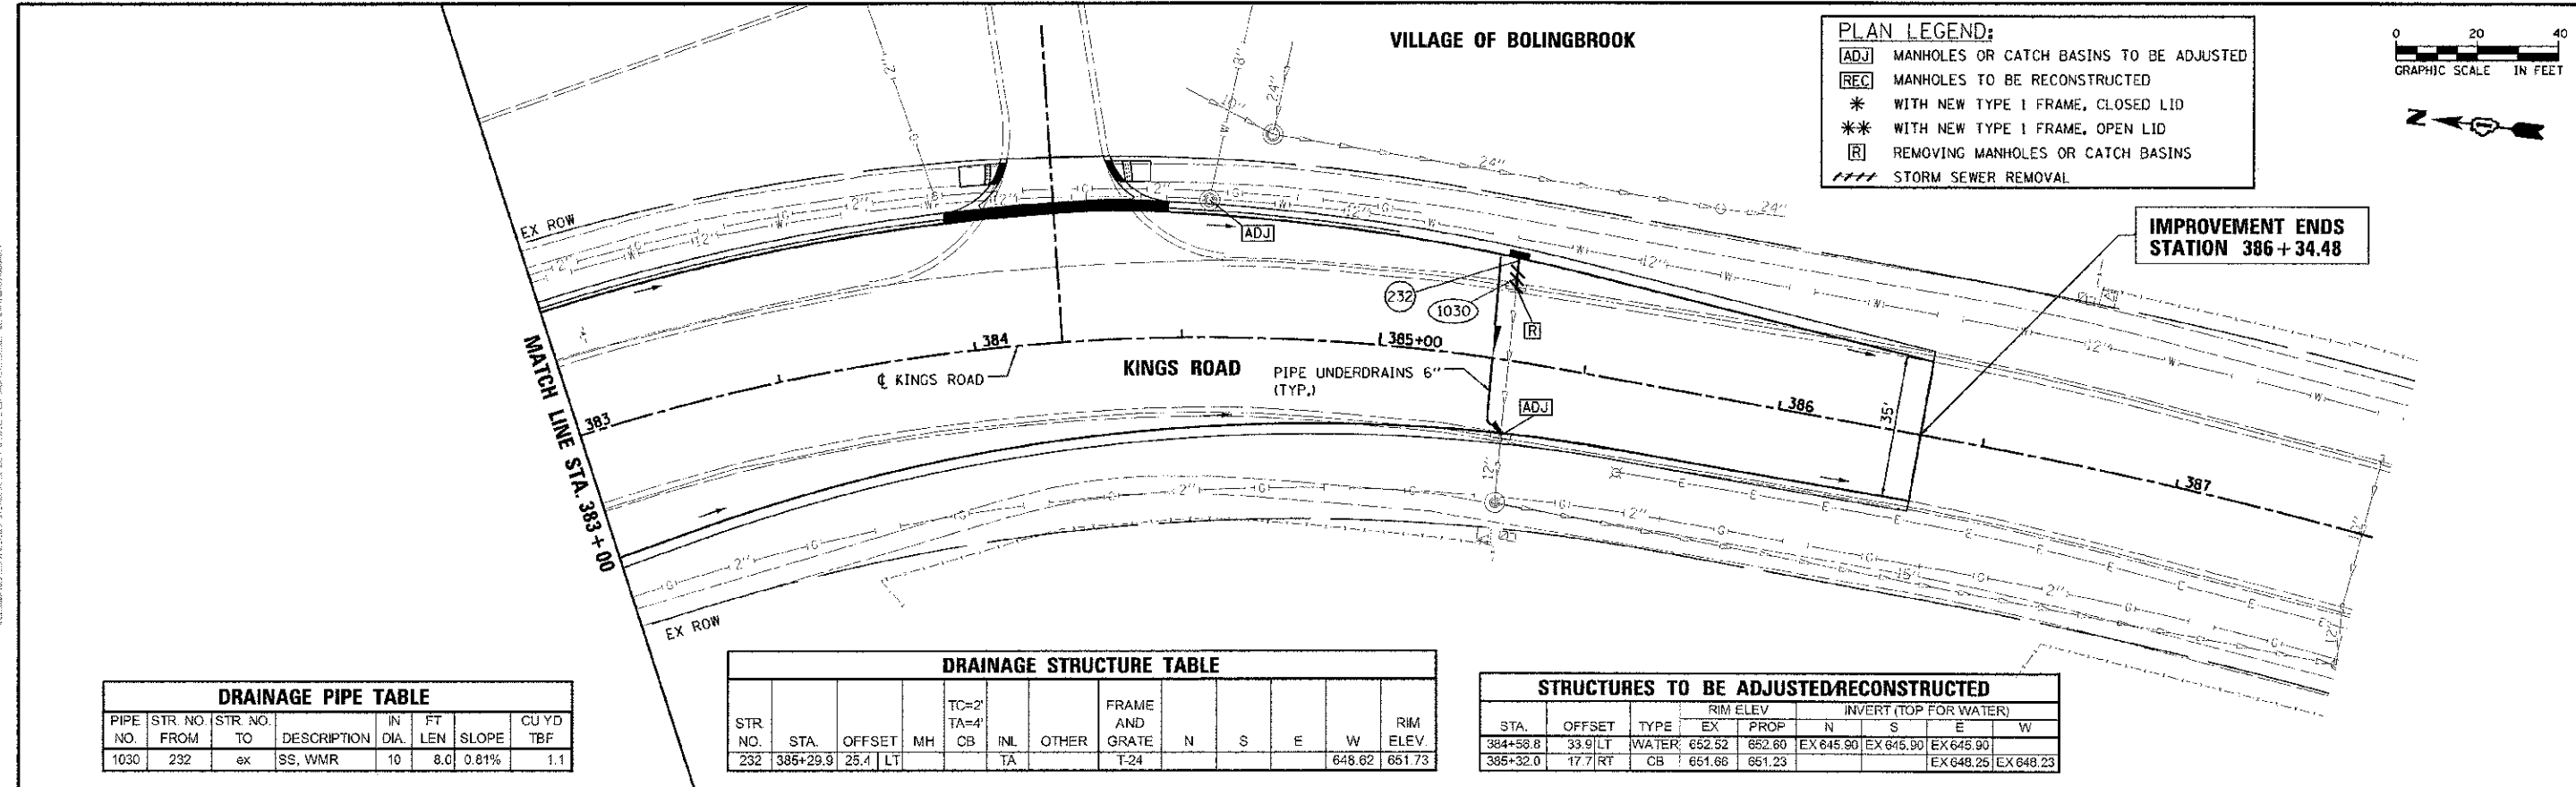

PIPE NO.	STR. NO. FROM	STR. NO. TO	DESCRIPTION	IN DIA.	FT LEN	SLOPE	CU YD TBF
1030	232	ex	SS, WMR	10	8.0	0.81%	1.1

STR. NO.	STA.	OFFSET	MH	TC=2' TA=4'	INL	OTHER	FRAME AND GRATE	N	S	E	W	RIM ELEV.
232	385+29.9	25.4	LT		TA		T-24					648.62 651.73

STA.	OFFSET	TYPE	RIM ELEV.		INVERT (TOP FOR WATER)				
			EX	PROP	N	S	E	W	
384+58.8	33.9	LT	WATER	652.52	652.60	EX 645.90	EX 645.90	EX 645.90	
385+32.0	17.7	RT	CB	651.66	651.23			EX 648.25	EX 648.23

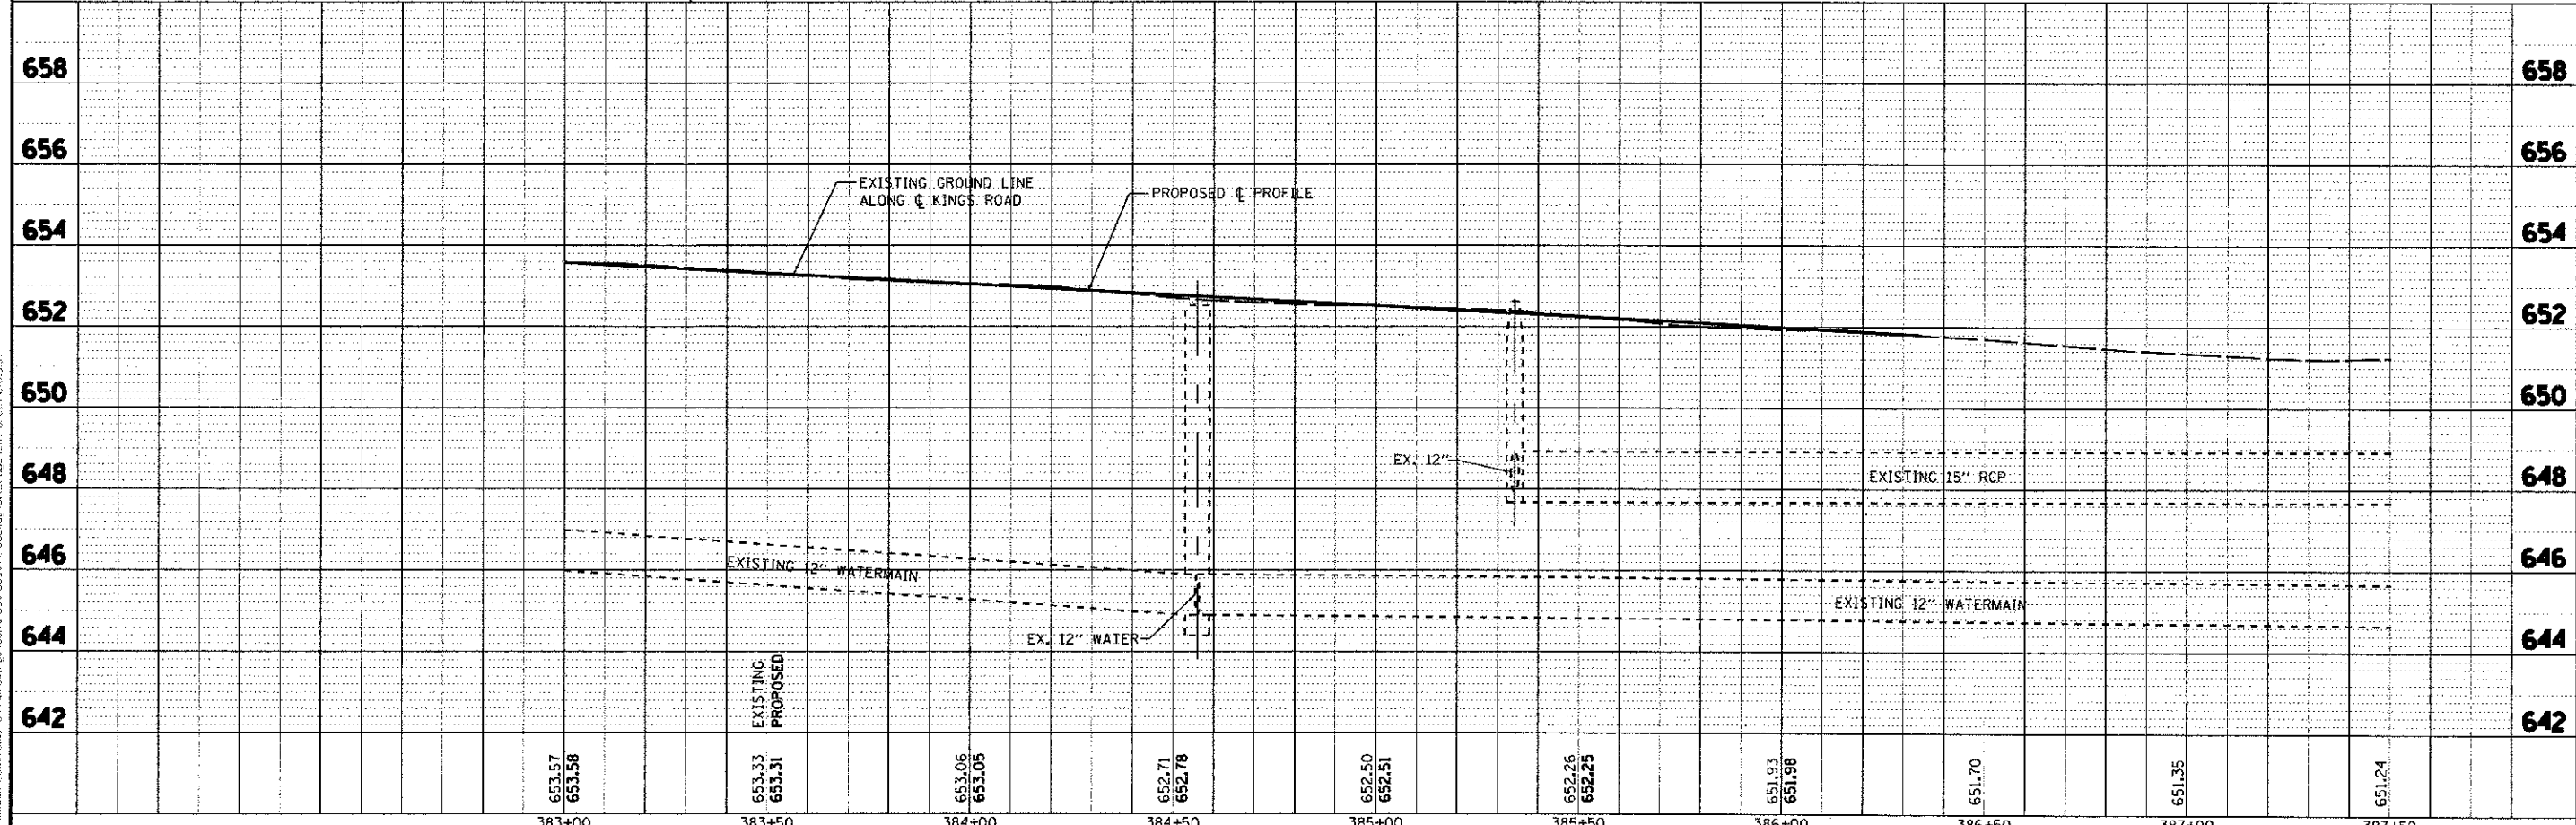

653.57 653.58	653.33 653.31	653.06 653.05	652.71 652.78	652.50 652.51	652.26 652.25	651.93 651.98	651.70	651.35	651.24
383+00	383+50	384+00	384+50	385+00	385+50	386+00	386+50	387+00	387+50

URS
 100 S. WACKER DR.
 SUITE 500
 CHICAGO, IL 60606
 TEL (312) 419-4000
 FAX (312) 939-4998

DESIGNED - JRP
 DRAWN - KB
 CHECKED - JRP
 DATE - 10/19/2012

REVISED -
 REVISED -
 REVISED -
 REVISED -

**STATE OF ILLINOIS
 DEPARTMENT OF TRANSPORTATION**

**KINGS ROAD
 DRAINAGE & UTILITY PLANS**

SCALE: 1"=20'
 DRAWING NO. 15 OF 18
 STA. 383+00 TO STA. 386+35

F.A.U. RTE. 1644
 SECTION 01-00181-00-FP
 COUNTY WILL
 TOTAL SHEETS 328
 SHEET NO. 86
 CONTRACT NO. 63647
 ILLINOIS FED. AID PROJECT