


VILLAGE OF BOLINGBROOK

IMPROVEMENT BEGINS  
STATION 55 + 83.71

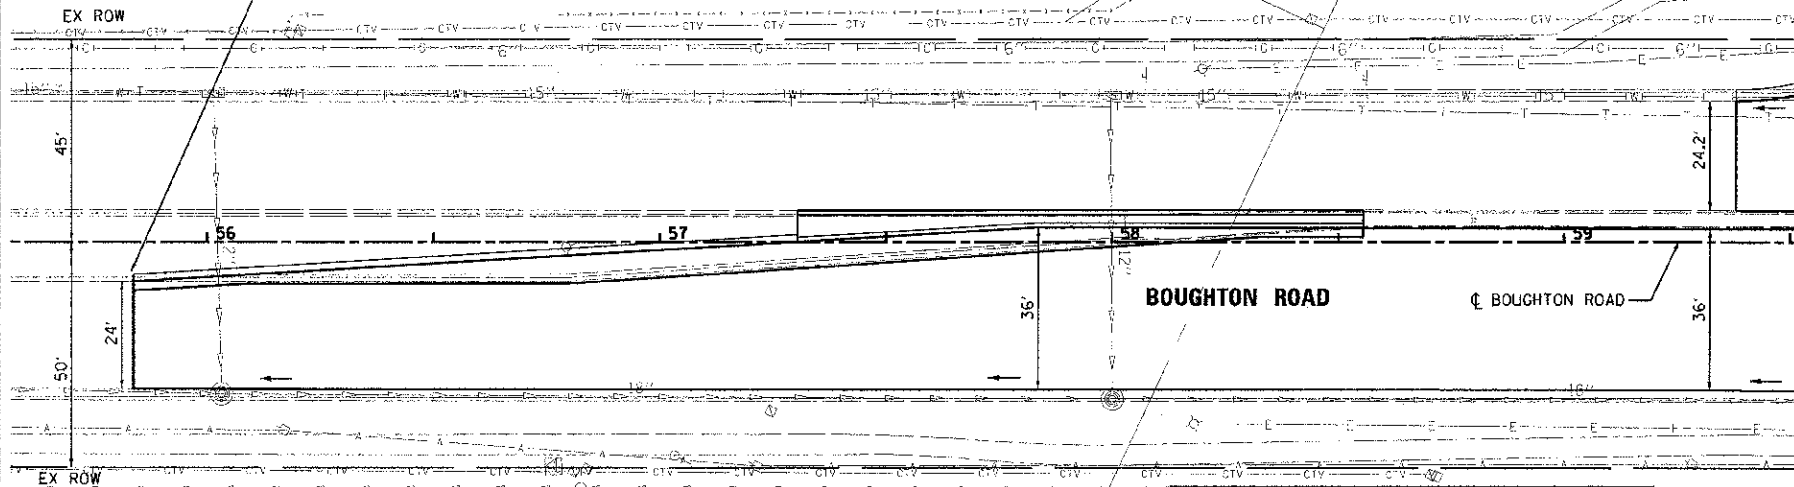


SEE DRAWING NO. 14 OF 18 FOR  
CONTINUATION ALONG 95TH STREET

DRAINAGE STRUCTURE TABLE

STR. NO.	STA.	OFFSET	MH	TC=2' TA=4'	CB	INL.	OTHER	FRAME AND GRATE	N	S	E	W	RIM ELEV.
322	61+19.2	45.0	LT					T-24					650.76 653.99

**PLAN LEGEND:**  
 [ADJ] MANHOLES OR CATCH BASINS TO BE ADJUSTED  
 [REC] MANHOLES TO BE RECONSTRUCTED  
 \* WITH NEW TYPE 1 FRAME, CLOSED LID  
 \*\* WITH NEW TYPE 1 FRAME, OPEN LID  
 [R] REMOVING MANHOLES OR CATCH BASINS  
 [---] STORM SEWER REMOVAL

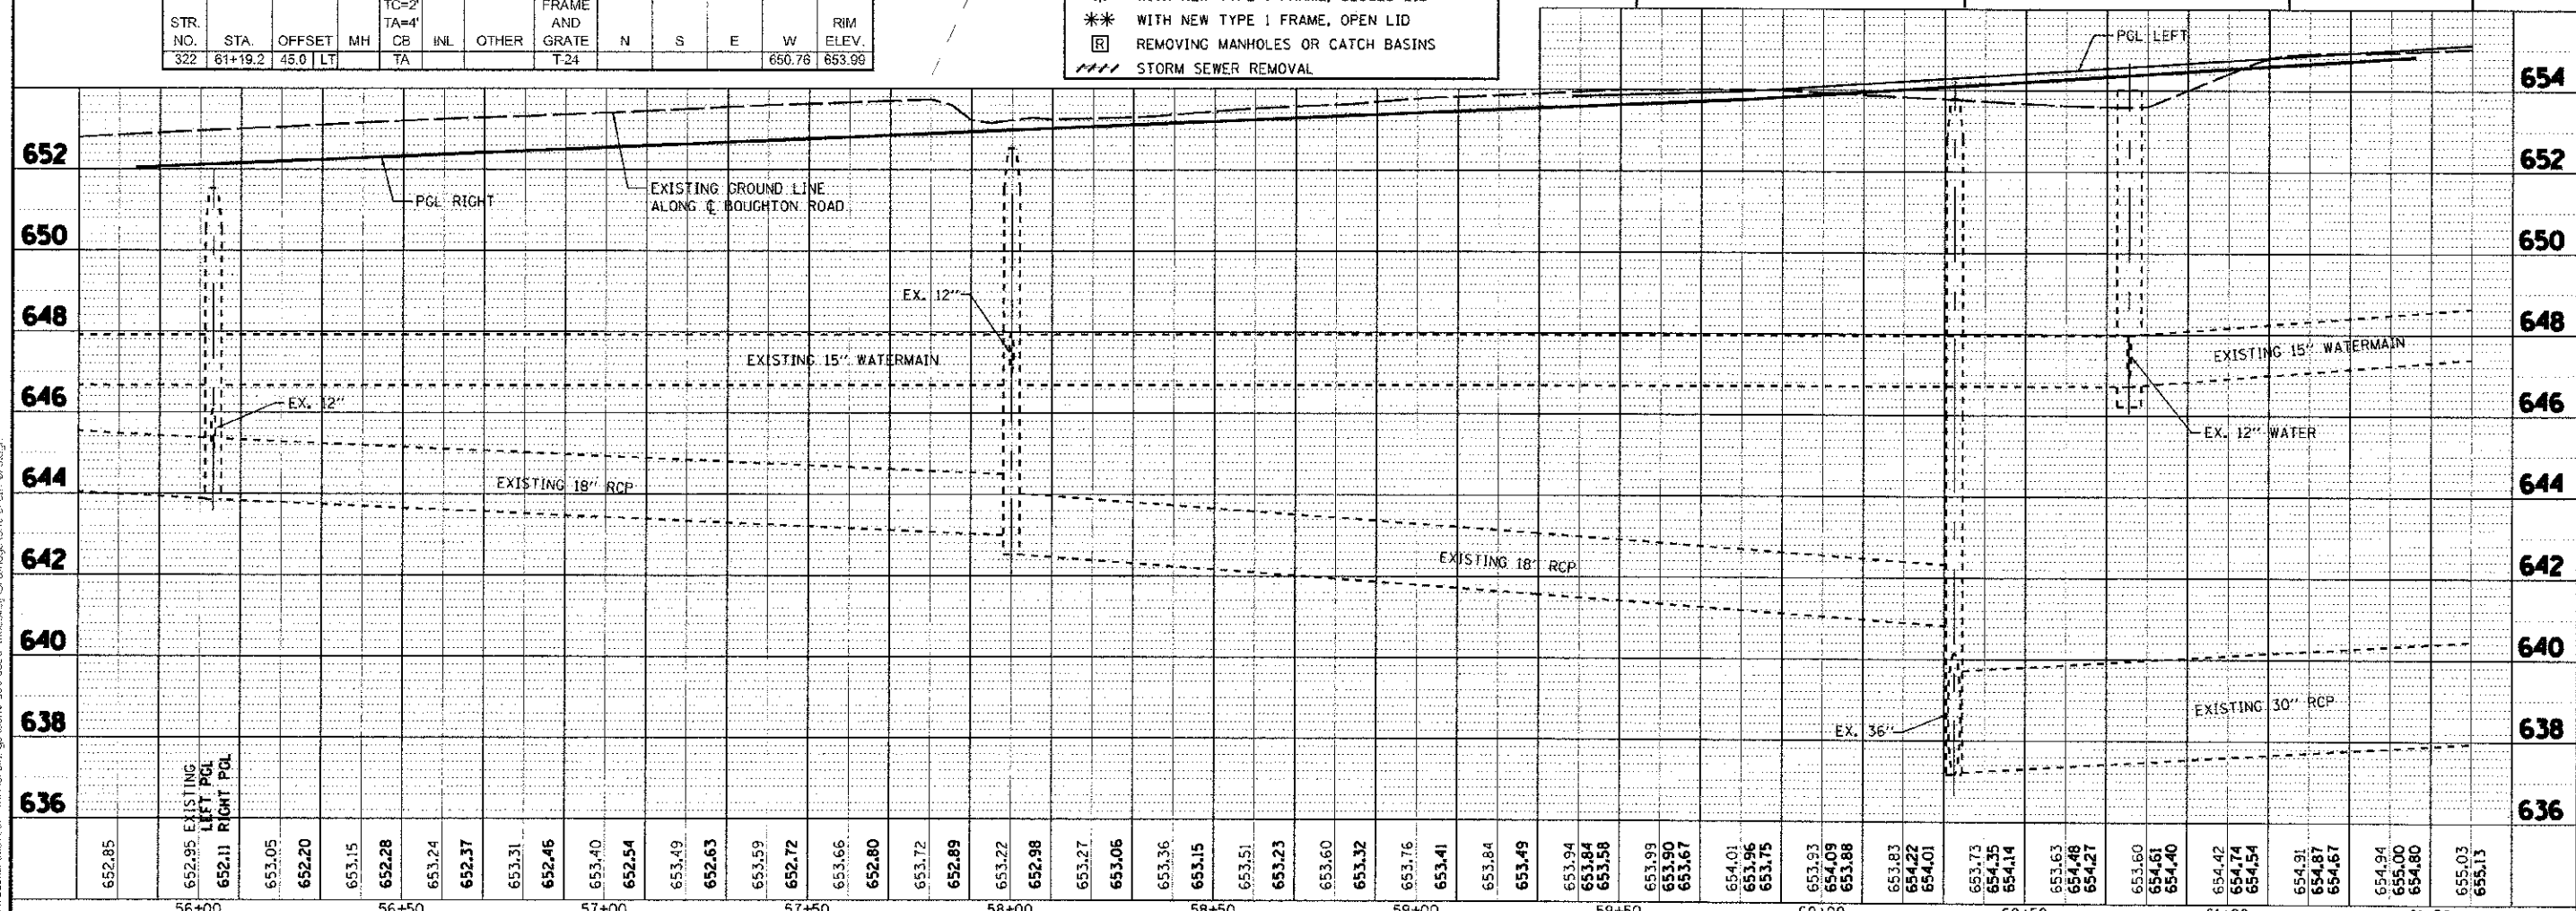

652.85	652.95	653.05	652.20	653.15	652.28	653.24	652.37	653.31	652.46	653.40	652.54	653.49	652.63	653.59	652.72	653.66	652.80	653.72	652.89	653.22	652.98	653.27	653.06	653.36	653.15	653.51	653.23	653.60	653.32	653.76	653.41	653.84	653.49	653.94	653.84	653.58	653.99	653.90	653.67	654.01	653.96	653.75	653.93	654.09	653.88	653.83	654.22	654.01	653.73	654.35	654.14	653.63	654.48	654.27	653.60	654.61	654.40	654.42	654.74	654.54	654.91	654.87	654.67	654.94	655.00	654.80	655.03	655.13
56+00		56+50		57+00		57+50		58+00		58+50		59+00		59+50		60+00		60+50		61+00		61+50																																														

**URS**  
 100 S. WACKER DR.  
 SUITE 500  
 CHICAGO, IL 60606  
 TEL (312) 939-4000  
 FAX (312) 939-4998

DESIGNED - JRP  
 DRAWN - KB  
 CHECKED - JRP  
 DATE - 10/19/2012

REVISED -  
 REVISED -  
 REVISED -  
 REVISED -

STATE OF ILLINOIS  
 DEPARTMENT OF TRANSPORTATION

BOUGHTON ROAD  
 DRAINAGE & UTILITY PLANS  
 SCALE: 1"=20'  
 DRAWING NO. 16 OF 18  
 STA. 55+83.71 TO STA. 61+60

F.A.U. RTE. 1644	SECTION 01-00181-00-PP	COUNTY WILL	TOTAL SHEETS 328	SHEET NO. 87
CONTRACT NO. 63647				
ILLINOIS FED. AID PROJECT				