
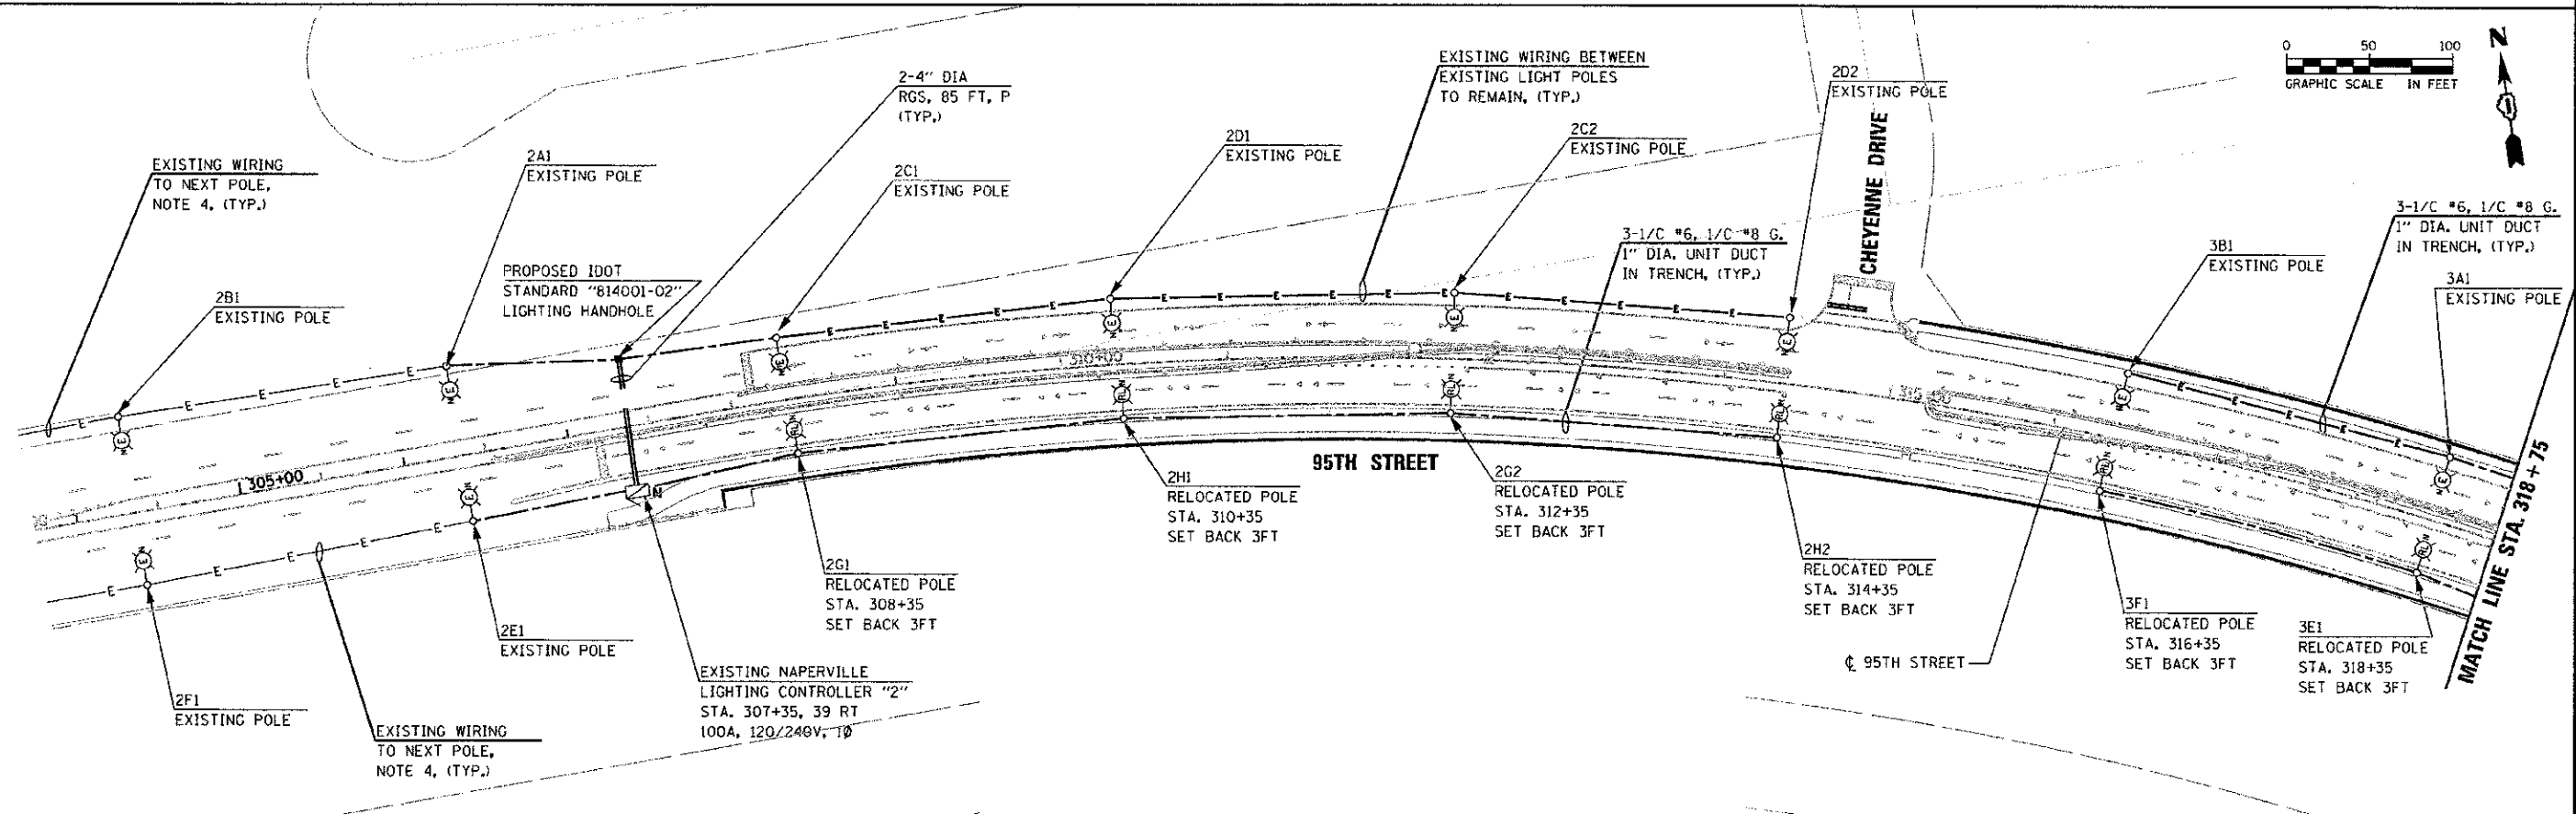


NOTES:

1. ALL LIGHT POLE SETBACKS SHOWN ARE MEASURED FROM THE BACK OF CURB TO THE CENTER OF THE POLE BASE.
2. THE FINAL LOCATIONS OF ALL ELECTRIC SERVICE TRANSFORMERS AND PEDESTALS FEEDING THE LIGHTING CABINETS SHALL BE DETERMINED BY THE UTILITY. ADJUSTMENTS TO THE LENGTH OF THE SERVICE CABLE AND CONDUIT SHALL BE MADE ACCORDINGLY. ALSO SEE GENERAL NOTE 13 ON LIGHTING SHEET 1 FOR ADDITIONAL REQUIREMENTS.
3. ALL MATERIALS, EQUIPMENT, AND LABOR NEEDED TO INSTALL AND CONNECT THE SERVICE FROM THE UTILITY TRANSFORMER OR PEDESTAL TO THE LIGHTING CONTROLLER CABINET SHALL BE PART OF PAY ITEM NO. 80400100 - ELECTRIC SERVICE INSTALLATION. WORK SHALL INCLUDE THE CABLE, CONDUIT AND TRENCHING FOR THE CONDUIT SHOWN ON THE PLANS. ALL CONNECTIONS, SPLICING, AND WIRING TO THE NEW LIGHTING CONTROLLER IS ALSO INCLUDED UNDER THE SAME PAY ITEM. THE SERVICE CABLE AND CONDUIT SIZE SHALL BE AS SHOWN ON THE PLANS. ALSO SEE GENERAL NOTE 13 ON LIGHTING SHEET 1 OF 30 FOR ADDITIONAL SERVICE WIRING AND CONNECTION REQUIREMENTS.
4. CONTRACTOR SHALL VERIFY EXISTING WIRING AND CIRCUITS SHOWN ON THESE PLANS IN THE FIELD. CONTRACTOR SHALL MAKE ALL NECESSARY WIRING ADJUSTMENTS BASED ON FIELD VERIFICATION FINDINGS.
5. LIGHTING HANDHOLE COVER SHALL HAVE "NAPERVILLE LIGHTING" ENGRAVED ON IT.

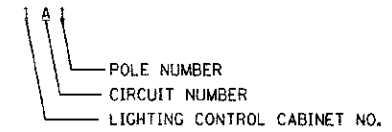

URS
100 S. WACKER DR.
SUITE 500
CHICAGO, IL 60606
TEL (312) 939-4000
FAX (312) 939-4990

USER NAME: james.purd
DESIGNED: MAE
DRAWN: MAE
CHECKED: DAD
DATE: 2/1/2012

REVISIONS:
REVISED: -
REVISED: -
REVISED: -
REVISED: -

STATE OF ILLINOIS
DEPARTMENT OF TRANSPORTATION

95TH STREET
PROPOSED LIGHTING PLAN (SHEET 1 OF 4)

SCALE: 1"=50'
DRAWING NO. 3 OF 30
STA. 291+70.56 TO STA. 318+75

F.A.J. RTE. 1644	SECTION 01-00181-00-PP	COUNTY WILL	TOTAL SHEETS 328	SHEET NO. 131
ILLINOIS FED. AID PROJECT			CONTRACT NO. 63647	