 
 
 
 
 

 
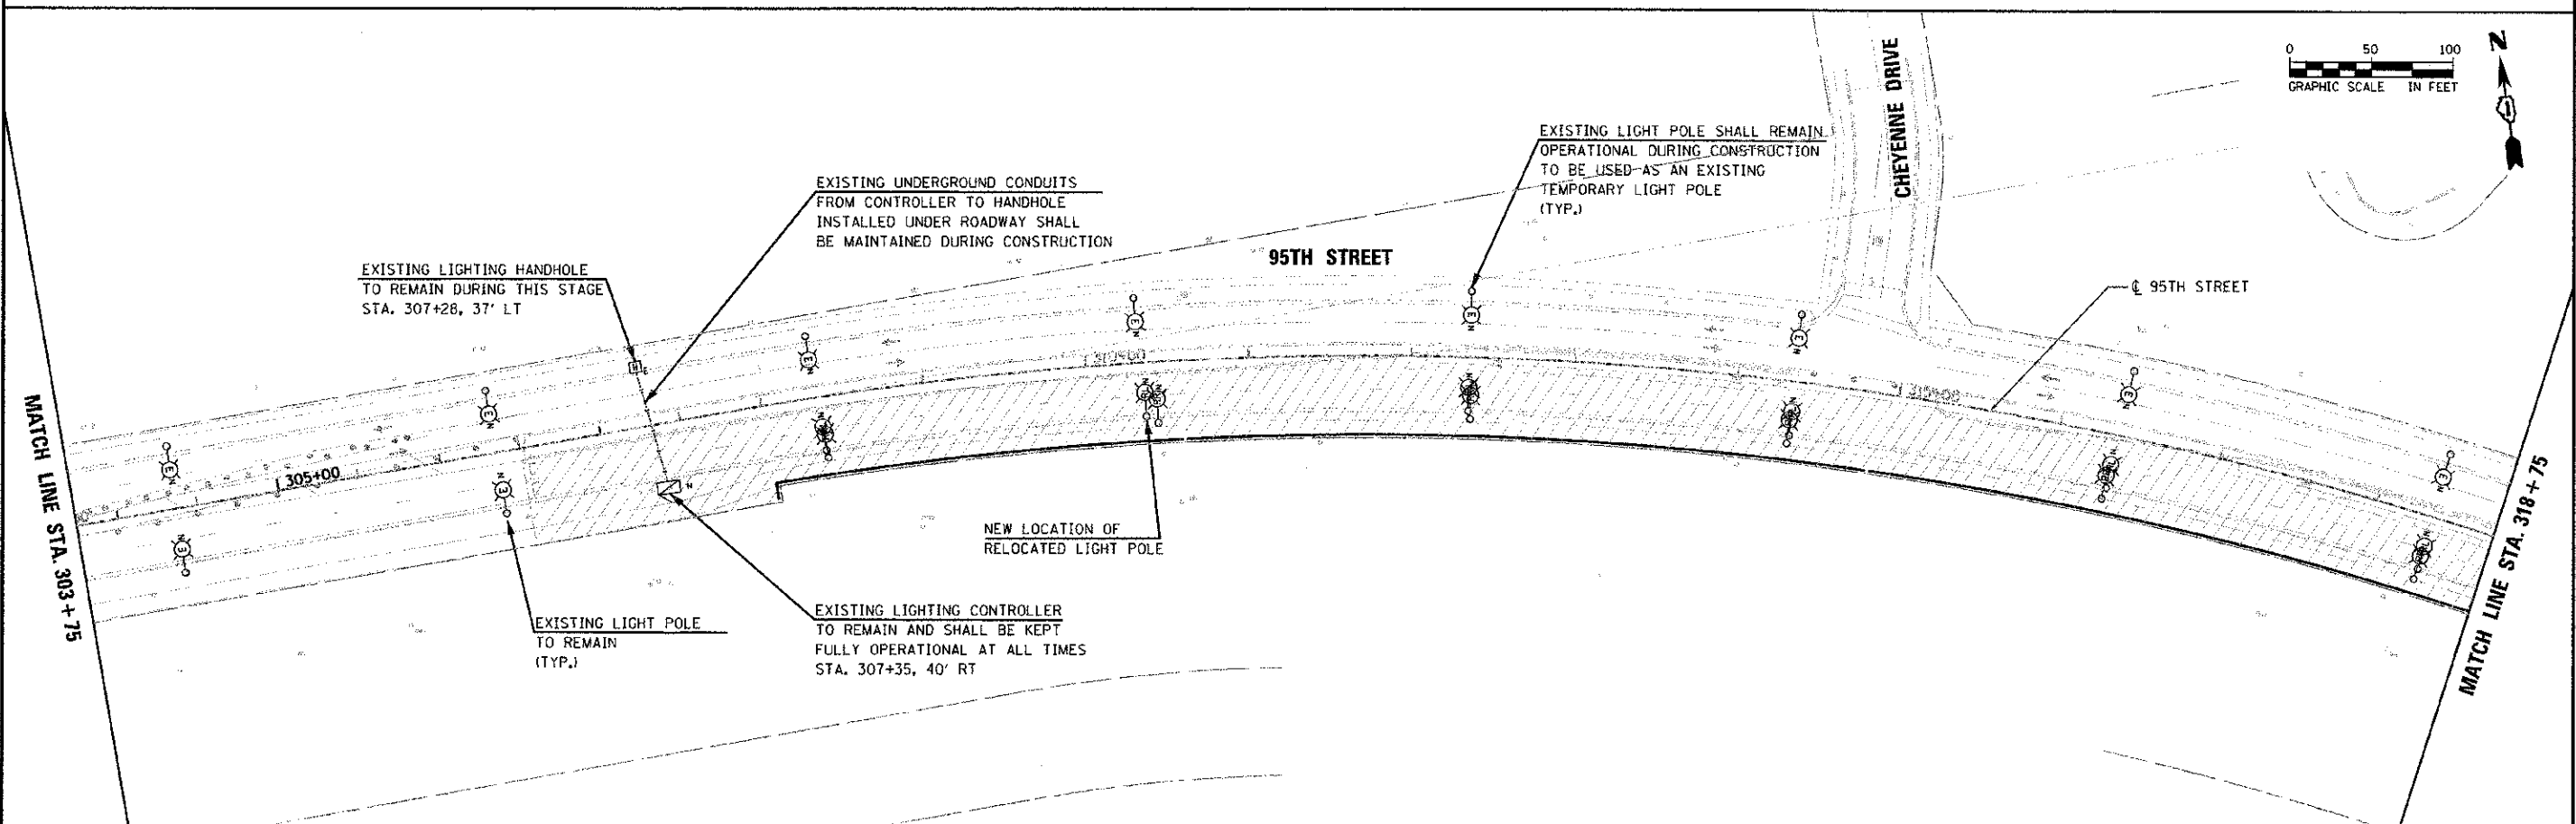


LEGEND

-  EXISTING LIGHTING UNIT TO REMAIN
40' M.H., 12' M.A., 310W, 120V HPS LUMINAIRE
CITY OF NAPERVILLE
-  EXISTING LIGHTING UNIT TO BE REMOVED AND RELOCATED
40' M.H., 12' M.A., 310W, 120V HPS LUMINAIRE
CITY OF NAPERVILLE
-  EXISTING LIGHTING UNIT TO REMAIN DURING CONSTRUCTION
AND BE USED AS TEMPORARY LIGHT POLE
40' M.H., 12' M.A., 310W, 120V HPS LUMINAIRE
CITY OF NAPERVILLE
-  NEW LOCATION OF EXISTING LIGHT POLES
THAT ARE TO BE REMOVED AND RELOCATED
CITY OF NAPERVILLE
-  EXISTING LIGHTING CONTROLLER CABINET,
SINGLE DOOR, CONSOLE TYPE, 100A, 120/240V, 1Ø
CITY OF NAPERVILLE MAINTAINED
-  EXISTING LIGHTING HANDHOLE TO REMAIN DURING THIS STAGE

NOTES:

1. THE CONTRACTOR SHALL MAINTAIN THE EXISTING LIGHTING EQUIPMENT FULLY OPERATIONAL ON THE TRAFFIC SIDE OF THE ROADWAY. THE CONTRACTOR SHALL REWIRE EXISTING LIGHTING CIRCUITS, AS NECESSARY, TO KEEP THE LIGHT POLES OPERATIONAL DURING CONSTRUCTION. THE CONTRACTOR SHALL PROVIDE ANY EQUIPMENT, MATERIALS, AND LABOR NECESSARY TO ACCOMPLISH THIS GOAL INCLUDING TEMPORARY WIRING (UNDERGROUND OR AERIAL) OF POLES, LUMINAIRES AND LIGHTING CONTROLLERS.
2. ALL LIGHTING RELATED EQUIPMENT, MATERIALS AND LABOR FURNISHED AND INSTALLED BY THE CONTRACTOR DURING CONSTRUCTION TO MAINTAIN THE OPERATION OF THE EXISTING LIGHTING SYSTEM SHALL BE PAID FOR UNDER PAY ITEM 'MAINTAIN EXISTING LIGHTING SYSTEM'. THIS PAYMENT SHALL INCLUDE ALL MATERIALS AND EQUIPMENT NOT SPECIFICALLY SHOWN ON THE PLANS, BUT ARE NECESSARY TO MAINTAIN THE OPERATION OF THE LIGHTING SYSTEM DURING CONSTRUCTION.
3. FURNISH AND INSTALL AERIAL CABLES AND WOOD POLES TO SUPPORT CABLES IF PERMANENT UNDERGROUND WIRING CANNOT BE INSTALLED OR EXISTING WIRING CANNOT BE MAINTAINED DURING CONSTRUCTION. NUMBER AND LOCATIONS OF TEMPORARY WOOD POLES AND AERIAL WIRING IS SHOWN AS AN EXAMPLE ONLY, AND ARE NOT LIMITED TO WHAT IS SHOWN ON THESE PLANS. PAYMENT FOR THIS WORK SHALL BE AS DESCRIBED IN NOTE 2 ABOVE.



FILE NAME: g:\es206_203387201_0916\p\engineering\contract\95th\95th\Lighting\Lighting_2012.dwg

URS	100 S. WACKER DR. SUITE 500 CHICAGO, IL 60606 TEL (312) 939-1000 FAX (312) 939-4998	USER NAME: j.mason.p.usk	DESIGNED - MAE	REVISED -	STATE OF ILLINOIS DEPARTMENT OF TRANSPORTATION	95TH STREET TEMPORARY LIGHTING PLAN - STAGE 1 (SHEET 1 OF 4)	F.A.I.L. RTE. 1644	SECTION 01-00181-00-FP	COUNTY WILL	TOTAL SHEETS 328	SHEET NO. 139	CONTRACT NO. 63647
	PLT SCALE: 1" = 50'	PLT DATE: 10/16/2012	CHECKED - DAD	REVISED -		SCALE: 1" = 50'	DRAWING NO. 11 OF 30	STA. 291+70.56 TO STA. 318+75	ILLINOIS FED. AID PROJECT			