



TYPICAL SPLICE DETAIL
N.T.S.

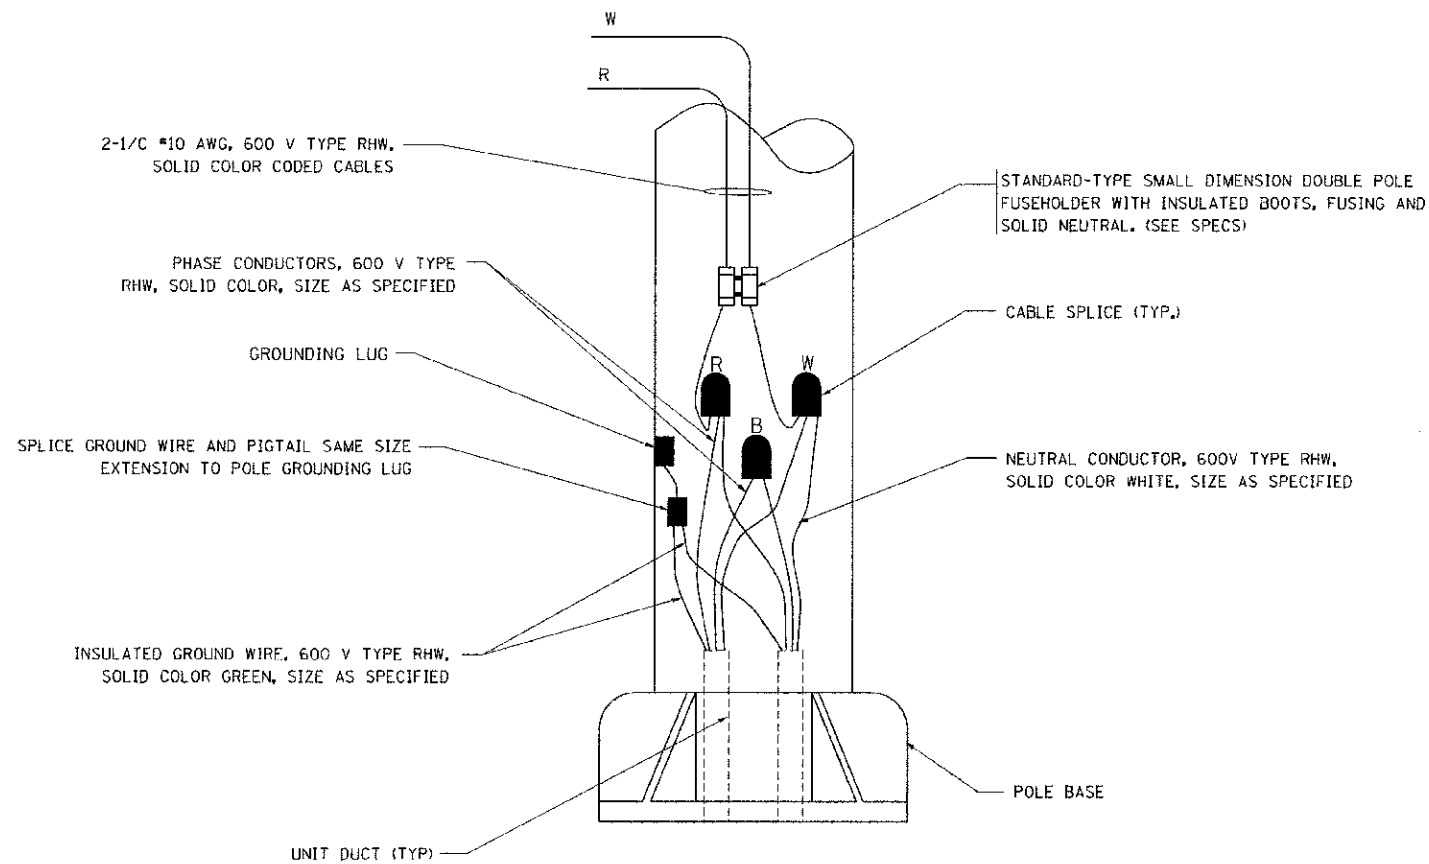

POLE WIRING DETAIL
N.T.S.

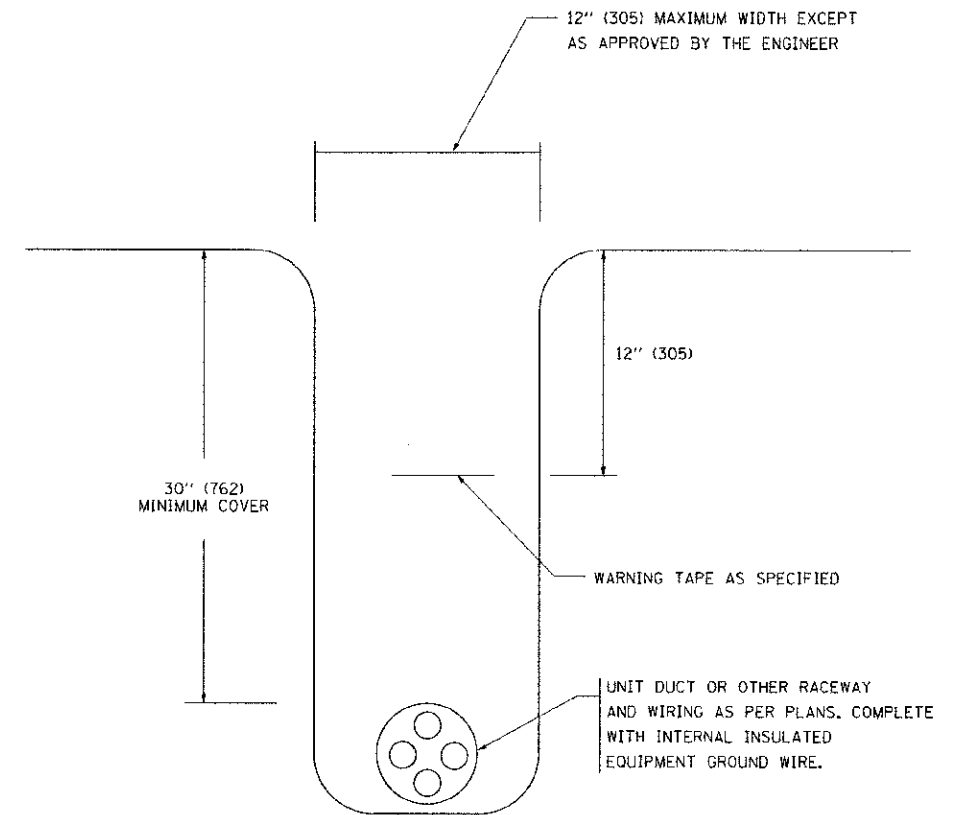

TYPICAL WIRING IN TRENCH DETAIL
N.T.S.

THIS STANDARD APPLIES TO WORK
WITHIN VILLAGE OF BOLINGBROOK

FILE NAME = W:\des\std\22x34\be702.dgn	USER NAME = gogitrobt	DESIGNED -	REVISED - 08-08-03	STATE OF ILLINOIS DEPARTMENT OF TRANSPORTATION	MISC. ELECTRICAL DETAILS SHEET A		F.A.D. RTE.	SECTION	COUNTY	TOTAL SHEETS	SHEET NO.
	PLOT SCALE = 50,000 / IN.	CHECKED -	REVISED -				1644	01-00181-00-PP	WILL	328	158
	PLOT DATE = 1/4/2008	DATE -	REVISED -				BE-702		CONTRACT NO. 63647		
								FED. ROAD DIST. NO. 1 (ILLINOIS) FED. AID PROJECT			
					SCALE: NONE	SHEET NO. 1 OF 1 SHEETS	STA.	TO STA.			