

PIPE TABLE STA. 50+50.00 TO STA. 56+50.00


PIPE NO.	FROM STR.	TO STR.	MATERIAL	TYPE	LENGTH	DIA.	UPPER INV.	LOWER INV.	SLOPE %	TRENCH D.F.
P101	S101	S102	SPECIAL	1	35	12	684.34	682.58	7.74	8
P102	EX	S102	SPECIAL	1	2	12	682.62	682.58	2.00	2
P103	S102	S103	RCCP	1	35	12	682.48	682.15	2.42	8
P104	S103	EX	RCCP	1	8	12	682.16	681.18	12.12	2
P105	S106	S104	SPECIAL	1	37	12	684.66	683.51	3.64	9
P106	EX	EX	SPECIAL	1	44	12	679.63	678.16	3.10	11
P107	S108	S107	RCP	1	12	12	704.71	704.66	0.40	2

STRUCTURE TABLE STA. 50+50.00 TO STA. 56+50.00

STRUCTURE NO.	STRUCTURE TYPE	DIA.	STATION	OFFSET	RIM ELEV.	INV. NORTH	INV. SOUTH	INV. EAST	INV. WEST
S101	INLET TY A	2	53+07.33	24.0' LT	697.30		694.34		
S102	MH TY A, F&G 1 OL	4	53+46.34	23.4' RT	694.85	692.58	692.48		692.88
S103	INLET TY A	2	53+41.66	24.2' RT	695.15		692.15		
S104	CB TY A, F&G 1 OL	4	54+52.60	16.8' RT	688.33	683.81		683.41	683.41
S105	MH TY A, F&G 1 OL	5	54+61.12	18.9' RT	688.26	683.36	682.89		682.92
S106	INLET TY A	2	54+68.37	20.7' LT	688.02		684.83		
S107	CB TY A, F&G 1 OL	4	51+52.46	24.3' LT	707.40		704.66		704.66
S108	INLET TY A, F&G 1 OL	2	51+63.27	18.3' LT	706.59				

DATE: _____
 BY: _____
 CHECKED: _____
 DESIGNED: _____
 DRAWN: _____
 PLOT SCALE: 1"=20'
 PLOT DATE: 10/23/2012

DATE: _____
 BY: _____
 CHECKED: _____
 DESIGNED: _____
 DRAWN: _____
 PLOT SCALE: 1"=20'
 PLOT DATE: 10/23/2012

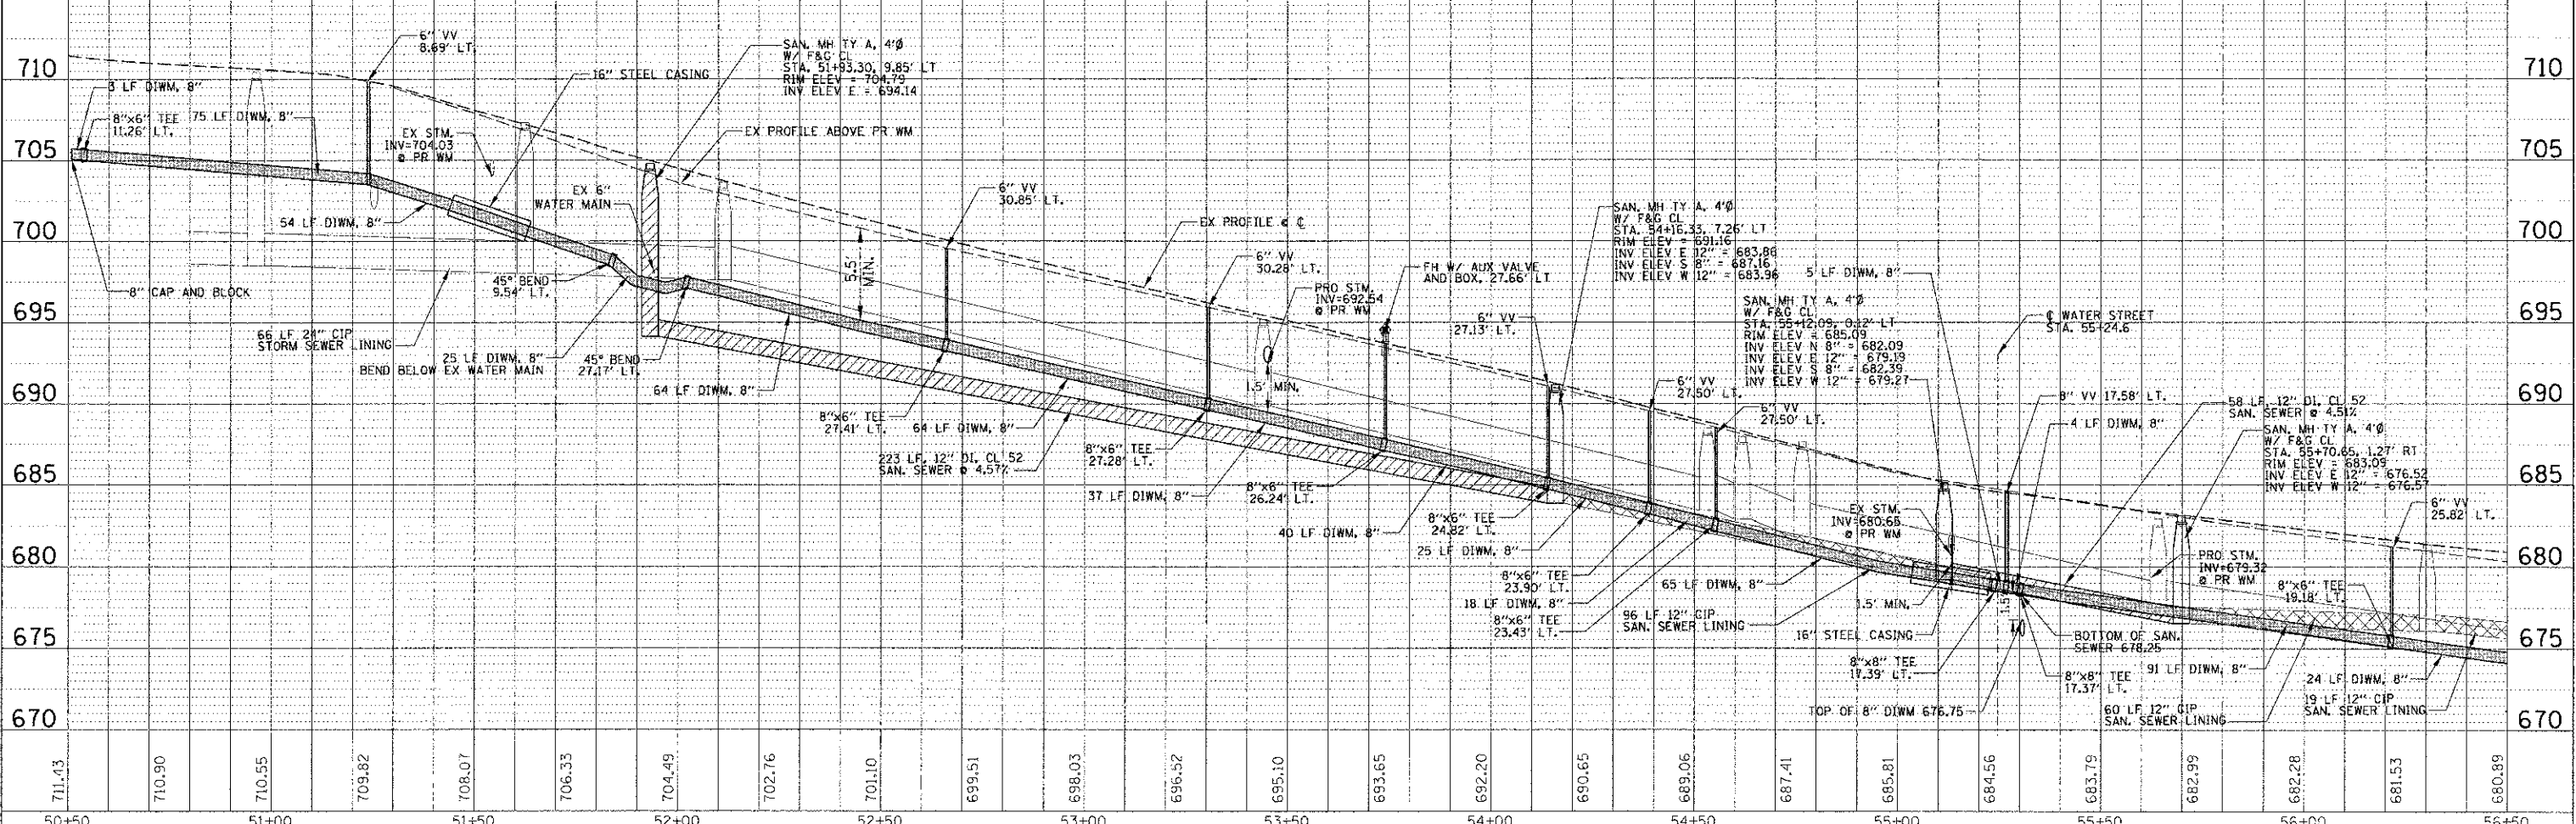

<p>CHRISTOPHER B. BURKE ENGINEERING, LTD. 9575 W. Higgins Road, Suite 600 Rosemont, Illinois 60018 (847) 823-0500</p>	USER NAME: cbspc11 DESIGNED: CJB DRAWN: MAX CHECKED: LM DATE:	REVISIONS: REVISIONS: REVISIONS: REVISIONS:	STATE OF ILLINOIS DEPARTMENT OF TRANSPORTATION	UTILITY PLAN AND PROFILE WILSON STREET STA. 50+50 TO STA. 56+50	F.A.U. RTE.: 1441 SECTION: 12-00073-01-TL COUNTY: KANE TOTAL SHEETS: 88 SHEET NO.: 11 CONTRACT NO.: 63763
	SCALE: 1"=20' SHEET 11 OF 88 SHEETS STA. 50+50 TO STA. 56+50	ILLINOIS FED. AID PROJECT			