



PLAN	SURVEYED	BY	DATE
	PLOTTED		
	NOTE BOOK		
	CHECKED		
	AT WORK		
	FILE NAME		
	NO.		

PROFILE	SURVEYED	BY	DATE
	PLOTTED		
	GRADES CHECKED		
	STRUCTURE		
	NOT THIS OFFICE		
	NO.		

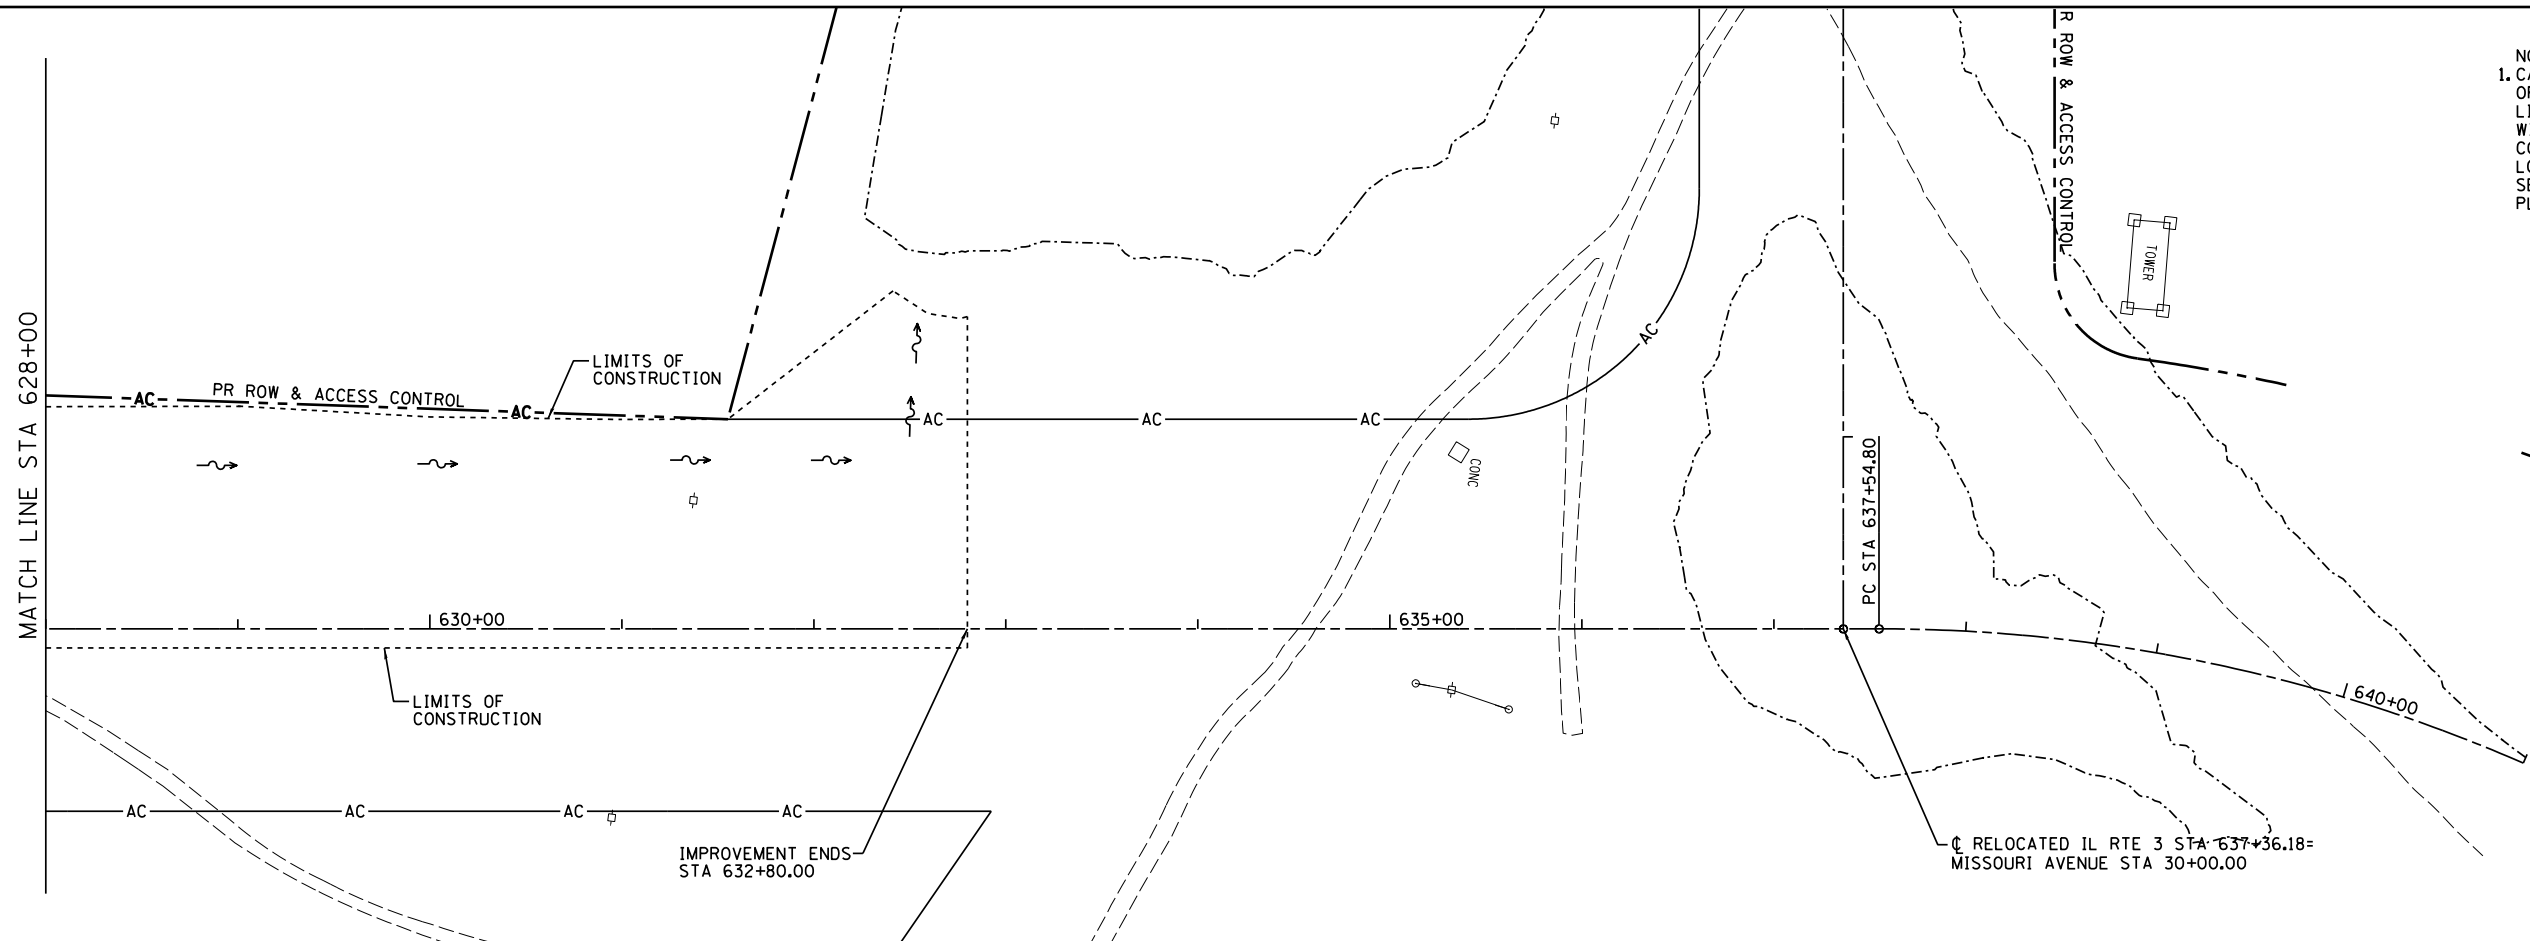

NOTES:  
 1. CAUTION, EXISTING UTILITIES, INCLUDING FIBER OPTIC, ELECTRICAL, TELEPHONE, WATER, AERIAL LINES AND OTHER FACILITIES, ARE LOCATED WITHIN THE LIMITS OF CONSTRUCTION. THE CONTRACTOR SHALL VERIFY THE UTILITY LOCATIONS PRIOR TO CONSTRUCTION. SEE SUBSURFACE UNDERGROUND ENGINEERING PLANS FOR ADDITIONAL INFORMATION.

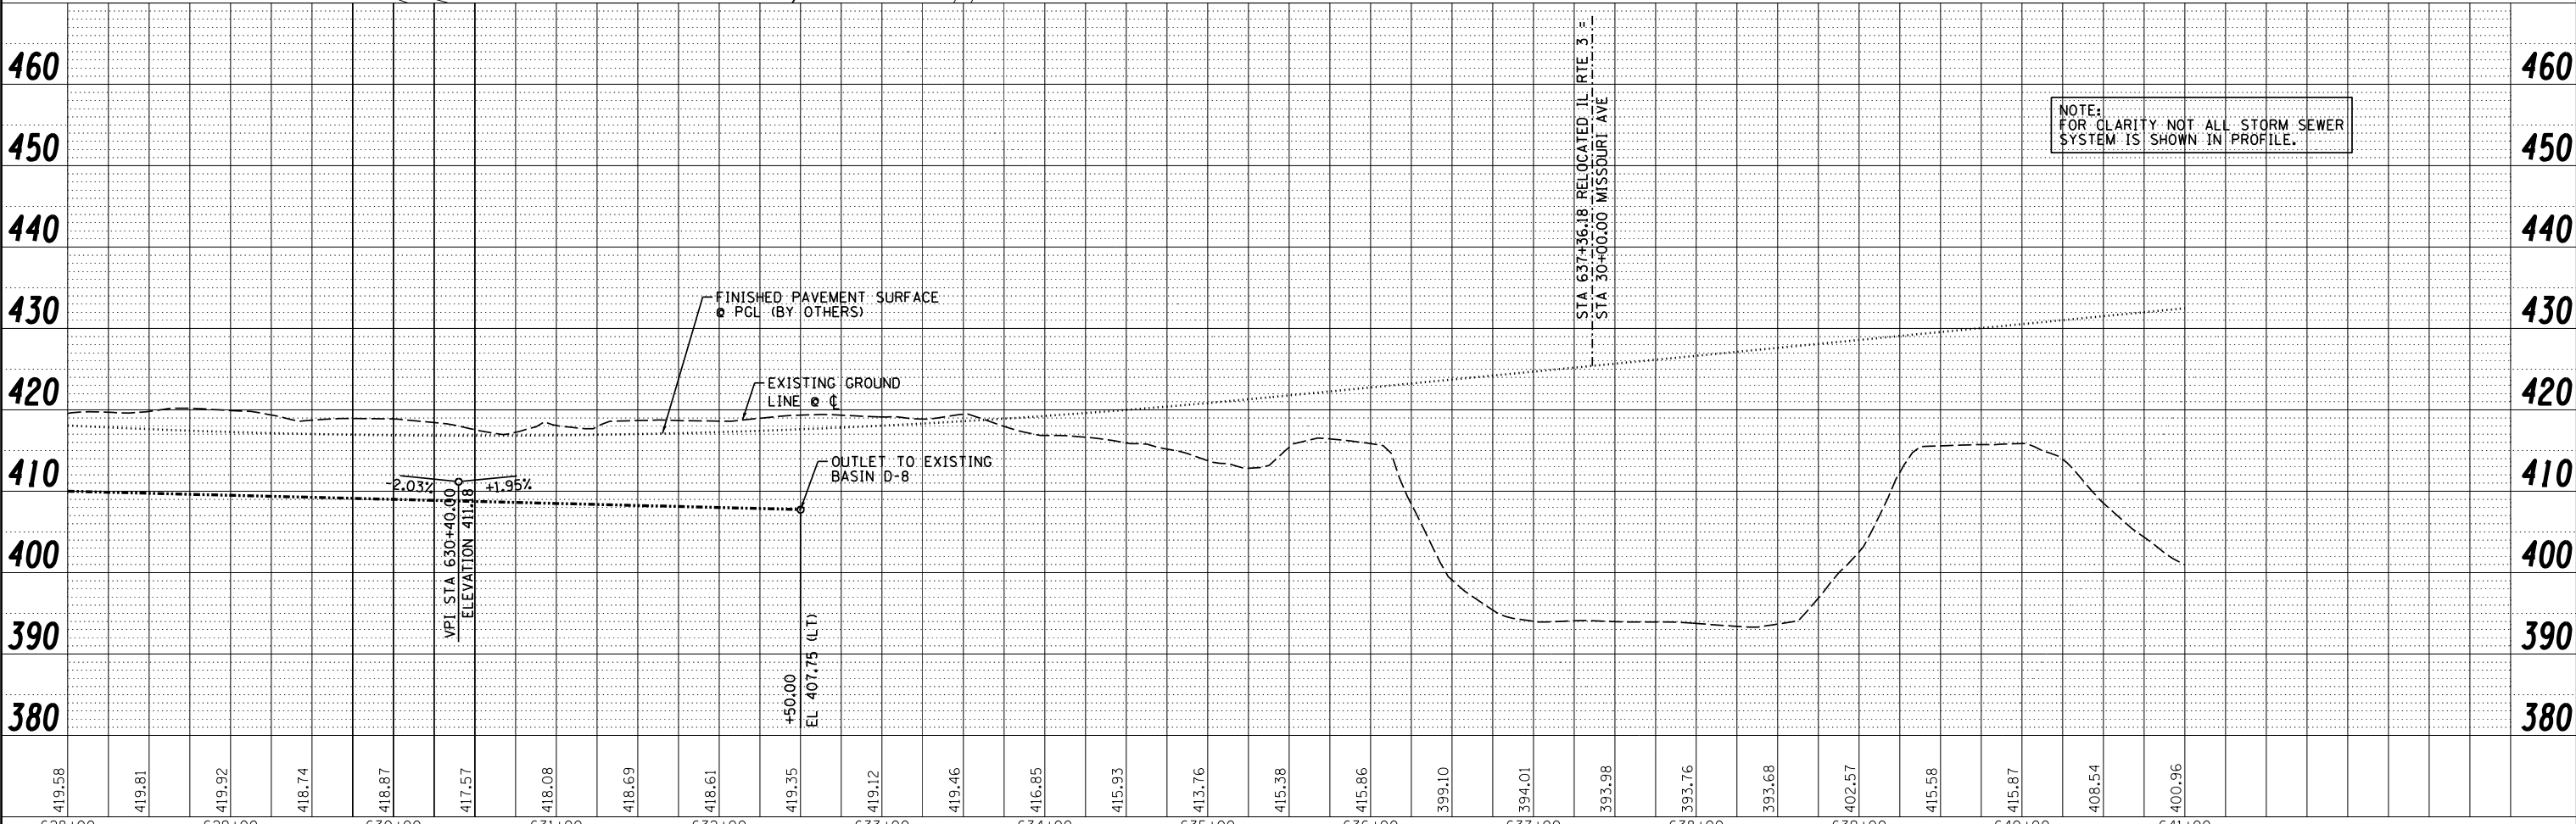

419.58	419.81	419.92	418.74	418.87	417.57	418.08	418.69	418.61	419.35	419.12	419.46	416.85	415.93	413.76	415.38	415.86	399.10	394.01	393.98	393.76	393.68	402.57	415.58	415.87	408.54	400.96	
628+00	629+00	630+00	631+00	632+00	633+00	634+00	635+00	636+00	637+00	638+00	639+00	640+00	641+00														

**Farnsworth GROUP INC.**  
 2700 McGraw Drive  
 Bloomington, Illinois 61704  
 309-663-8435, 309-663-1571 fax

USER NAME - *USER*	DESIGNED - JJJ	REVISED -
	DRAWN - JJJ	REVISED -
PLOT SCALE - *SCALE*	CHECKED - PJM	REVISED -
PLOT DATE - *DATE*	DATE - 06/26/12	REVISED -

**STATE OF ILLINOIS  
 DEPARTMENT OF TRANSPORTATION**

**DRAINAGE PLAN & PROFILE**

SCALE: 1"=50' SHEET NO. OF SHEETS STA. 628+00 TO STA. 641+00

F.A.P. RTE.	SECTION	COUNTY	TOTAL SHEETS	SHEET NO.
788	520-1-2B	ST. CLAIR	94	18
CONTRACT NO. 76F69				
ILLINOIS FED. AID PROJECT				