
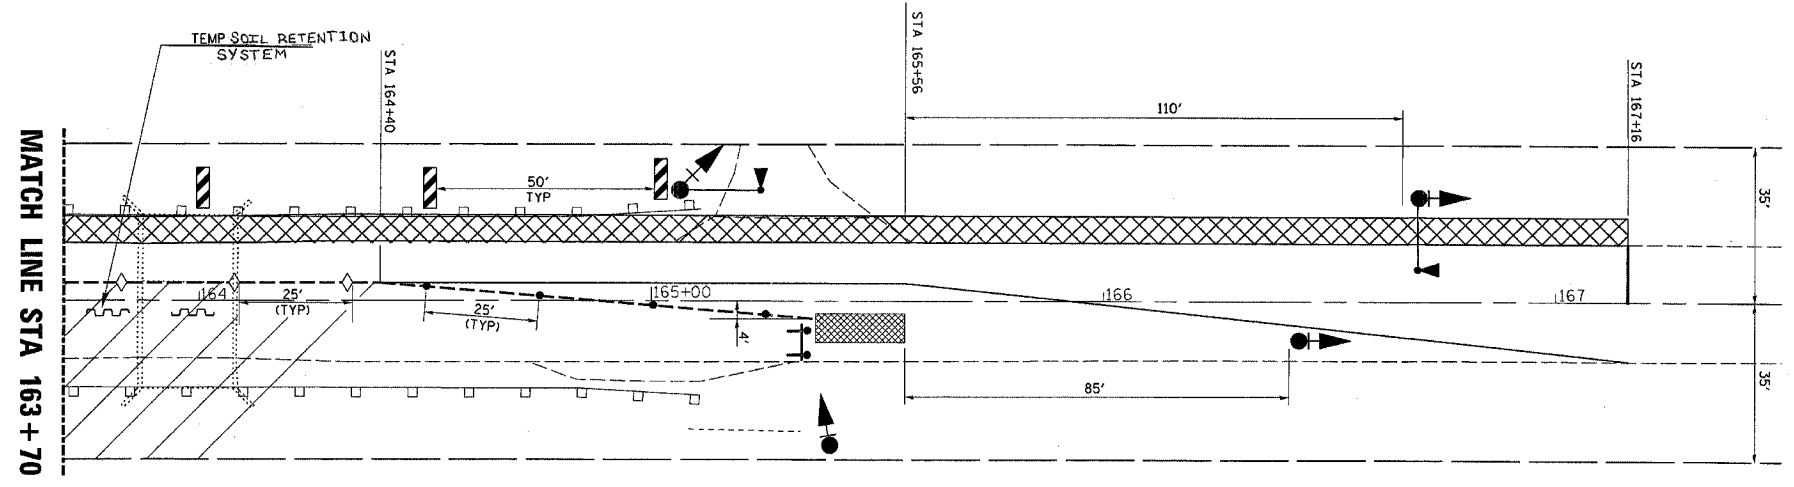


F.A.P. RTE.	SECTION	COUNTY	TOTAL SHEETS	SHEET NO.
635	(105)BR-2	KANKAKEE	25	12
STA. _____		TO STA. _____		
FED. ROAD DIST. NO. _____		ILLINOIS FED. AID PROJECT		

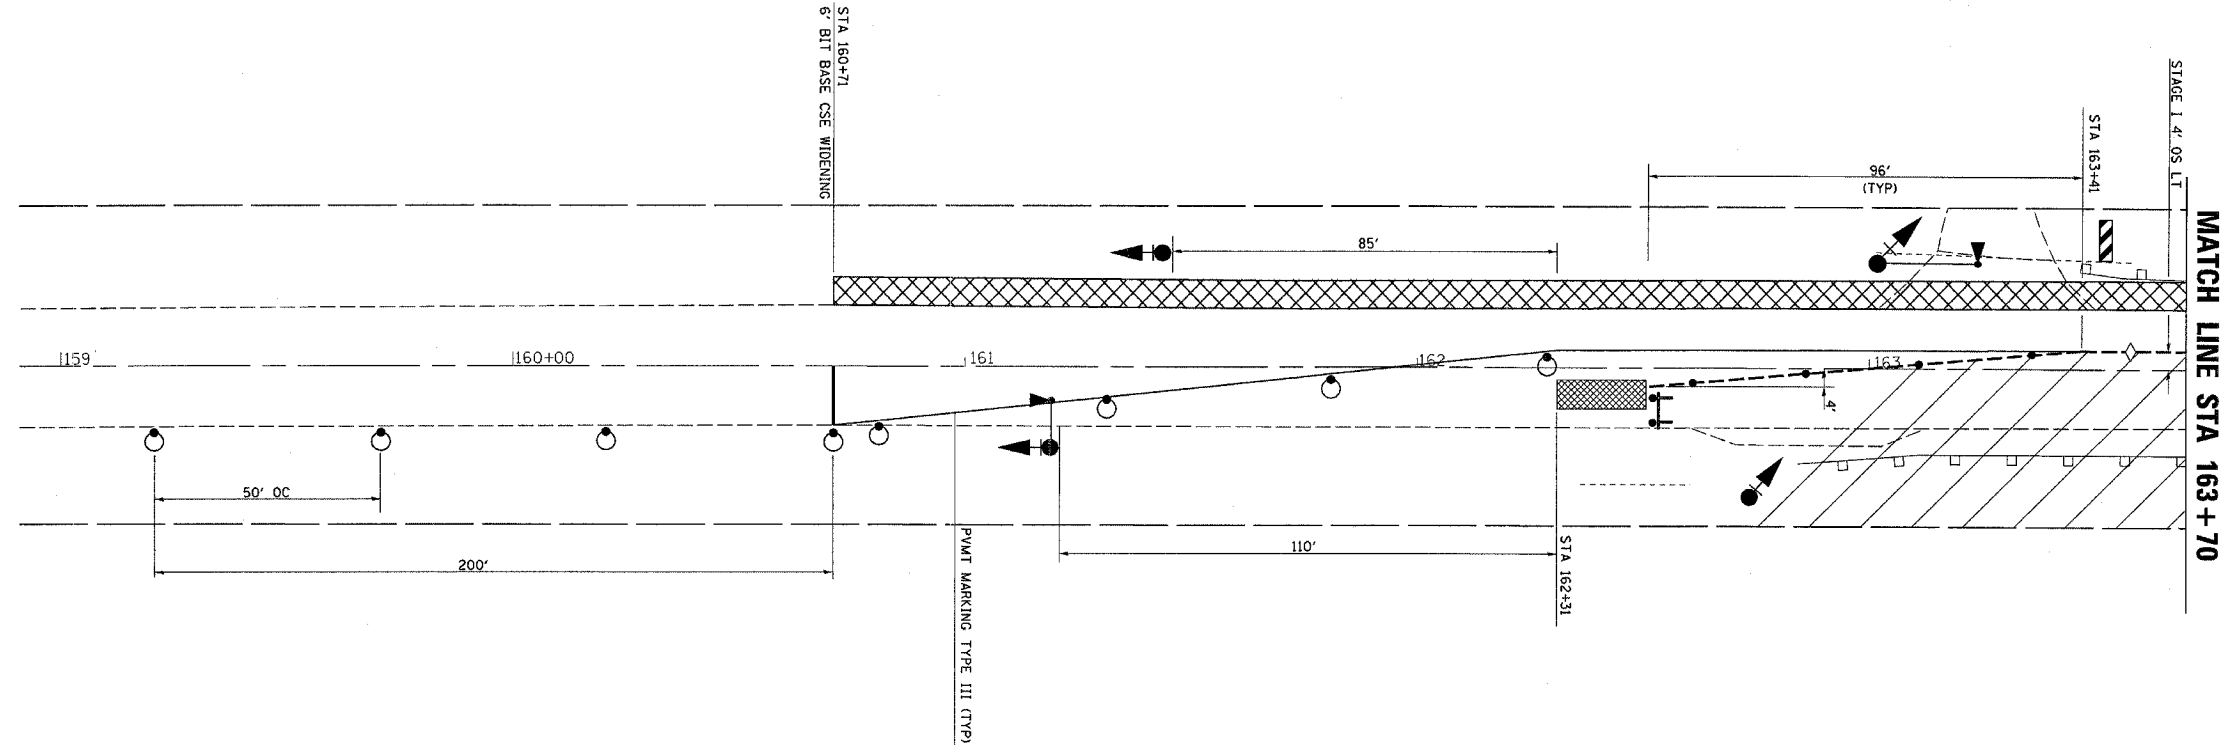

**PRE STAGE I**  
SEQUENCE OF OPERATIONS


1. PRIOR TO STAGE I, BITUMINOUS BASE COURSE WIDENING SHALL BE IN PLACE

**STAGE I**  
SEQUENCE OF OPERATIONS

1. INSTALL TEMPORARY TRAFFIC SIGNALS, ATTENUATORS, TEMPORARY CONCRETE BARRIERS, DRUMS, ALL OTHER ITEMS AS PER THESE DETAILS AND AS PER LANE CLOSURE 2L, 2W, BRIDGE REPAIR WITH BARRIER STANDARD 701321, BEGIN OPERATING UNDER STAGE I TRAFFIC CONDITIONS.
2. CONTRACTOR MUST EXCAVATE BEHIND EXISTING ABUTMENTS PRIOR TO BRIDGE DECK REMOVAL. SEE SPECIAL PROVISIONS. REMOVE EXISTING PAVEMENT, AGGREGATE SHOULDERS, GUARDRAIL & TRAFFIC BARRIER TERMINALS. EXCAVATE, AND REMOVE PORTION OF EXISTING STRUCTURE. PLACE TEMPORARY SOIL RETENTION SYSTEM.
3. CONSTRUCT NEW PORTION OF PROPOSED BOX CULVERT, BACKFILL, COMPACT, PAVEMENT, BITUMINOUS BASE COURSE, AND ROUGH GRADING OF DITCHES.

NOTES:

1. SEE STANDARD 701321 FOR SIGNAGE AND FOR OTHER DETAILS NOT SHOWN
2. STAGE I TRAFFIC SHALL OPERATE WITH THE EXISTING GUARDRAIL (LT) REMAINING IN PLACE.

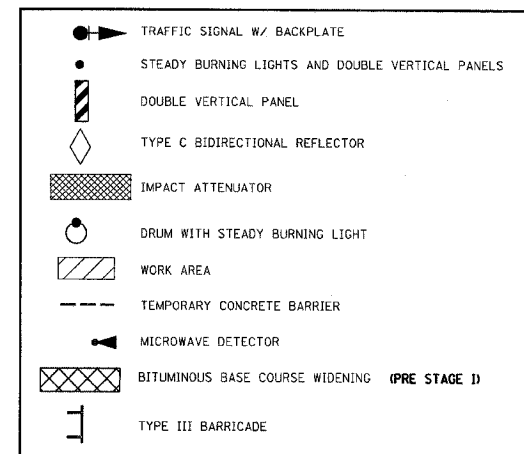

ILLINOIS DEPARTMENT OF TRANSPORTATION  
**TRAFFIC CONTROL  
PROTECTION, STAGE I**

8/31/2006 12:50:50 PM c:\p\o\ecrs\6604003.dwg/115.dwg