



F.A.P. RTE.	SECTION	COUNTY	TOTAL SHEETS	SHEET NO.
1517	03-00247-00-BR	KANE	121	28
STA. 122+50		TO STA. 125+00		
FED. ROAD DIST. NO. 1		ILLINOIS	HIGHWAY PROJECT	
CONTRACT #: 83867				

FINAL SURVEY	BY	DATE
SURVEY PLOTTED		
NOTE BOOK TEMPLATE		
AREAS CHECKED		
NO.		

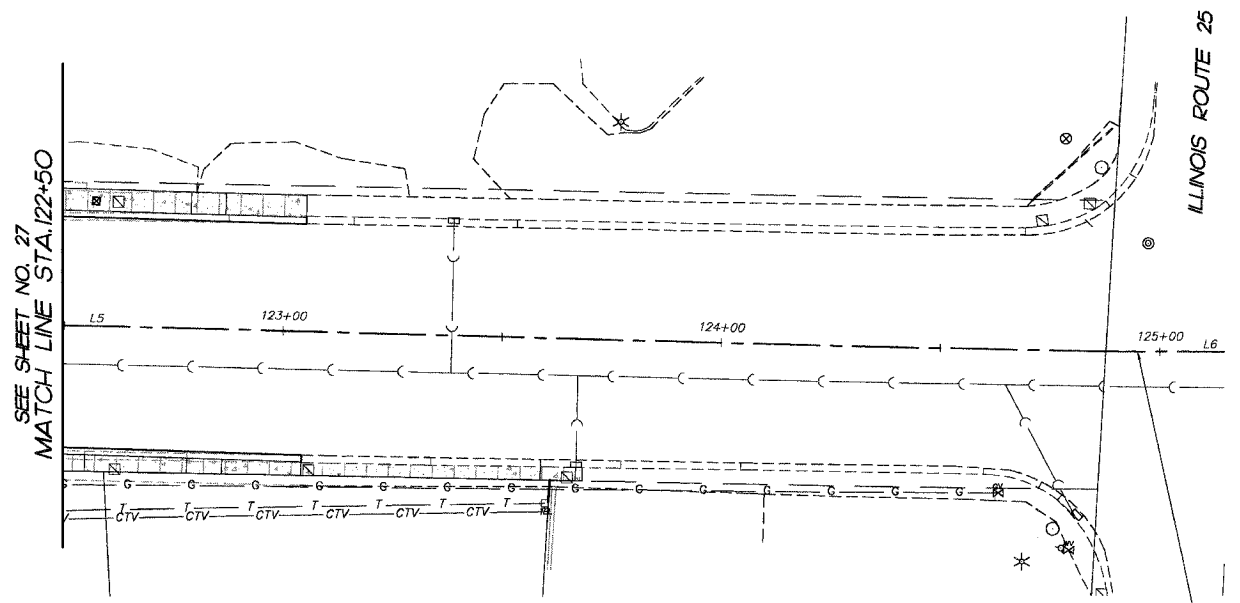

END ILLINOIS AVENUE  
IMPROVEMENTS  
STA. 124+95

LEGEND	
	DENOTES EXISTING STORM SEWER TO BE REMOVED, SIZE AS INDICATED.
	DENOTES STRUCTURE TO BE REMOVED (MANHOLE, VALVE VAULT, CATCH BASIN OR INLET)
	DENOTES PROPOSED DRAINAGE STRUCTURE OR STORM SEWER
	DENOTES PROPOSED WATERMAIN, OR FIRE HYDRANT
	DENOTES EXISTING STRUCTURE TO BE ADJUSTED WITH NEW TYPE 1 FRAME AND GRATE, CLOSED LID
	DENOTES PROPOSED SANITARY STRUCTURE

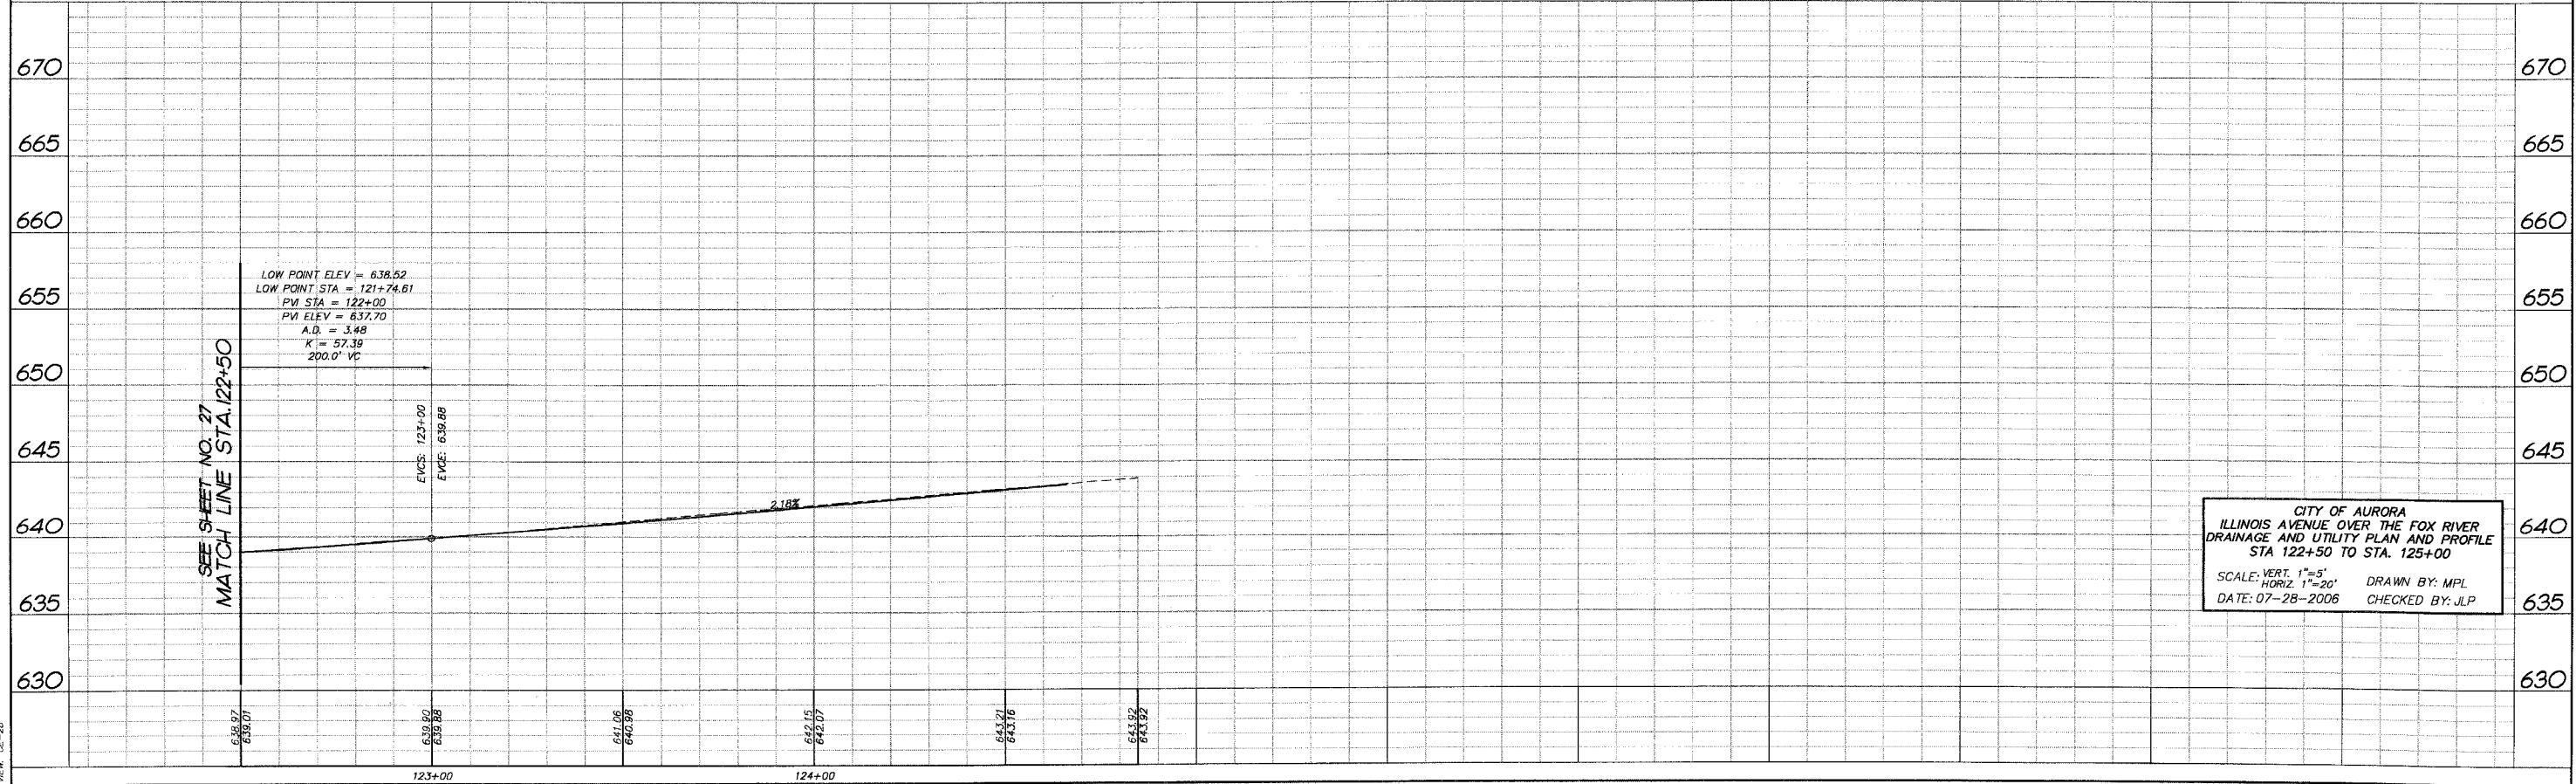

CITY OF AURORA  
ILLINOIS AVENUE OVER THE FOX RIVER  
DRAINAGE AND UTILITY PLAN AND PROFILE  
STA 122+50 TO STA. 125+00  
SCALE: VERT. 1"=5'  
HORIZ. 1"=20'  
DATE: 07-28-2006  
DRAWN BY: MPL  
CHECKED BY: JLP

DRAWN FILE: 0507181-60226.dwg  
DATE: 07-28-2006