
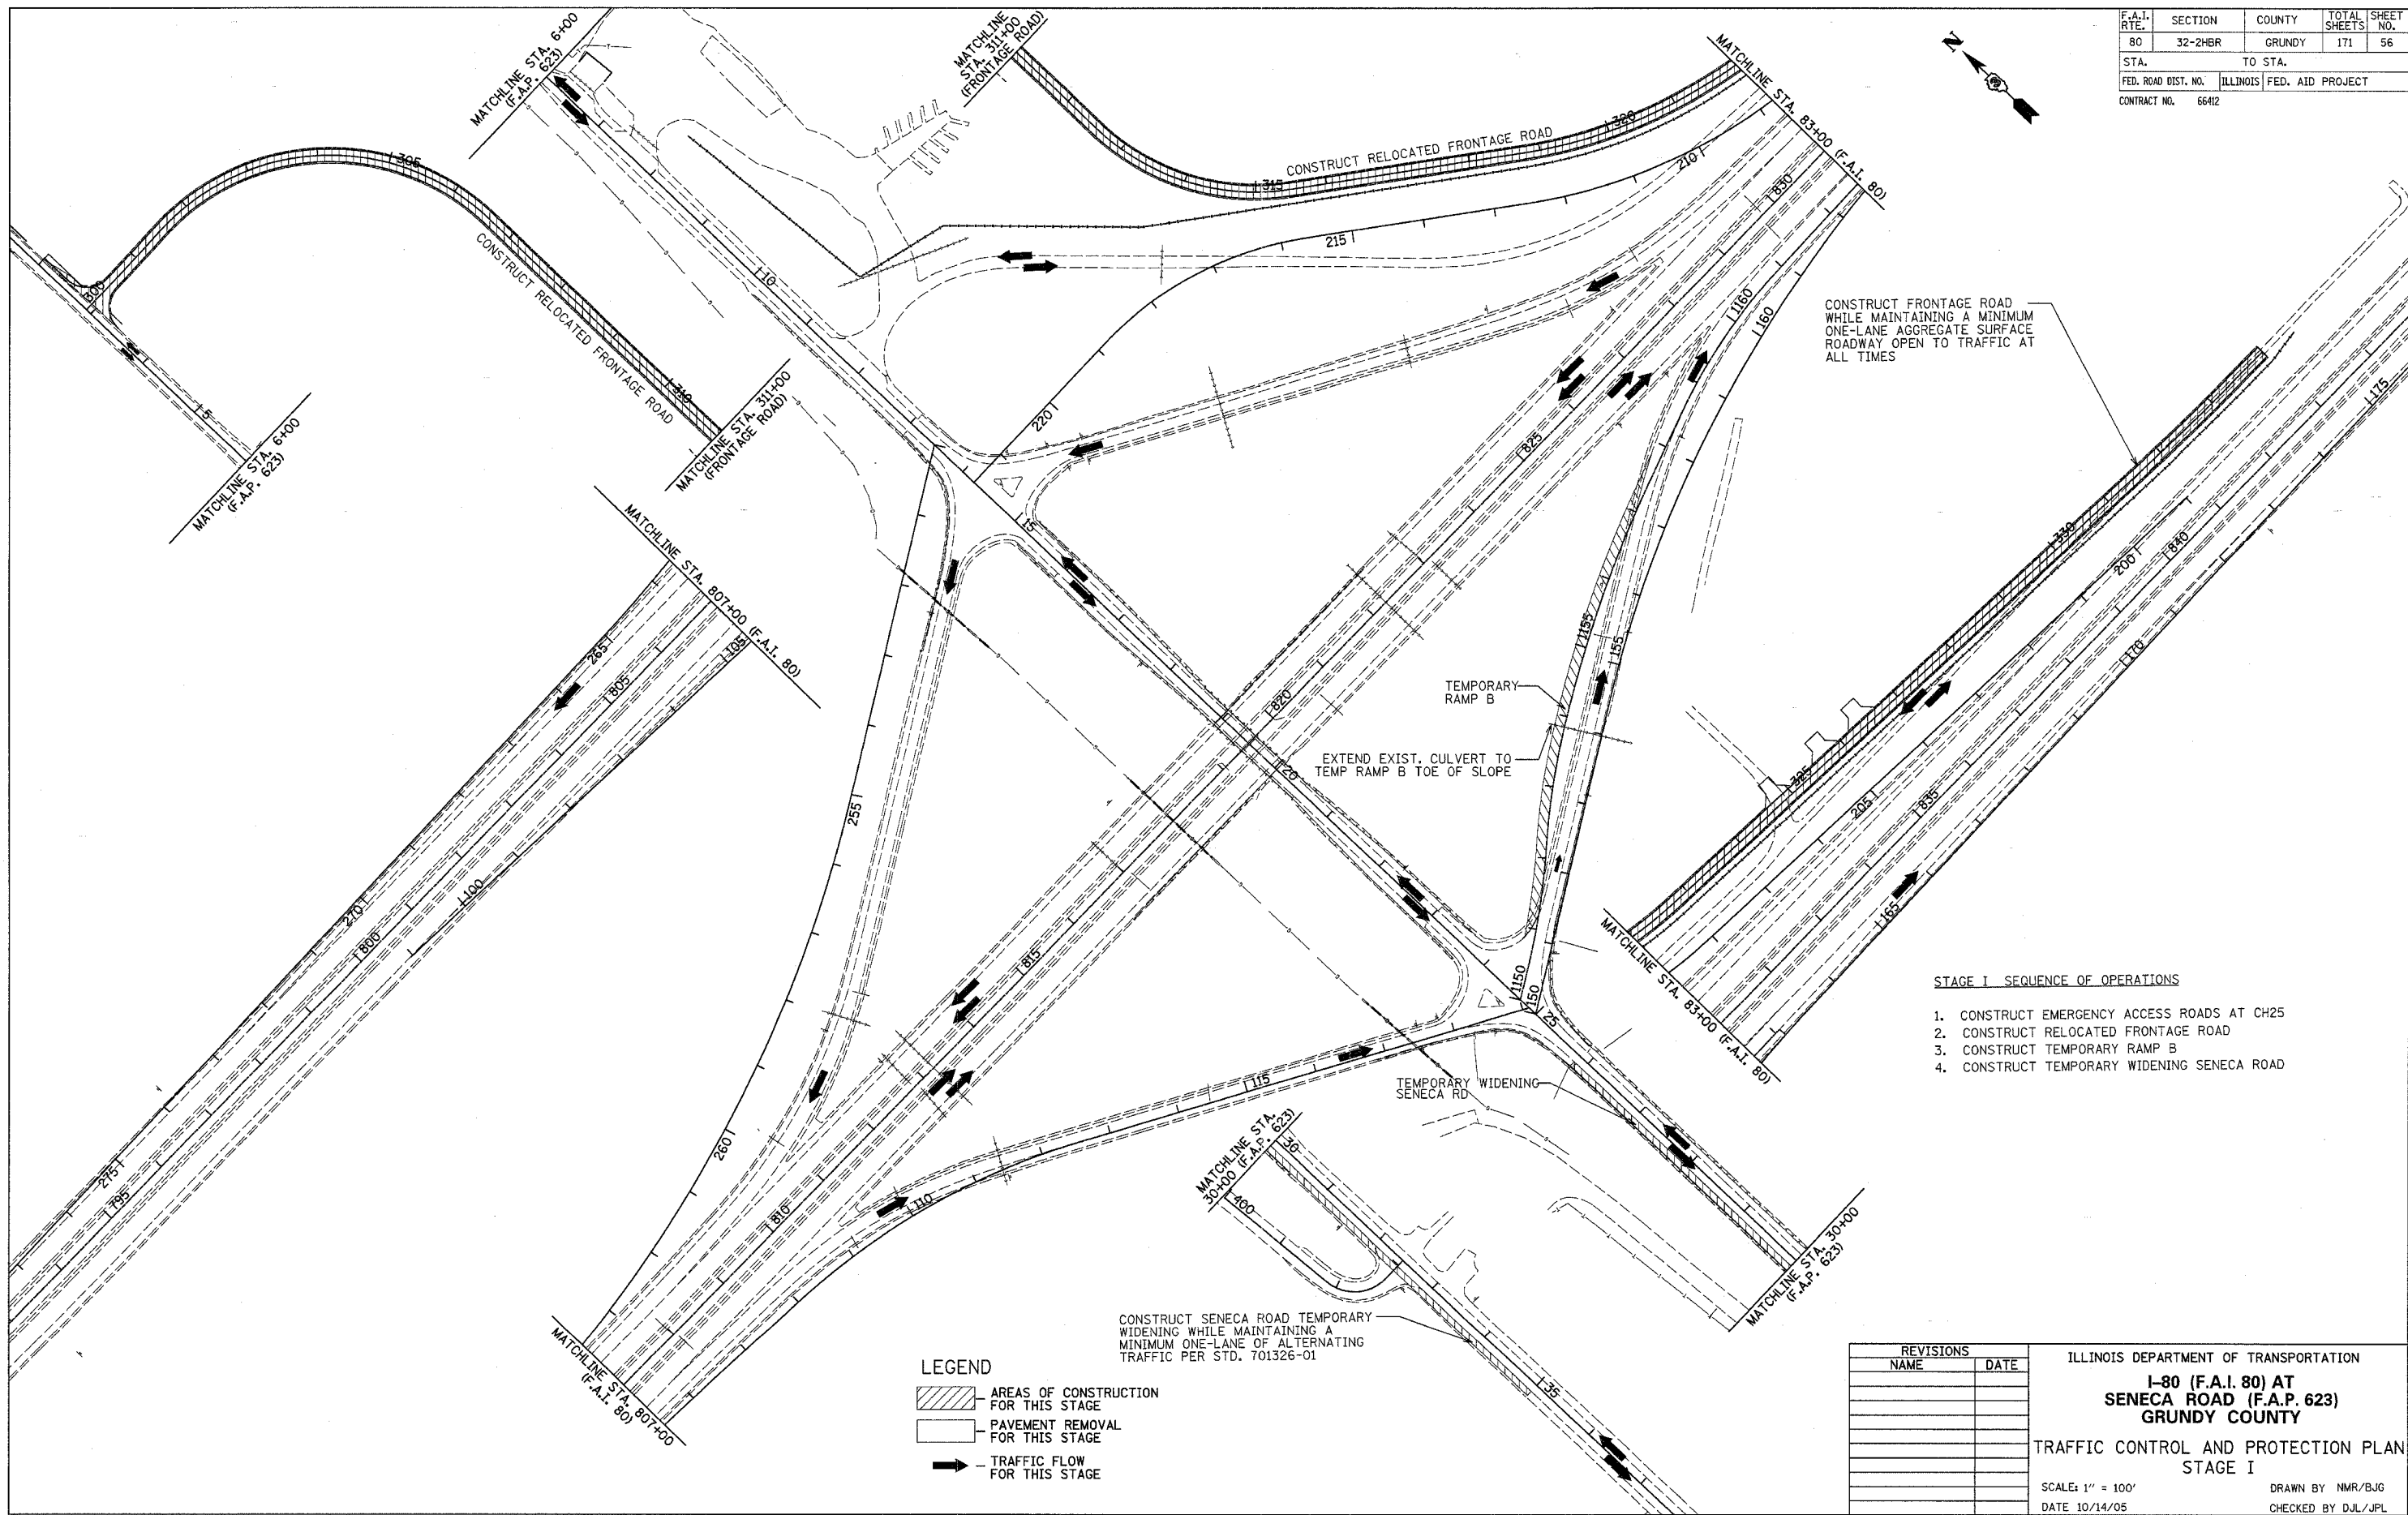


F.A.I. RTE.	SECTION	COUNTY	TOTAL SHEETS	SHEET NO.
80	32-2HBR	GRUNDY	171	56
STA.		TO STA.		
FED. ROAD DIST. NO.		ILLINOIS	FED. AID PROJECT	
CONTRACT NO.		66412		

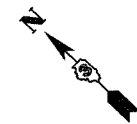

- STAGE I SEQUENCE OF OPERATIONS**
1. CONSTRUCT EMERGENCY ACCESS ROADS AT CH25
 2. CONSTRUCT RELOCATED FRONTAGE ROAD
 3. CONSTRUCT TEMPORARY RAMP B
 4. CONSTRUCT TEMPORARY WIDENING SENECA ROAD

- LEGEND**
- AREAS OF CONSTRUCTION FOR THIS STAGE
 - PAVEMENT REMOVAL FOR THIS STAGE
 - TRAFFIC FLOW FOR THIS STAGE

REVISIONS	
NAME	DATE

ILLINOIS DEPARTMENT OF TRANSPORTATION
**I-80 (F.A.I. 80) AT
 SENECA ROAD (F.A.P. 623)
 GRUNDY COUNTY**
 TRAFFIC CONTROL AND PROTECTION PLAN
 STAGE I
 SCALE: 1" = 100'
 DATE 10/14/05
 DRAWN BY NMR/BJG
 CHECKED BY DJL/JPL