
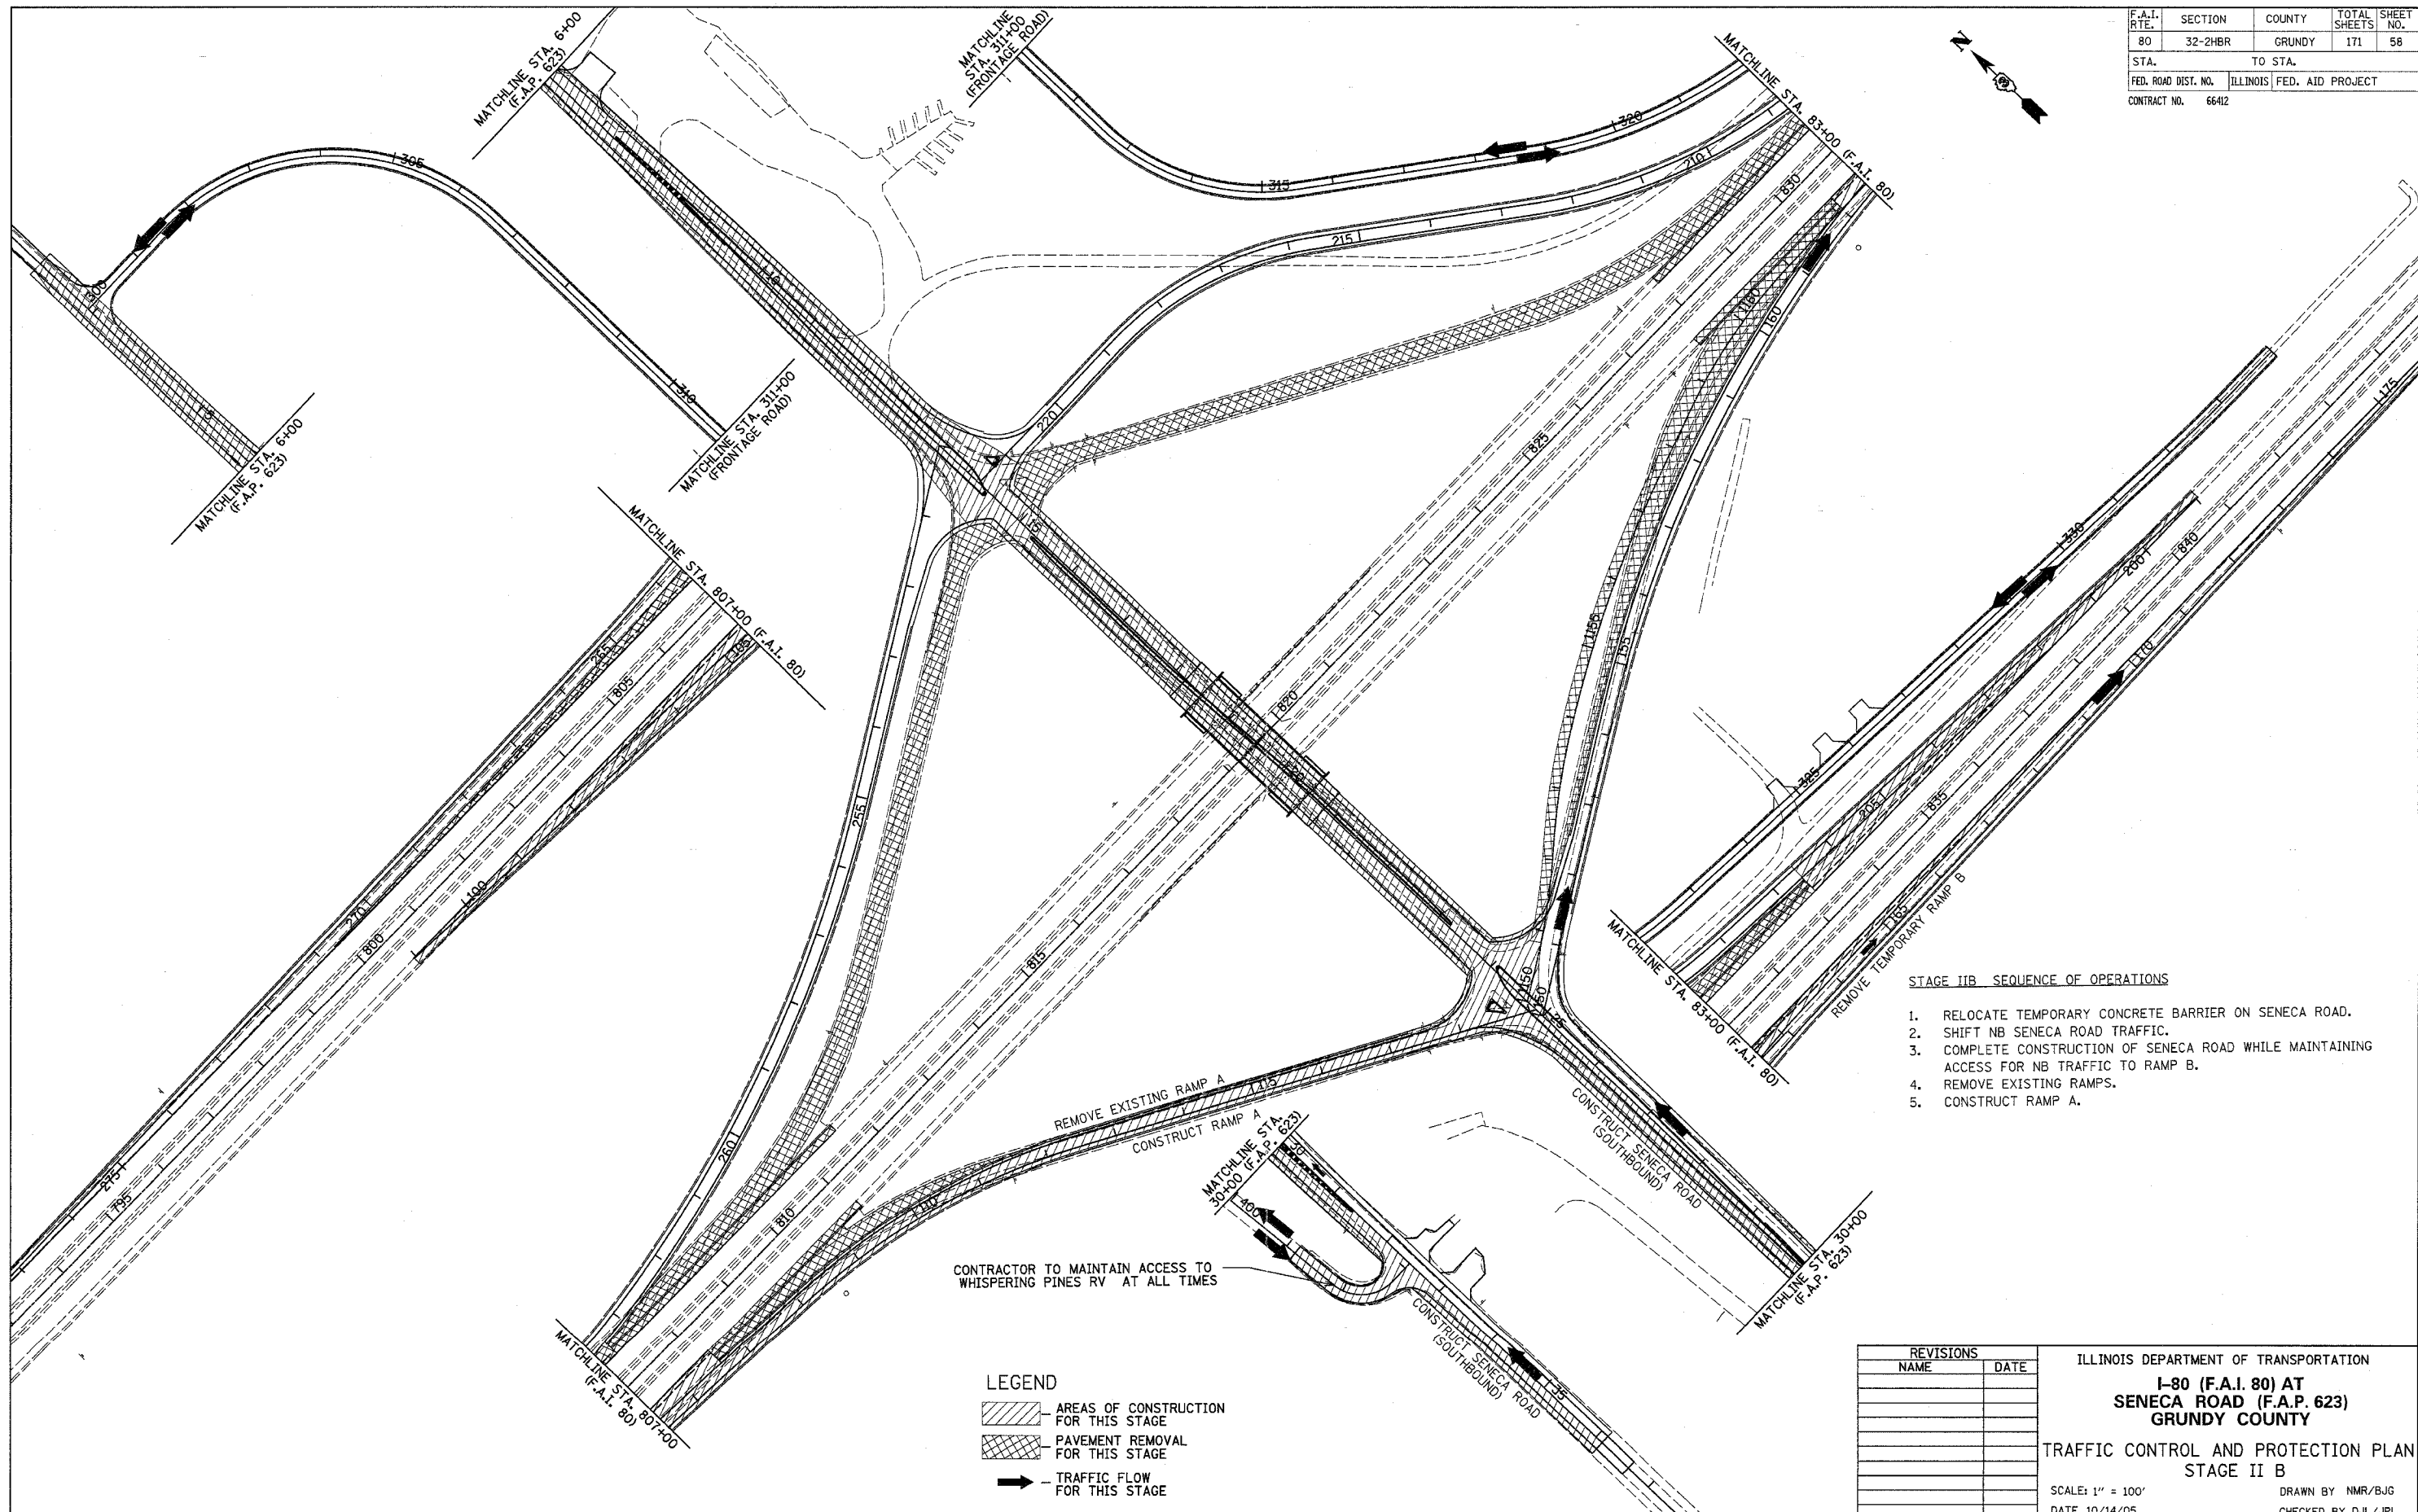


F.A.I. RTE.	SECTION	COUNTY	TOTAL SHEETS	SHEET NO.
80	32-2HBR	GRUNDY	171	58
STA.		TO STA.		
FED. ROAD DIST. NO.	ILLINOIS	FED. AID PROJECT		
CONTRACT NO.		66412		

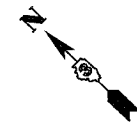

- STAGE IIB SEQUENCE OF OPERATIONS**
1. RELOCATE TEMPORARY CONCRETE BARRIER ON SENECA ROAD.
 2. SHIFT NB SENECA ROAD TRAFFIC.
 3. COMPLETE CONSTRUCTION OF SENECA ROAD WHILE MAINTAINING ACCESS FOR NB TRAFFIC TO RAMP B.
 4. REMOVE EXISTING RAMPS.
 5. CONSTRUCT RAMP A.

LEGEND

- AREAS OF CONSTRUCTION FOR THIS STAGE
- PAVEMENT REMOVAL FOR THIS STAGE
- TRAFFIC FLOW FOR THIS STAGE

REVISIONS	
NAME	DATE

ILLINOIS DEPARTMENT OF TRANSPORTATION
**I-80 (F.A.I. 80) AT
 SENECA ROAD (F.A.P. 623)
 GRUNDY COUNTY**
 TRAFFIC CONTROL AND PROTECTION PLAN
 STAGE II B
 SCALE: 1" = 100'
 DATE 10/14/05
 DRAWN BY NMR/BJG
 CHECKED BY DJL/JPL