


F.A.P. RTE.	SECTION	COUNTY	TOTAL SHEETS	SHEET NO.
328	109B-1	WHITE	26	9
STA.		TO STA.		
FED. ROAD DIST. NO.		ILLINOIS	FED. AID PROJECT	

SC 2

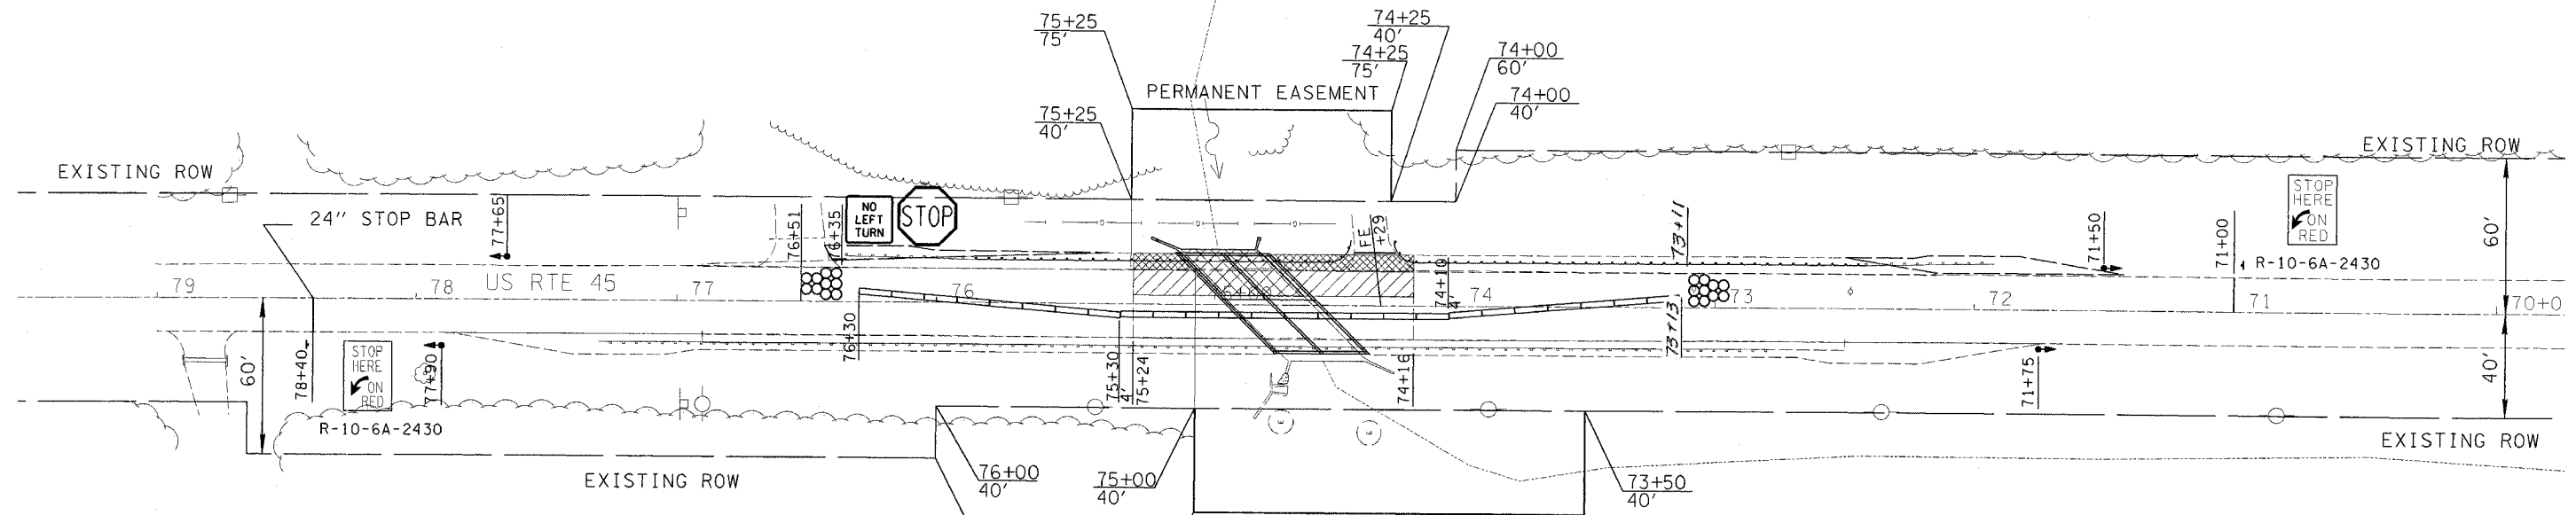

SUB-BASE GRANULAR MATERIAL, TYPE B
STAGE 2

74+16.00 TO 74+56.75	29
74+56.75 TO 74+83.25	6
74+83.25 TO 75+24.00	29
TOTAL	64 TON

BITUMINOUS CONCRETE PAVEMENT 14" (FULL DEPTH)
STAGE 2

74+16.00 TO 74+56.75	43
74+56.75 TO 74+83.25	28
74+83.25 TO 75+24.00	43
TOTAL	114 SQ YD

PAINT PAVEMENT MARKING REMOVAL

PERM. (RT EDGE) 71+00 TO 74+16	105
PERM. (RT EDGE) 75+24 TO 78+40	132
TEMP (RT EDGE) 71+00 TO 78+40	247
TEMP (CL) 71+00 TO 78+40	247
STOP BAR 71+00	26
STOP BAR 78+65	26
TOTAL	782 SQ FT

WORK ZONE PAVEMENT MARKING REMOVAL

71+00 TO 78+40	25 SQ FT
----------------	----------

SHORT TERM PAVEMENT MARKING

71+00 TO 78+40	76 FOOT
----------------	---------

PAVEMENT MARKING LINE-4"

	LENGTH (FOOT)	YELLOW (FOOT)	WHITE (FOOT)
CL 71+00 TO 78+40	740	190	
RT 71+00 TO 78+40	740		740
RT 71+00 TO 78+40	740		740
COLOR TOTAL	190	1480	
TOTAL	1670 FOOT		

PAVEMENT REMOVAL (SPECIAL)

74+16.00 TO 74+56.75	43
74+83.25 TO 75+24.00	43
TOTAL	86 SQ YD


PAVEMENT REMOVAL

RT 74+16.00 TO 74+56.75	29.4
LT 74+83.25 TO 75+24.00	29.4
TOTAL	59 SQ YD

BASE COURSE WIDENING

RT 74+16.00 TO 74+56.75	29
RT 74+83.25 TO 75+24.00	29
TOTAL	59 SQ YD

- STAGE II SEQUENCE OF OPERATIONS**
1. RELOCATE TEMPORARY CONCRETE BARRIERS, SIGNS, ETC. ACCORDING TO TRAFFIC CONTROL STANDARD 701321 AND PLACE TEMPORARY PAVEMENT MARKING TO ALLOW A 12' TRAFFIC LANE.
 2. REMOVE THE STAGE II PORTION OF THE EXISTING STRUCTURE, PAVEMENT AND GUARDRAIL.
 3. CONSTRUCT THE STAGE II PORTION OF THE NEW BOX CULVERT, SUB-BASE GRANULAR MATERIAL, TYPE B, BITUMINOUS CONCRETE PAVEMENT, 14", BASE COURSE WIDENING, GUARDRAIL, AND REMOVE AND RE-ERECT TRAFFIC TERMINAL, TYPE 1 SPECIAL (TANGENT).
 4. CONSTRUCT SEEDING, MULCH AND TEMPORARY DITCH CHECKS ON STAGE II TRAFFIC SIDE.
 5. REMOVE THE TRAFFIC CONTROL STANDARD 701321.

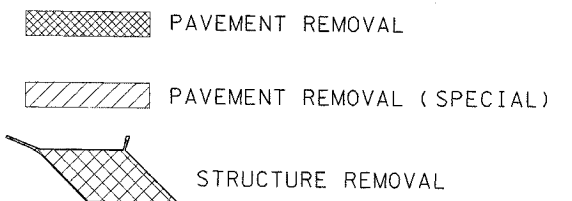

REVISIONS	
NAME	DATE

ILLINOIS DEPARTMENT OF TRANSPORTATION

STAGE CONSTRUCTION 2

SCALE: VERT. _____
HORIZ. _____

DATE _____

DRAWN BY _____
CHECKED BY _____

PLOT DATE = 10/25/2005
FILE NAME = #FILE#
USER NAME = #USER#

Rev.