


H:\DOT\2009-246 PTB 153 Item 2\016-110\Oriole_FinalEngineering\Plan Sheets\36-020\hg07v8.dgn 3:23:50 PM 11/4/2011

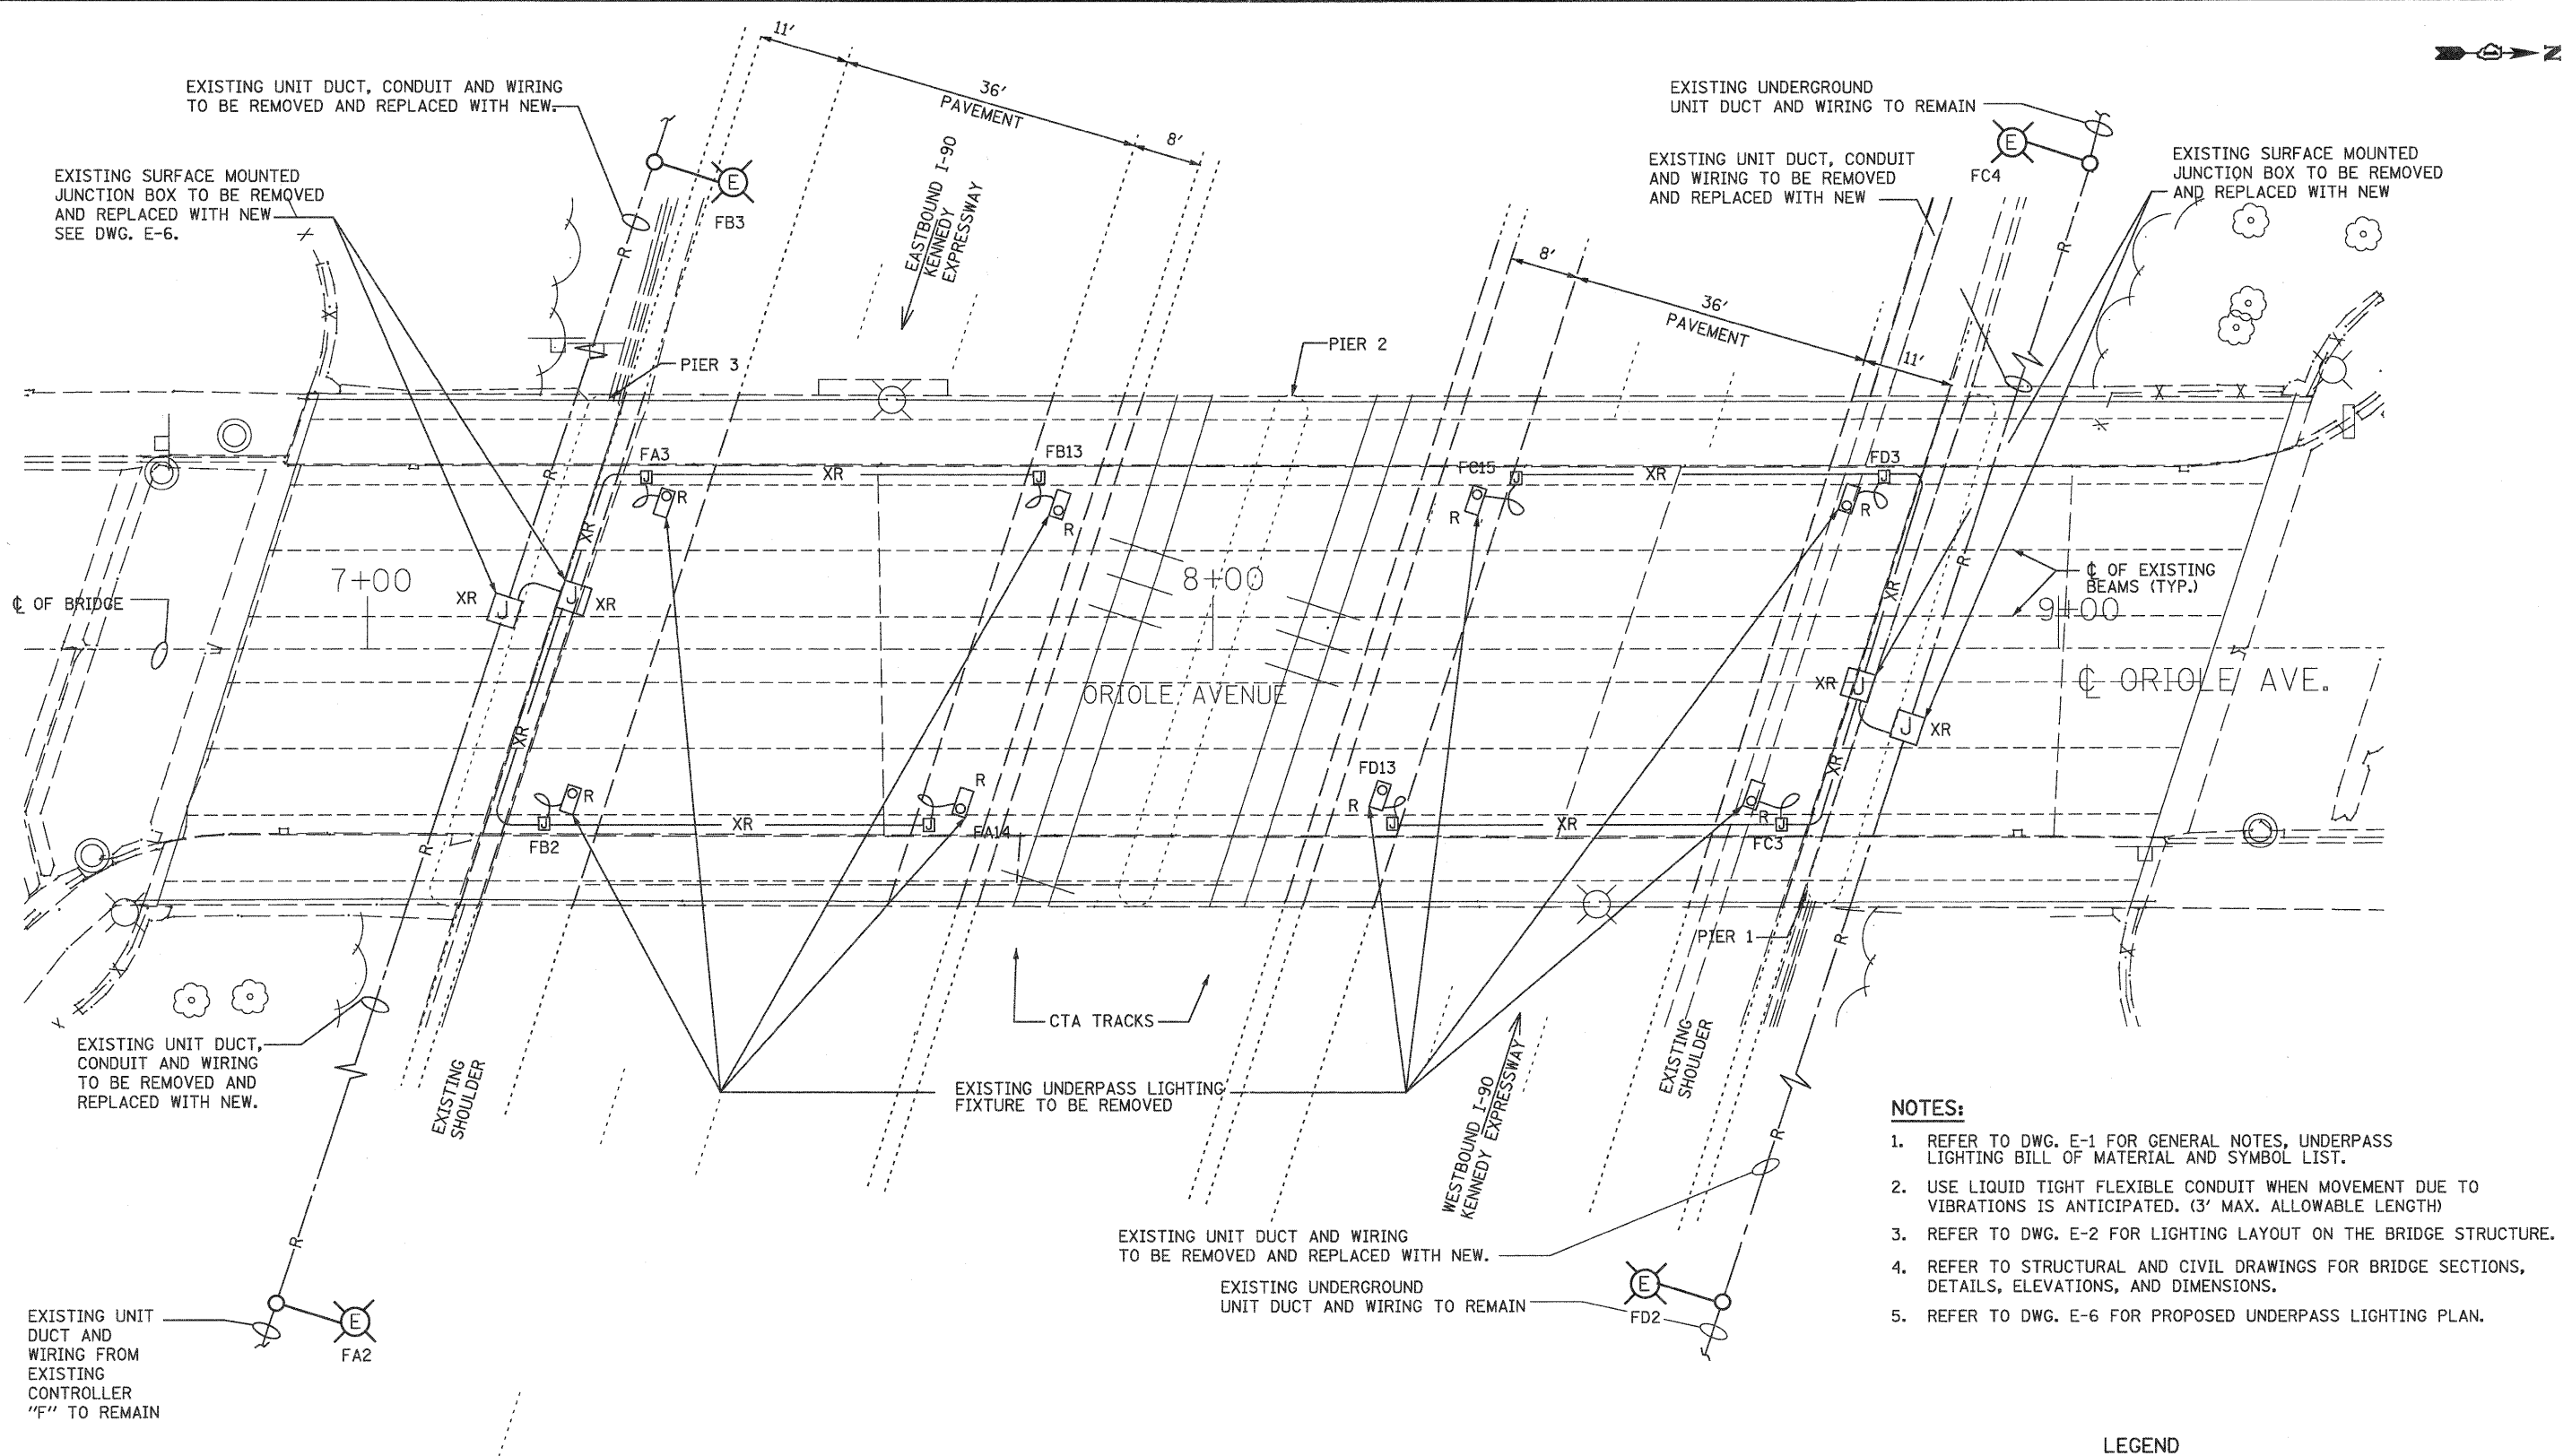

- NOTES:**
- REFER TO DWG. E-1 FOR GENERAL NOTES, UNDERPASS LIGHTING BILL OF MATERIAL AND SYMBOL LIST.
 - USE LIQUID TIGHT FLEXIBLE CONDUIT WHEN MOVEMENT DUE TO VIBRATIONS IS ANTICIPATED. (3' MAX. ALLOWABLE LENGTH)
 - REFER TO DWG. E-2 FOR LIGHTING LAYOUT ON THE BRIDGE STRUCTURE.
 - REFER TO STRUCTURAL AND CIVIL DRAWINGS FOR BRIDGE SECTIONS, DETAILS, ELEVATIONS, AND DIMENSIONS.
 - REFER TO DWG. E-6 FOR PROPOSED UNDERPASS LIGHTING PLAN.

LEGEND

---R---	EXISTING UNIDUCT TO BE REMOVED
-XR-	EXISTING TO BE REMOVED, UNLESS NOTED OTHERWISE
⊗	IDOT EXISTING LIGHTING STANDARD TO REMAIN
⊠	EXISTING UNDERPASS FIXTURE TO BE REMOVED

EXISTING UNDERPASS LIGHTING PLAN

ABNA
 DESIGN FIRM REG. 184.002117
 9901 S. Western Ave.
 Chicago, IL 60643
 Ph. 773-881-4788
 F: 773.239.3728

DESIGNED	TS	REVISED	-
CHECKED	TPP	REVISED	-
DRAWN	JS	REVISED	-
CHECKED	TPP	REVISED	-

STATE OF ILLINOIS
DEPARTMENT OF TRANSPORTATION

ORIOLE AVENUE AT I-90
STRUCTURE NO. 016-1101
 SCALE: 1" = 10' SHEET NO. XX OF XX SHEETS STA. TO STA.

F.A.I. RTE.	SECTION	COUNTY	TOTAL SHEETS	SHEET NO.
90	1515.1-B	COOK	101	36
CONTRACT NO. 60MT9			ILLINOIS FED. AID PROJECT	

DWG. E-5