

F.A.P. RTE.	SECTION	COUNTY	TOTAL SHEETS	SHEET NO.
307	130 R-2	DUPAGE, KANE	647	174
STA. 3390+00		TO STA. 3404+00		
FED. ROAD DIST. NO.	ILLINOIS	FED. AID PROJECT		


62410



MATCH LINE STA 3390+00
SEE SHEET DRN-10

MATCH LINE STA 3404+00
SEE SHEET DRN-12


NOTES:
 1. SEE DRAINAGE SCHEDULE FOR CULVERT, STRUCTURE, PIPE, AND UNDERDRAIN INFORMATION

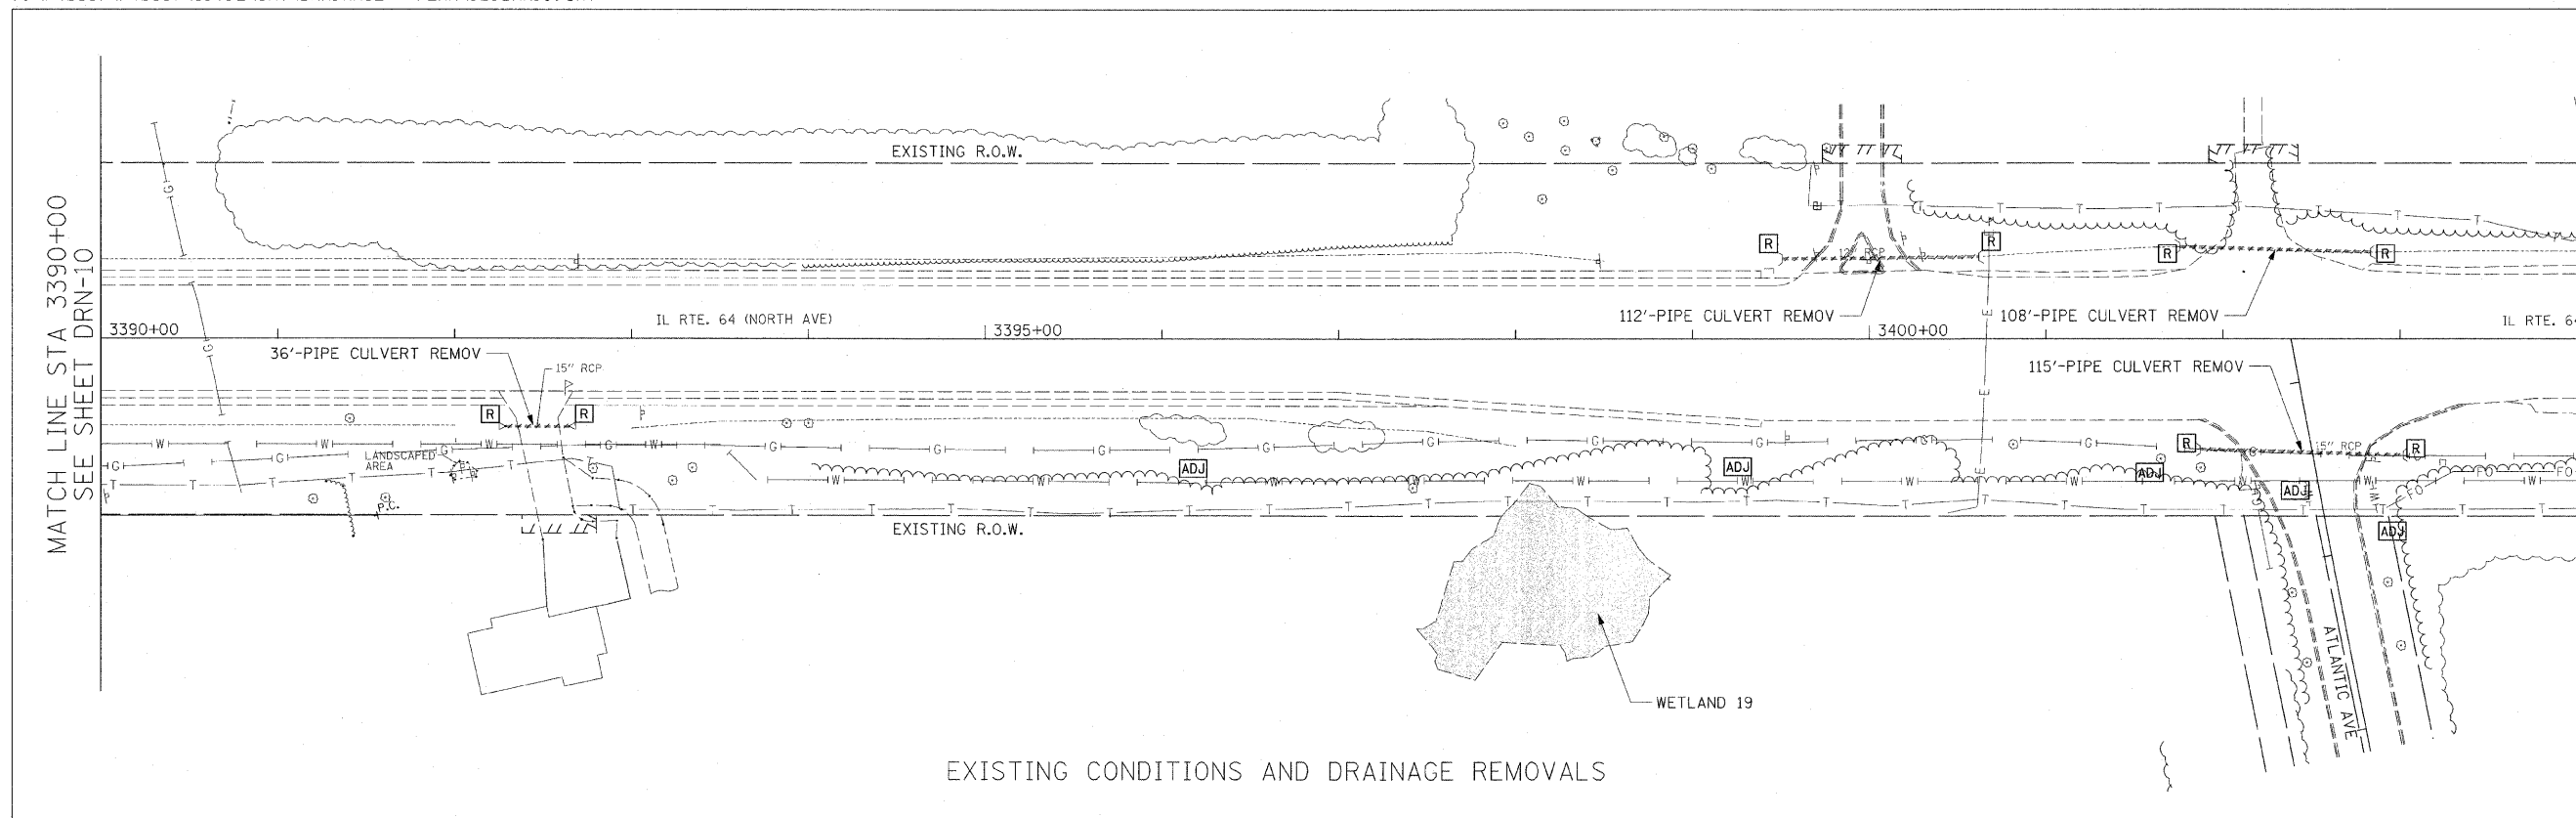

EXISTING CONDITIONS AND DRAINAGE REMOVALS

MATCH LINE STA 3390+00
SEE SHEET DRN-10

MATCH LINE STA 3404+00
SEE SHEET DRN-12

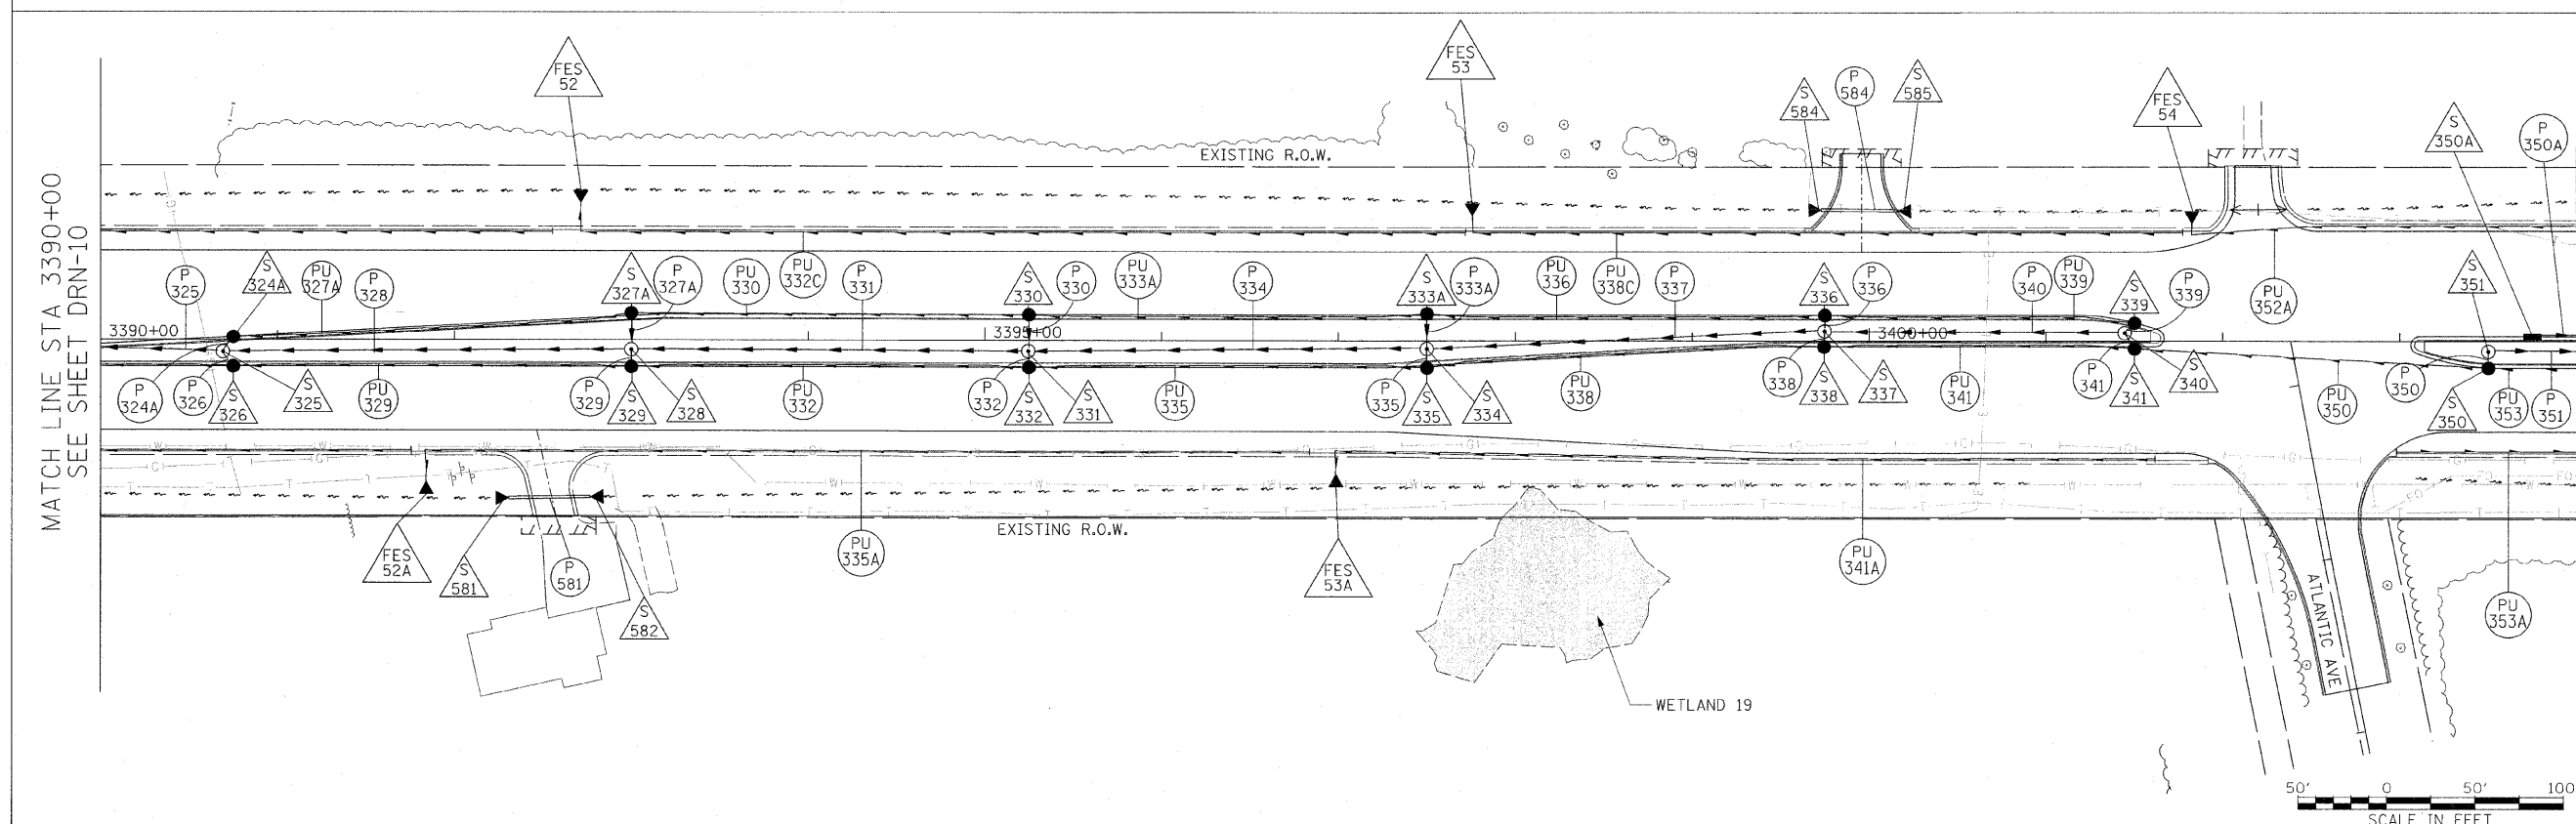

PROPOSED DRAINAGE PLAN



DRN-11



REVISIONS	
NAME	DATE

ILLINOIS DEPARTMENT OF TRANSPORTATION
 F.A.P. ROUTE 307 (ILLINOIS ROUTE 64)

DRAINAGE PLAN
 IL ROUTE 64
 STA. 3390+00 TO STA. 3404+00

SCALE: VERT: NONE
 HORIZ: 1" = 50"
 DATE: DECEMBER 2, 2011

DRAWN BY: AFC
 CHECKED BY: EBY