


F.A.P. RTE.	SECTION	COUNTY	TOTAL SHEETS	SHEET NO.
307	130 R-2	DUPAGE, KANE	647	175
STA. 3404+00		TO STA. 3417+00		
FED. ROAD DIST. NO.	ILLINOIS FED. AID PROJECT			


62410

**NOTES:**

- SEE DRAINAGE SCHEDULE FOR CULVERT, STRUCTURE, PIPE, AND UNDERDRAIN INFORMATION

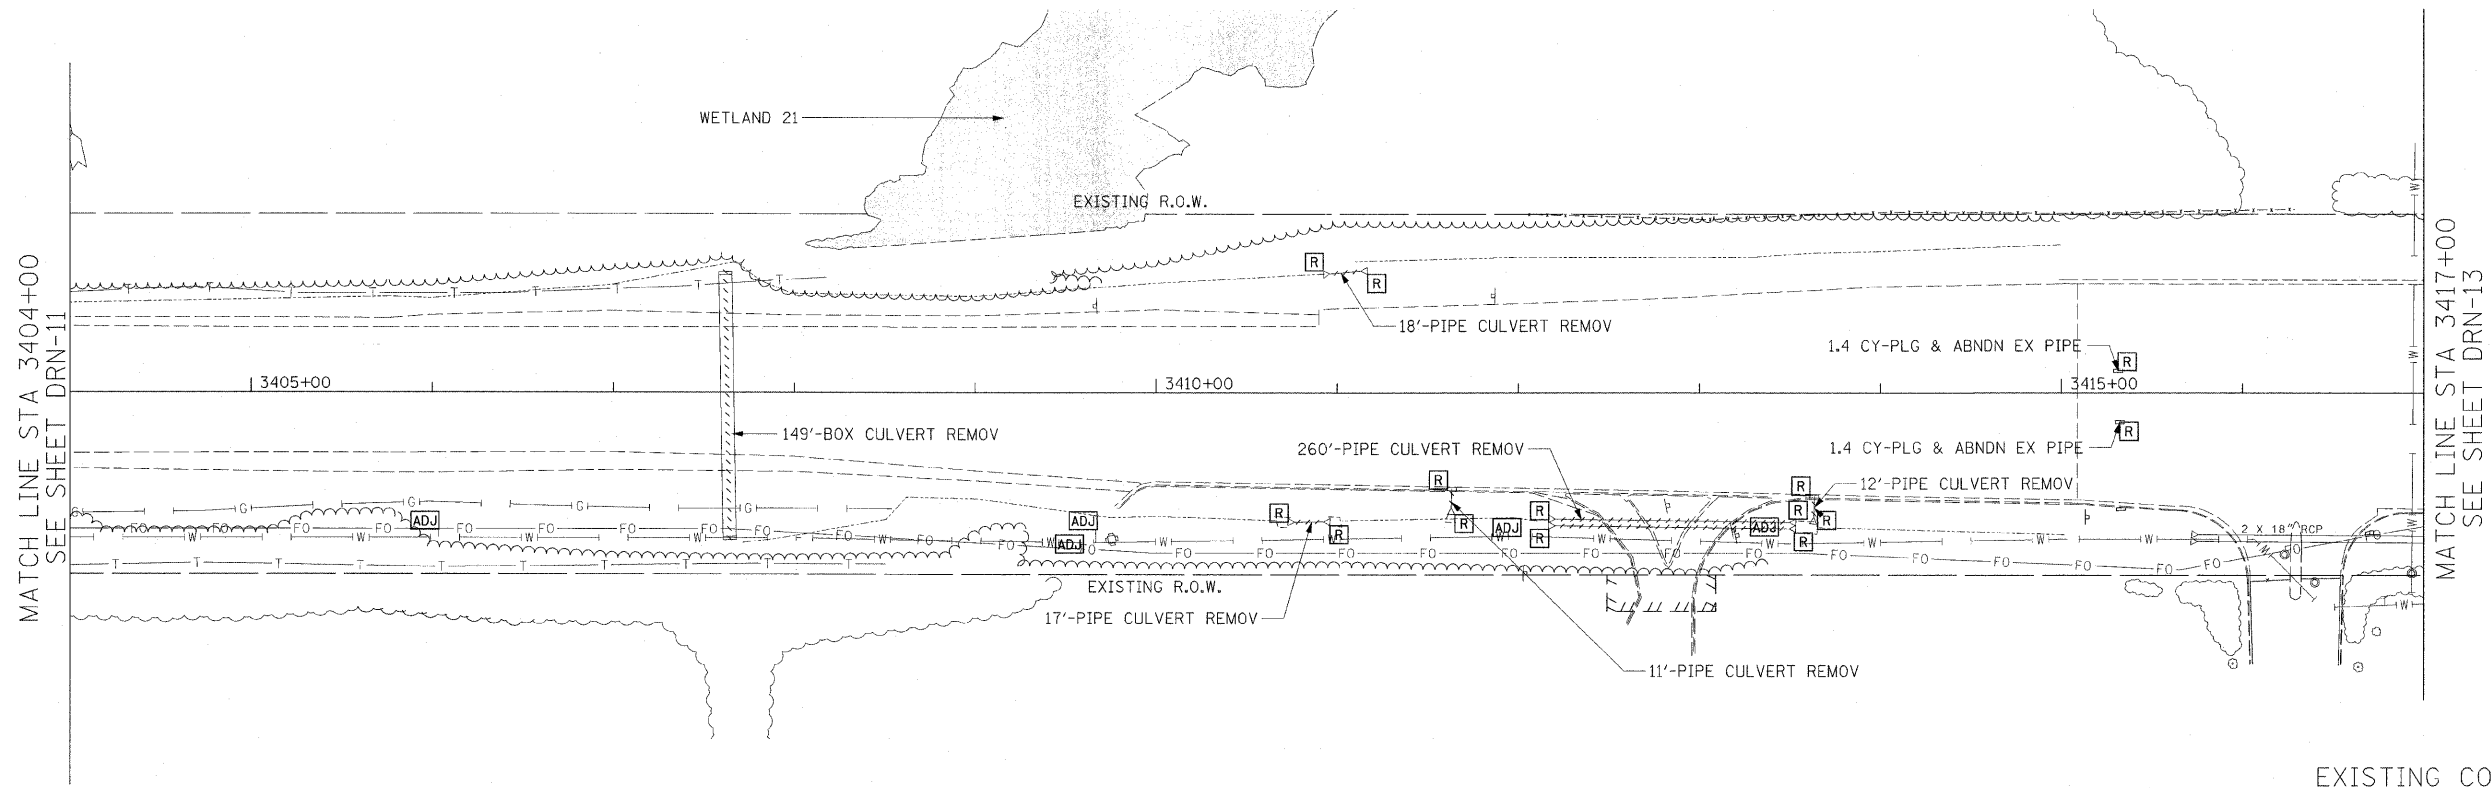

EXISTING CONDITIONS AND DRAINAGE REMOVALS

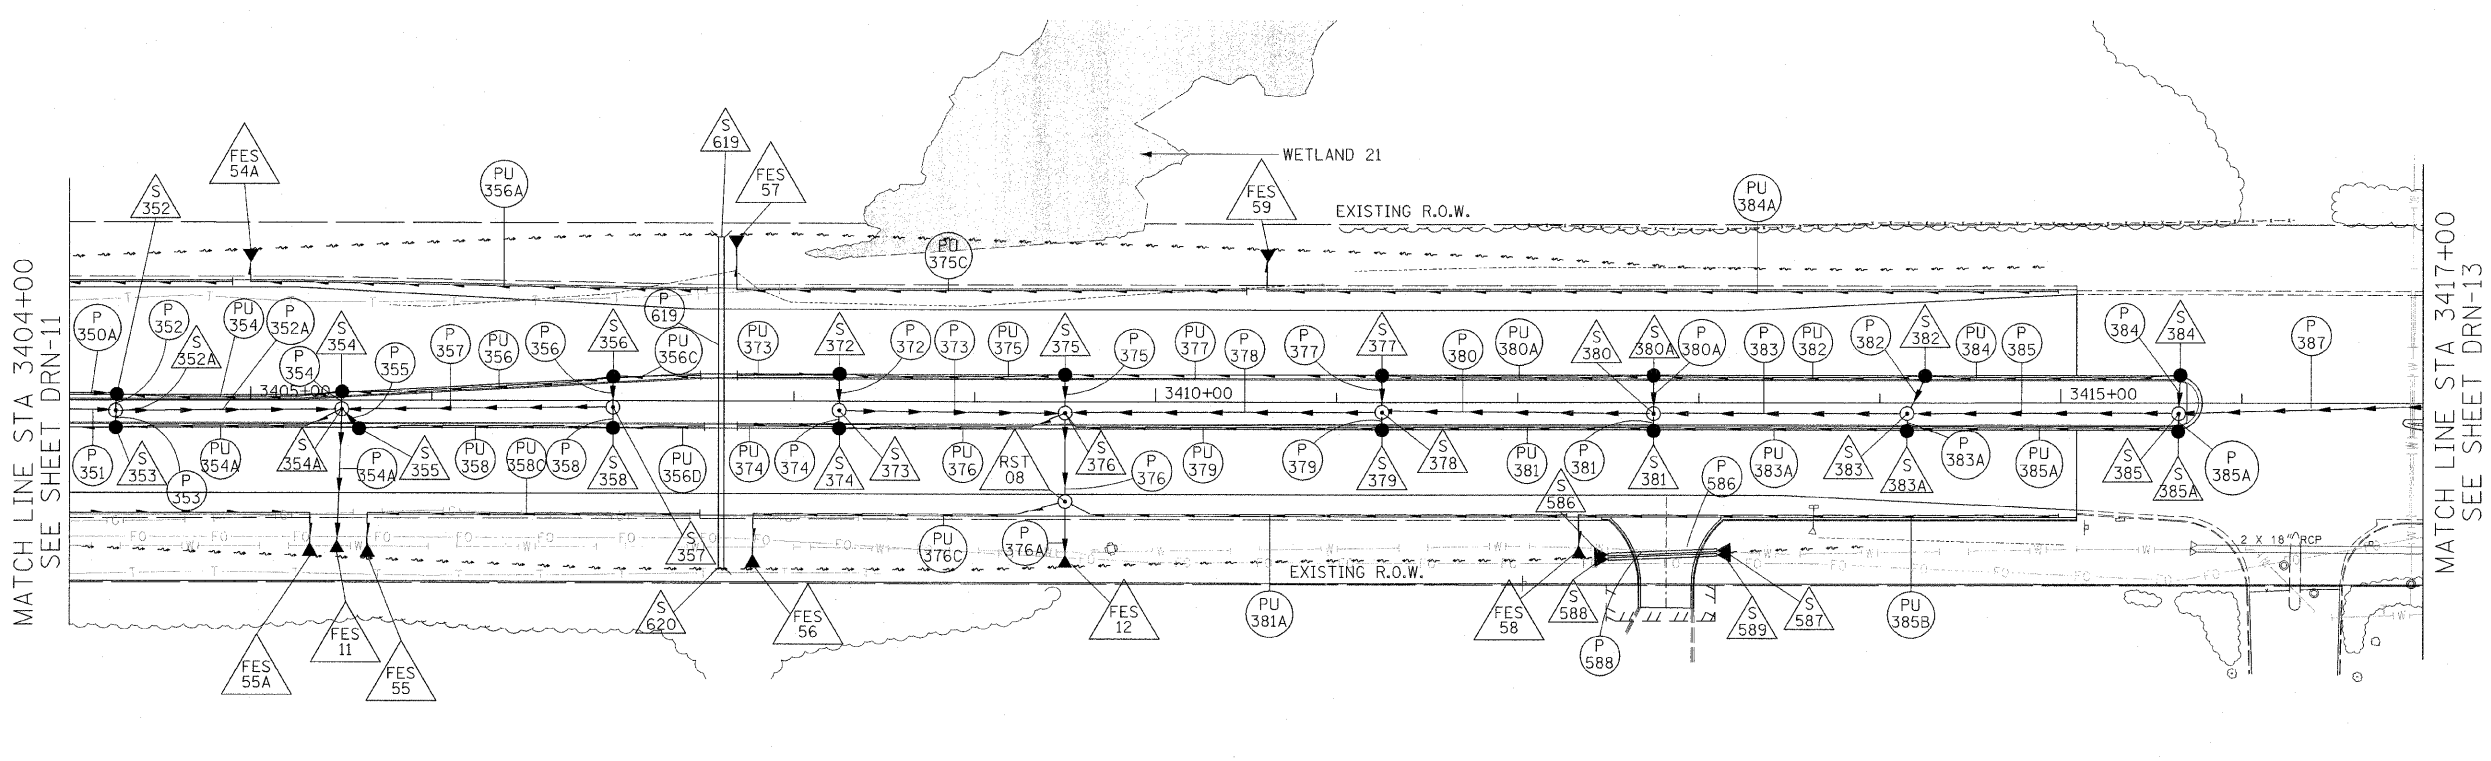

PROPOSED DRAINAGE PLAN



DRN-12

REVISIONS	
NAME	DATE

ILLINOIS DEPARTMENT OF TRANSPORTATION  
 F.A.P. ROUTE 307 (ILLINOIS ROUTE 64)

DRAINAGE PLAN  
 IL ROUTE 64  
 STA. 3404+00 TO STA. 3417+00

SCALE: VERT: NONE  
 HORIZ: 1" = 50"  
 DATE: DECEMBER 2, 2011  
 DRAWN BY: AFC  
 CHECKED BY: EBY

