
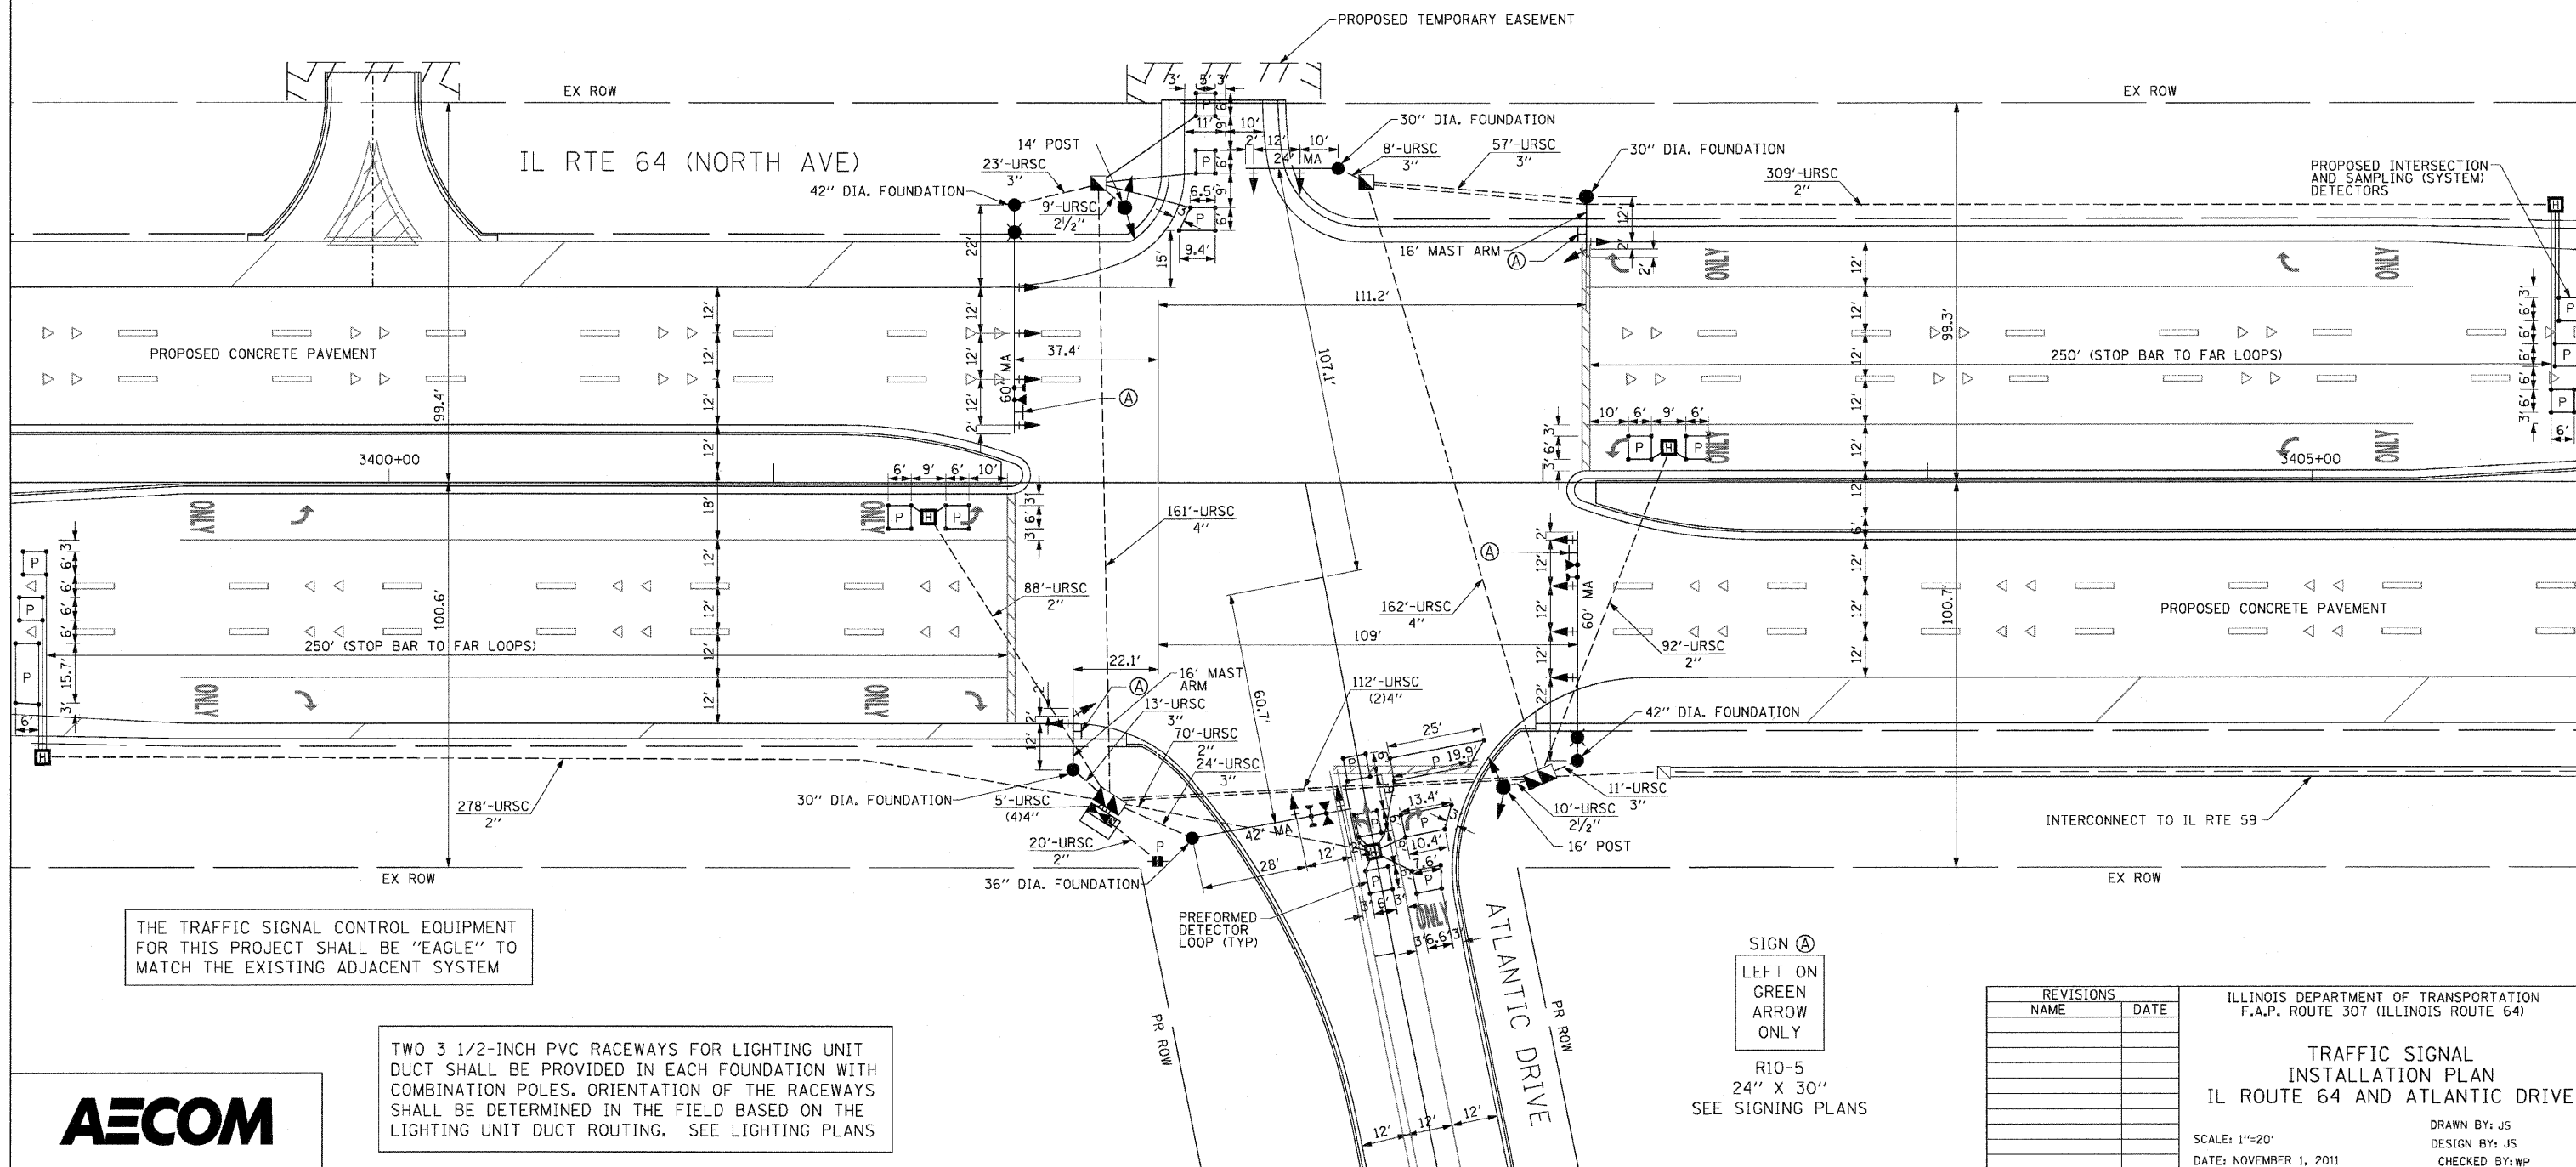


F.A.P. RTE.	SECTION	COUNTY	TOTAL SHEETS	SHEET NO.
307	130 R-2	DUPAGE, KANE	647	383
STA.		TO STA.		
FED. ROAD DIST. NO.		ILLINOIS FED. AID PROJECT		

62410

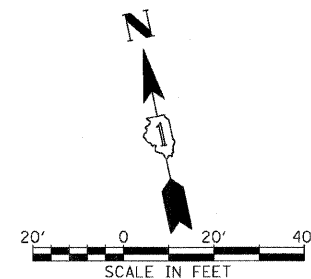

THE TRAFFIC SIGNAL CONTROL EQUIPMENT FOR THIS PROJECT SHALL BE "EAGLE" TO MATCH THE EXISTING ADJACENT SYSTEM

TWO 3 1/2-INCH PVC RACEWAYS FOR LIGHTING UNIT DUCT SHALL BE PROVIDED IN EACH FOUNDATION WITH COMBINATION POLES. ORIENTATION OF THE RACEWAYS SHALL BE DETERMINED IN THE FIELD BASED ON THE LIGHTING UNIT DUCT ROUTING. SEE LIGHTING PLANS

SIGN (A)  
 LEFT ON GREEN  
 ARROW  
 ONLY

R10-5  
 24" X 30"  
 SEE SIGNING PLANS

REVISIONS	
NAME	DATE

ILLINOIS DEPARTMENT OF TRANSPORTATION  
 F.A.P. ROUTE 307 (ILLINOIS ROUTE 64)

**TRAFFIC SIGNAL  
 INSTALLATION PLAN  
 IL ROUTE 64 AND ATLANTIC DRIVE**

SCALE: 1"=20'  
 DATE: NOVEMBER 1, 2011

DRAWN BY: JS  
 DESIGN BY: JS  
 CHECKED BY: WP

