

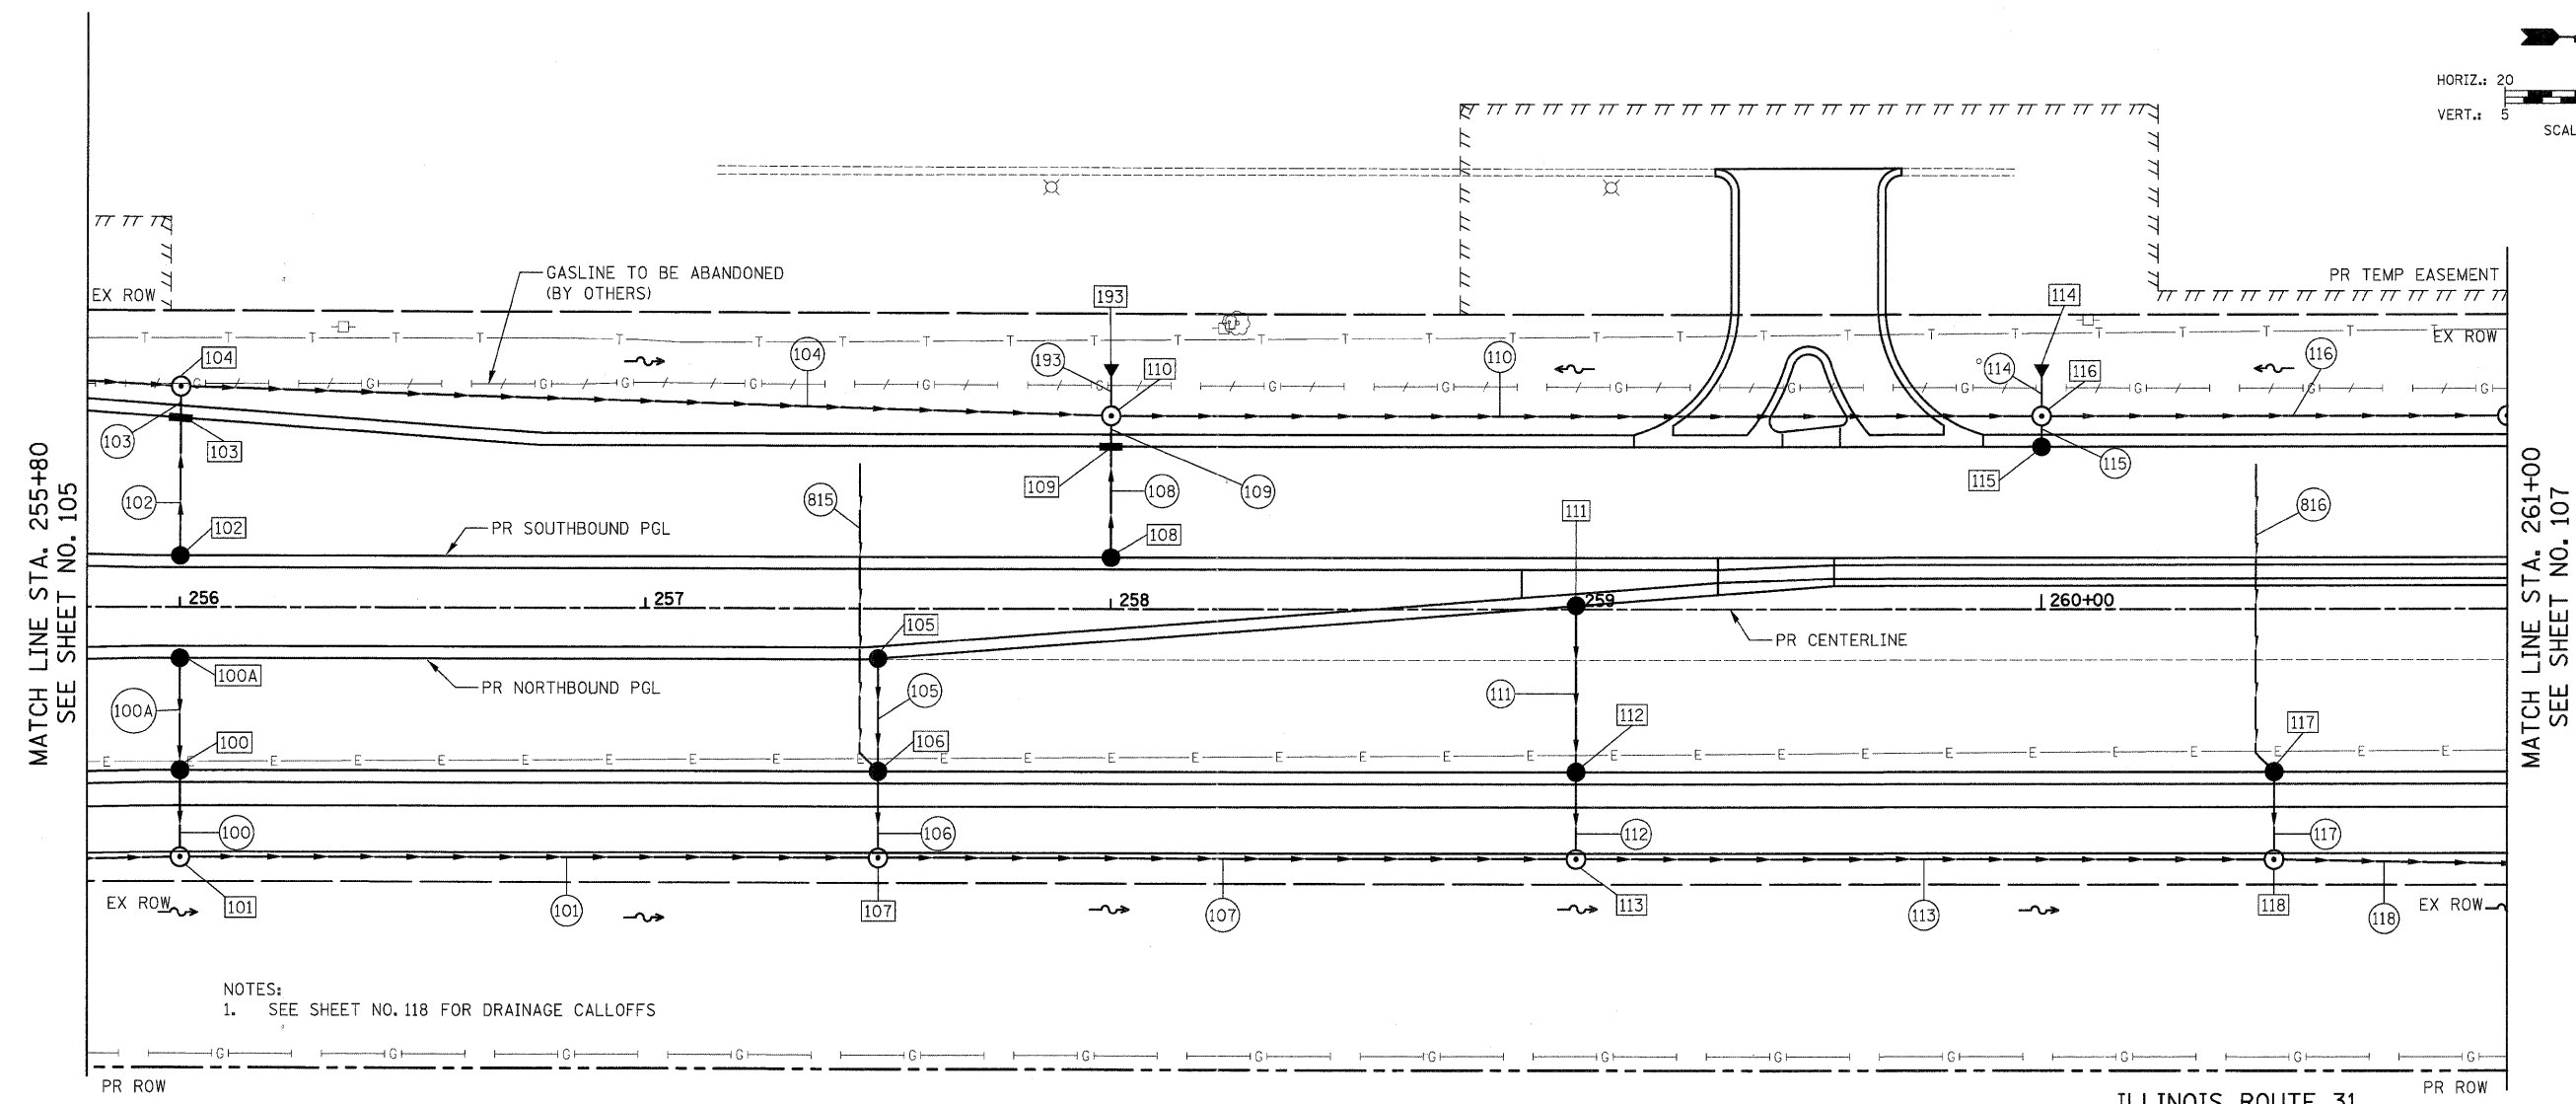


DATE	
BY	
PLAN	
REVIEWED	
PLOTTED	
ALIGNMENT CHECKED	
NOTE BOOK	
NO.	
CADD FILE NAME	

DATE	
BY	
PROFILE	
REVIEWED	
PLOTTED	
GRADES CHECKED	
NOTE BOOK	
NO.	
STRUCTURE NOTATIONS CHECKED	

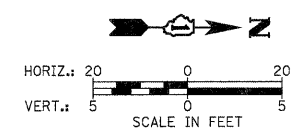

NOTES:  
1. SEE SHEET NO. 118 FOR DRAINAGE CALLOFFS

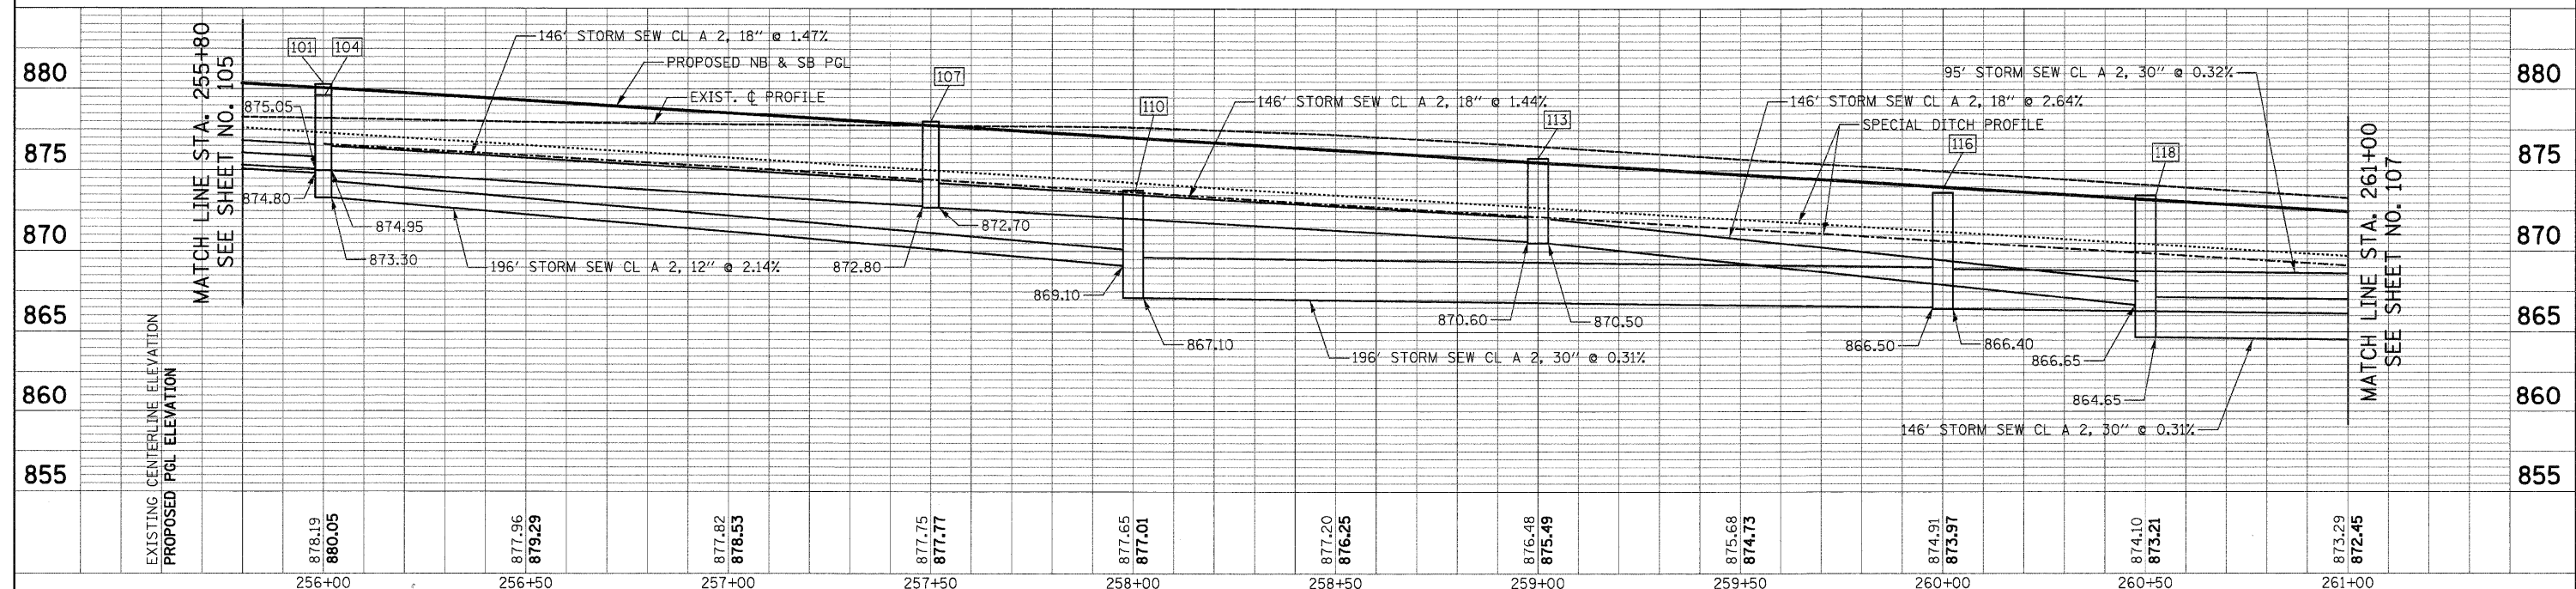

FILE NAME =	USER NAME = dte	DESIGNED - KWH	REVISED -	<b>STATE OF ILLINOIS DEPARTMENT OF TRANSPORTATION</b>	<b>DRAINAGE AND UTILITY PLAN</b>		F.A.J. RTE. 3987	SECTION 96-00209-01-PV	COUNTY McHENRY	TOTAL SHEETS 271	SHEET NO. 106	
Y:\2278-Virginia Klassen\cadd\sheet\11-D\drainageAndUtilities\2278_0&U_10.dgn	PLOT SCALE = 22.0000' / in.	DRAWN - DTE	REVISED -		SCALE: 1" = 20'	SHEET NO. 10 OF 23 SHEETS	STA. 255+80 TO STA. 261+00	FED. ROAD DIST. NO. 1 ILLINOIS	FED. AID PROJECT HPP-4064(003)	<b>CONTRACT NO. 63553</b>		
PLOT DATE = 10/24/2011	DATE = 10/24/11	CHECKED - GAB	REVISED -									