



**NOTE**

REFER TO SPECIFICATIONS REGARDING POTENTIAL UTILITY CONFLICTS

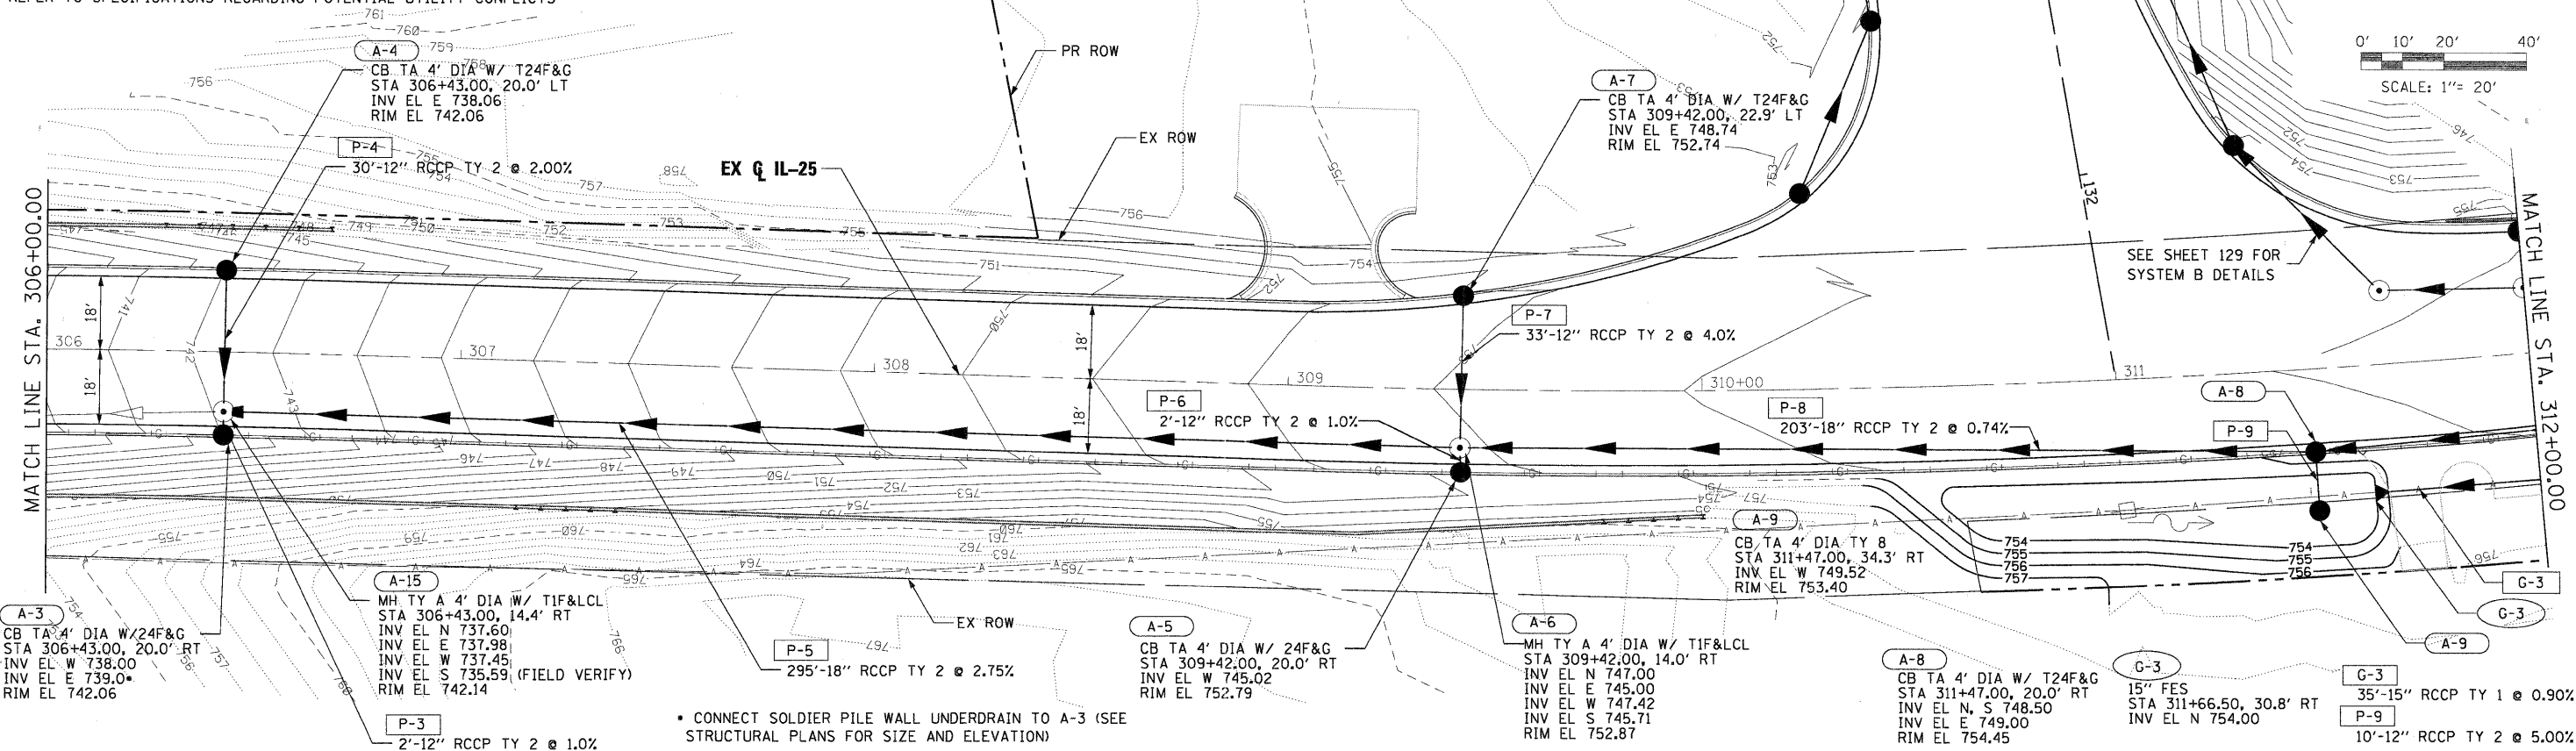


CONNECT SOLDIER PILE WALL UNDERDRAIN TO A-3 (SEE STRUCTURAL PLANS FOR SIZE AND ELEVATION)

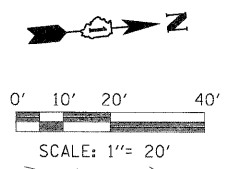

DATE	
BY	
REVISION	
NO.	
DATE	
BY	
REVISION	
NO.	

DATE	
BY	
REVISION	
NO.	
DATE	
BY	
REVISION	
NO.	

PLOT SCALE: 1"=20'  
 PLOT DATE: 11/29/2011  
 FILE NAME: ...  
 USER NAME: tblank  
 DATE: 10/23/2011

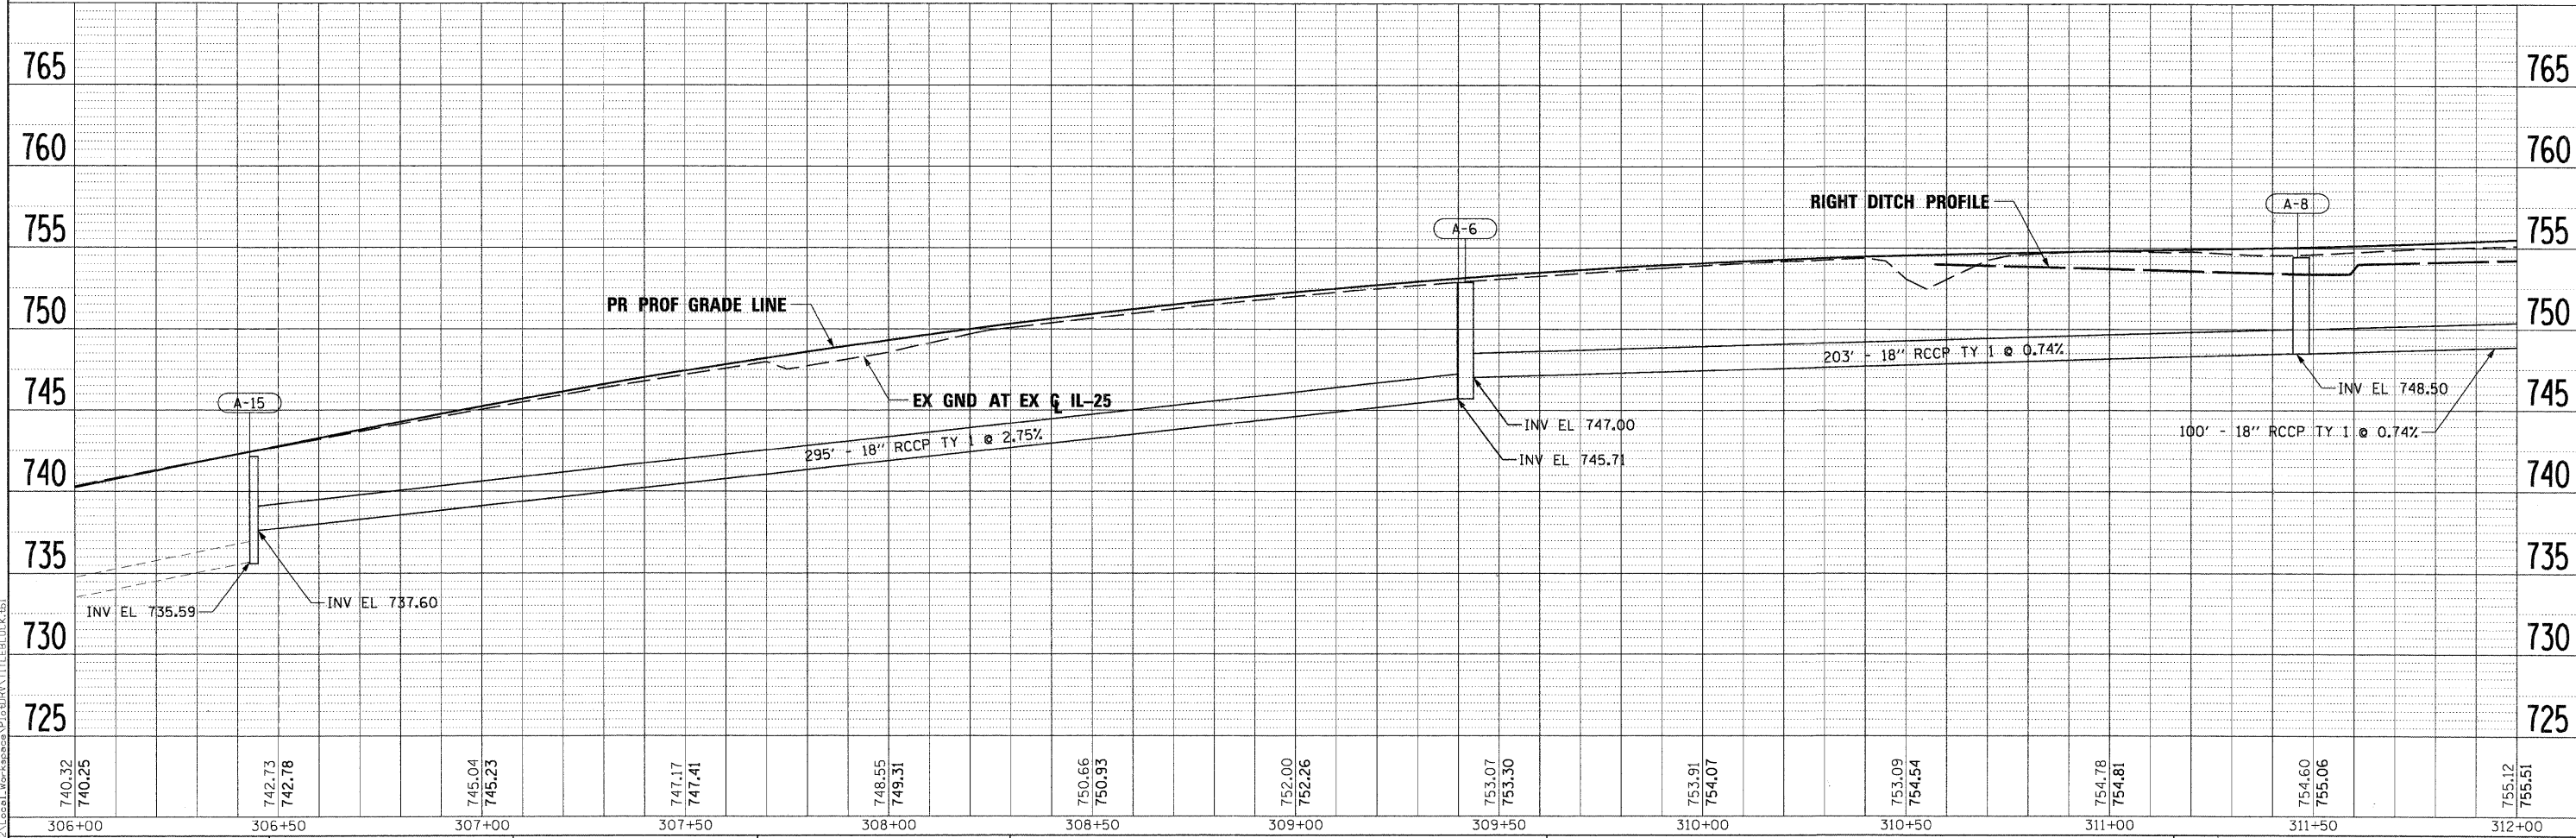

FILE NAME =	DESIGNED - MAC	REVISED -		<b>CITY OF ST. CHARLES</b>	<b>DRAINAGE AND UTILITY PLAN AND PROFILE</b> <b>IL 25</b>			F.A. RTE.	SECTION	COUNTY	TOTAL SHEETS	SHEET NO.
DRAWN - TMB	REVISED -				04-00092-00-BR	KANE	440	136				
CHECKED - RMT	REVISED -				CONTRACT NO. 63650							
DATE - 10/23/2011	REVISED -				ILLINOIS FED. AID PROJECT							
					SCALE: 1"=20'	SHEET NO. 12 OF 19 SHEETS	STA. 306+00.00 TO STA. 312+00.00					