


- LEGEND**
- ⊙ EXISTING DOUBLE ACORN LIGHTING UNIT (TO REMAIN)
  - ⊕ PROPOSED DOUBLE ACORN LIGHTING UNIT
  - EXISTING ROADWAY LIGHTING UNIT
  - ⊗ EXISTING LIGHTING UNIT
  - ⊘ EXISTING HANDHOLE

- NOTES:**
1. ELECTRIC CABLE IN CONDUIT FOR ROADWAY LIGHT TO BE REMOVED WILL BE DISCONNECTED AND REMOVED IN THE HANDHOLE SOUTH OF THE PROJECT LIMITS.
  2. CONTACT CITY OF ELMHURST ELECTRICAL DIVISION FOR EXACT LOCATIONS AND CIRCUITS.
  3. EACH TREE PIT SHALL CONTAIN A DUPLEX WATERPROOF GFI RECEPTICLE WIRED FROM AN ADJACENT LIGHT POLE AS SHOWN.

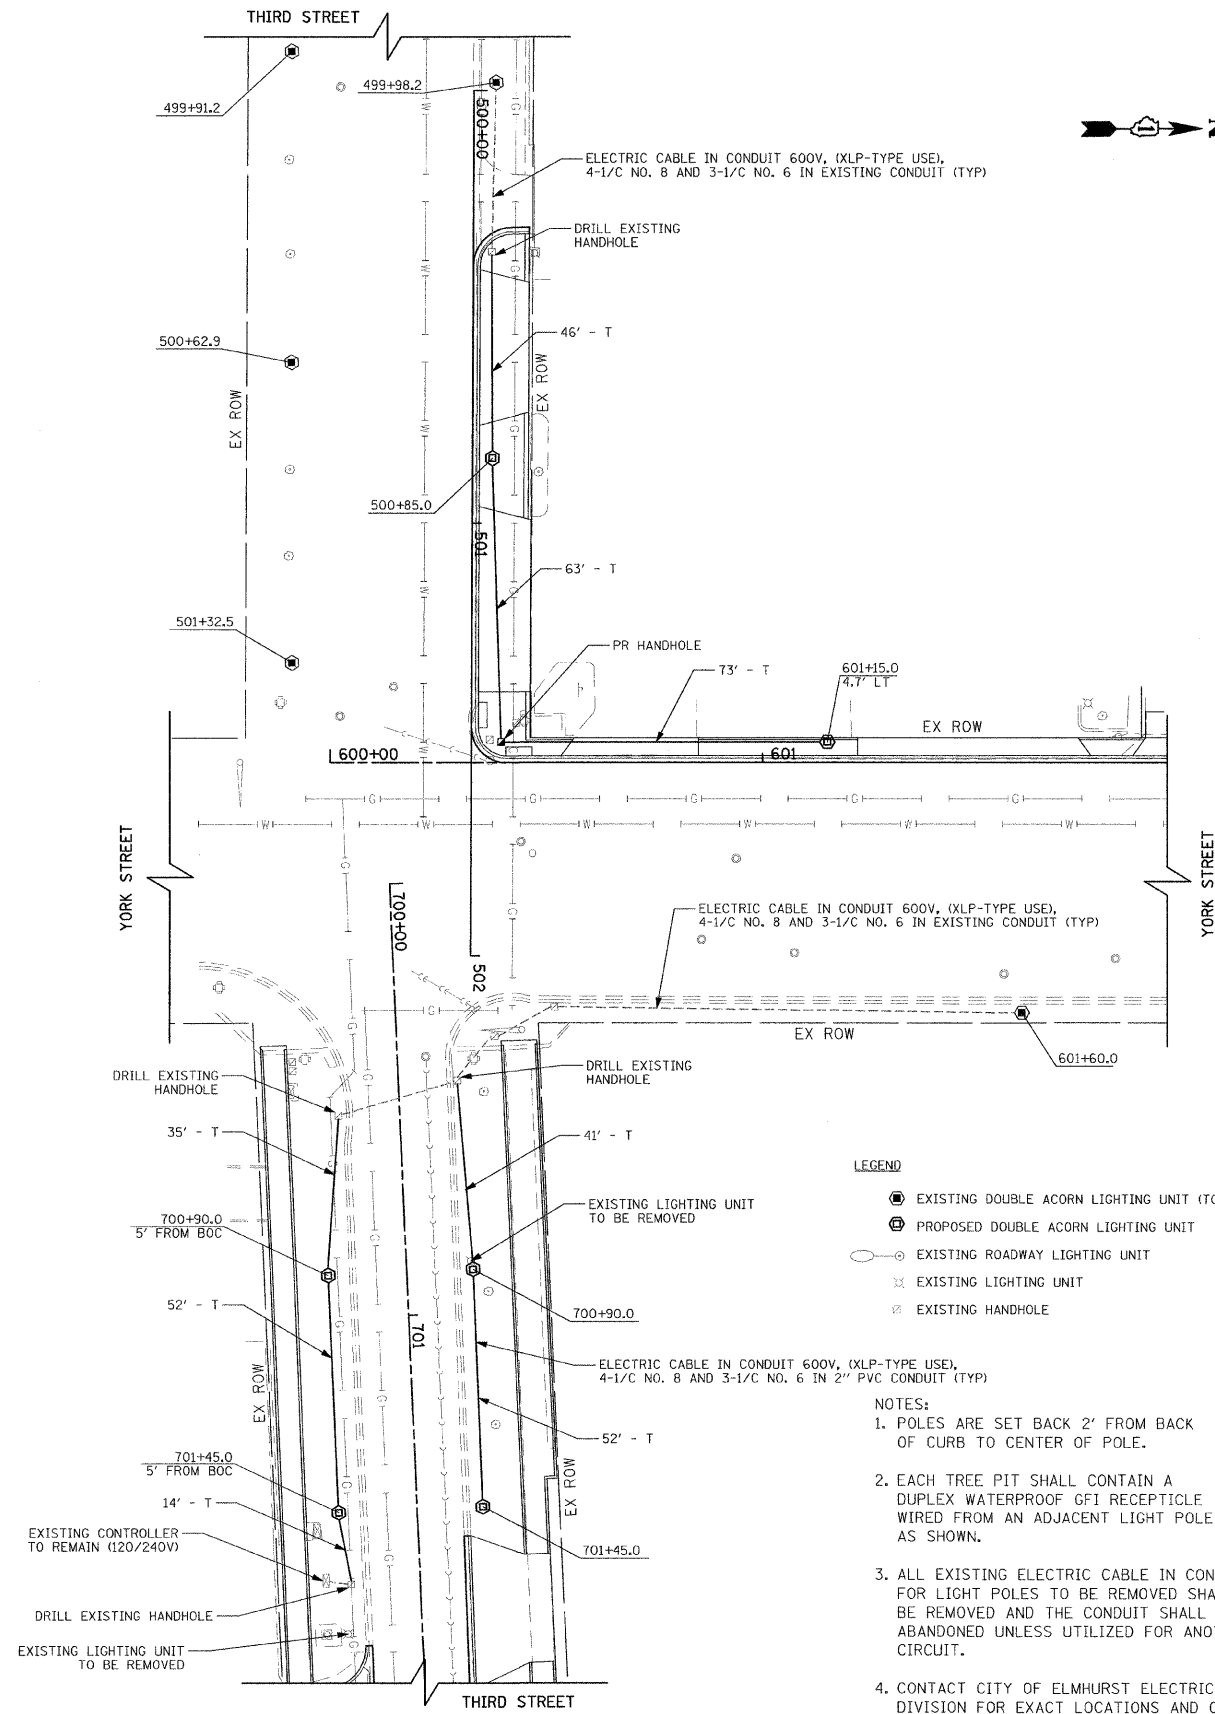

- LEGEND**
- ⊙ EXISTING DOUBLE ACORN LIGHTING UNIT (TO REMAIN)
  - ⊕ PROPOSED DOUBLE ACORN LIGHTING UNIT
  - EXISTING ROADWAY LIGHTING UNIT
  - ⊗ EXISTING LIGHTING UNIT
  - ⊘ EXISTING HANDHOLE

- NOTES:**
1. POLES ARE SET BACK 2' FROM BACK OF CURB TO CENTER OF POLE.
  2. EACH TREE PIT SHALL CONTAIN A DUPLEX WATERPROOF GFI RECEPTICLE WIRED FROM AN ADJACENT LIGHT POLE AS SHOWN.
  3. ALL EXISTING ELECTRIC CABLE IN CONDUIT FOR LIGHT POLES TO BE REMOVED SHALL BE REMOVED AND THE CONDUIT SHALL BE ABANDONED UNLESS UTILIZED FOR ANOTHER CIRCUIT.
  4. CONTACT CITY OF ELMHURST ELECTRICAL DIVISION FOR EXACT LOCATIONS AND CIRCUITS.

FILE NAME = gr:\odl\11\013\road\sheet\411011-281aht	USER NAME = ajpdxeter	DESIGNED - KB	REVISED -
		DRAWN - AJP	REVISED -
		CHECKED - ESN	REVISED -
		DATE - 11/16/2011	REVISED -

**STATE OF ILLINOIS  
DEPARTMENT OF TRANSPORTATION**

**ELMHURST STREETSCAPE ENHANCEMENTS  
LIGHTING PLAN  
THIRD STREET AND YORK STREET**

SCALE: 1"=20' SHEET NO. 3 OF 3 SHEETS STA. TO STA.

F.A.I.D. RTE.	SECTION	COUNTY	TOTAL SHEETS	SHEET NO.
2678/2676	11-00179-00-LS	DUPAGE	28	14
CONTRACT NO. 63652				
FED. ROAD DIST. NO. 7 ILLINOIS FED. AID PROJECT				