



DRAINAGE STRUCTURE SCHEDULE

NO.	LOCATION		TYPE	RIM ELEV	INVERT ELEVATION			
	STATION	OFFSET			(IN)	(IN)	(IN)	(OUT)
22	31+20	0.0	DR STR T4 W/2 T20F&G	785.11	781.04			780.77
23	32+94	0.0	DR STR T4 SPL W/2 T20F&G	784.52	780.10			779.58
24	32+94	110.0 LT	PRC FL END S EQ RS 18	-				778.94
25	34+68	0.0	DR STR T4 SPL W/2 T20F&G	784.00				778.64
26	34+68	99.8 LT	PRC FL END S EQ RS 18	-				778.38
27	36+42	0.0	DR STR T4 W/2 T20F&G	783.48				778.10
28	36+42	90.6 LT	PRC FLAR END SEC 18	-				777.87
29	38+16	0.0	DR STR T4 W/2 T20F&G	782.95				777.58
30	38+16	90.5 LT	PRC FLAR END SEC 18	-				777.35
31	39+90	0.0	DR STR T4 W/2 T20F&G	782.43				777.06
32	39+90	90.7 LT	PRC FLAR END SEC 18	-				776.83
33	42+00	0.0	DR STR T4 W/2 T20F&G	781.80				777.10
34	42+00	96.7 LT	PRC FLAR END SEC 18	-				776.26
35	44+50	0.0	DR STR T4 W/2 T20F&G	781.05				776.35
36	44+50	96.7 LT	PRC FLAR END SEC 18	-				775.51

STORM SEWERS SCHEDULE

SEWER NO.	TYPE	SIZE (INCH)	LENGTH (FEET)	SLOPE (%)
15	STORM SEW CL A 1	15	163.0	0.40%
16	STORM SEW CL A 1	18	166.5	0.40%
17	SS CL A 1 EQRS 18	23 X14	100.5	0.60%
18	SS CL A 1 EQRS 18	23 X14	90.3	0.27%
19	STORM SEW CL A 1	18	81.0	0.26%
20	STORM SEW CL A 1	18	80.9	0.26%
21	STORM SEW CL A 1	18	81.1	0.26%
22	STORM SEW CL A 2	18	87.1	0.90%
23	STORM SEW CL A 2	18	87.1	0.90%

RICHARDSON DEVELOPMENT LLC

DYN RESIDENTIAL HOLDINGS LLC


SEE SHEET 100 FOR RAMP C DRAINAGE INFORMATION

LEGEND

- DRAINAGE STRUCTURES
- STORM SEWERS

UNDERDRAIN CONNECTION NOTE:

CONTRACTOR SHALL CONNECT THE PROPOSED PIPE UNDERDRAIN (OF DIAMETER SPECIFIED) TO THE PROPOSED INLET AT AN ELEVATION OF 2.50' BELOW THE RIM ELEVATION OF THE INLET BEING CONNECTED TO. THIS WORK SHALL BE IN ACCORDANCE WITH SECTION 601 OF THE STATE STANDARDS AND STATE STANDARD 601001-04 AND SHALL BE INCLUDED IN THE PAY ITEM PIPE UNDERDRAINS OF THE DIAMETER SPECIFIED OR THE KIND OF MATERIAL AND DIAMETER SPECIFIED.

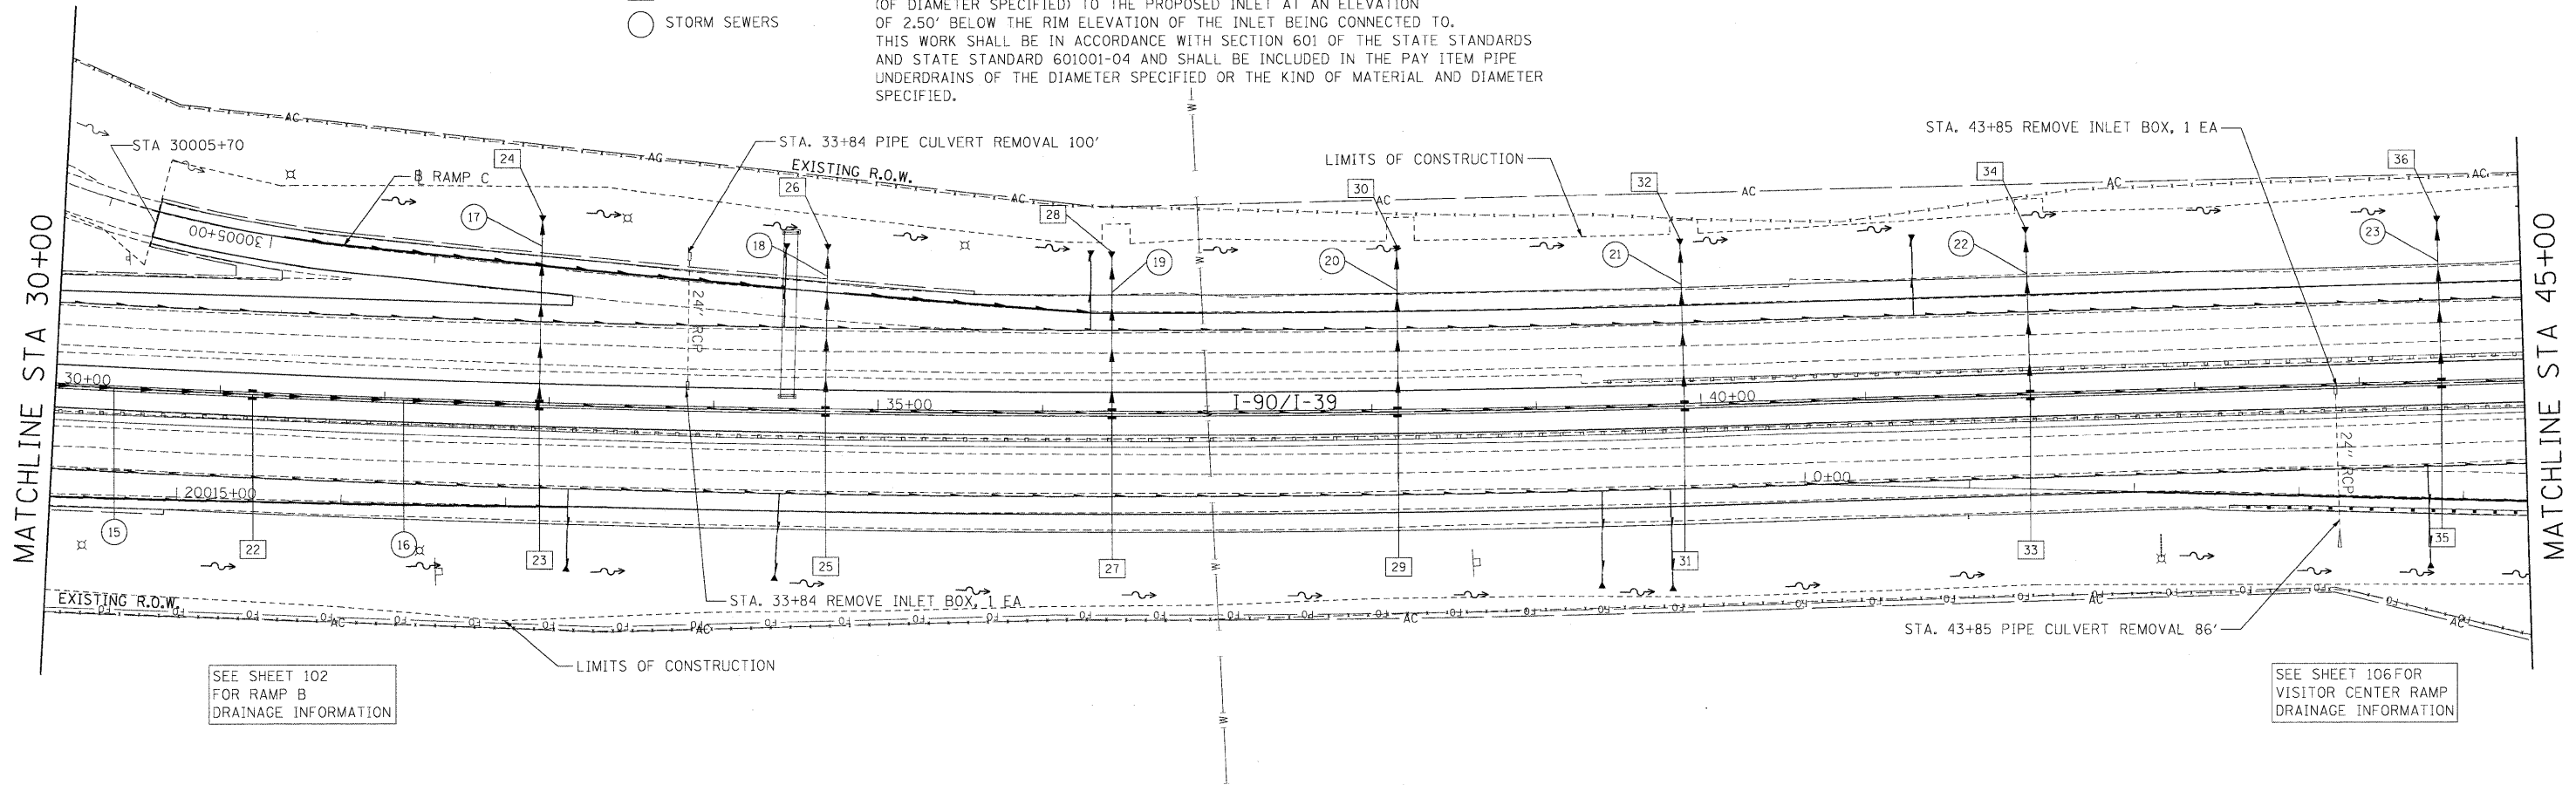


SEE SHEET 102 FOR RAMP B DRAINAGE INFORMATION

SEE SHEET 106 FOR VISITOR CENTER RAMP DRAINAGE INFORMATION

GERONIMO DEVELOPMENT LLC

RICHARDSON DEVELOPMENT LLC

 RICHARDSON DEVELOPMENT LLC



	USER NAME = .USERNAME.	DESIGNED - DA	REVISED -	<p align="center">STATE OF ILLINOIS DEPARTMENT OF TRANSPORTATION</p>	<p align="center">I-90 DRAINAGE PLANS</p>	F.A.I. RTE. 90	SECTION (X2-1)R	COUNTY WINNEBAGO	TOTAL SHEETS 510	SHEET NO. 233
		PLOT SCALE = 50.0000' / IN.	CHECKED - AM			REVISED -	SCALE:	SHEET NO. OF SHEETS	STA. 30+00 TO STA. 45+00	CONTRACT NO. 64C29
	PLOT DATE = 10/19/2011	DATE - 10/14/2011	REVISED -							