




SEE SHEET 264 FOR CONTINUATION OF ENTRANCE RAMP TEMPORARY LIGHTING

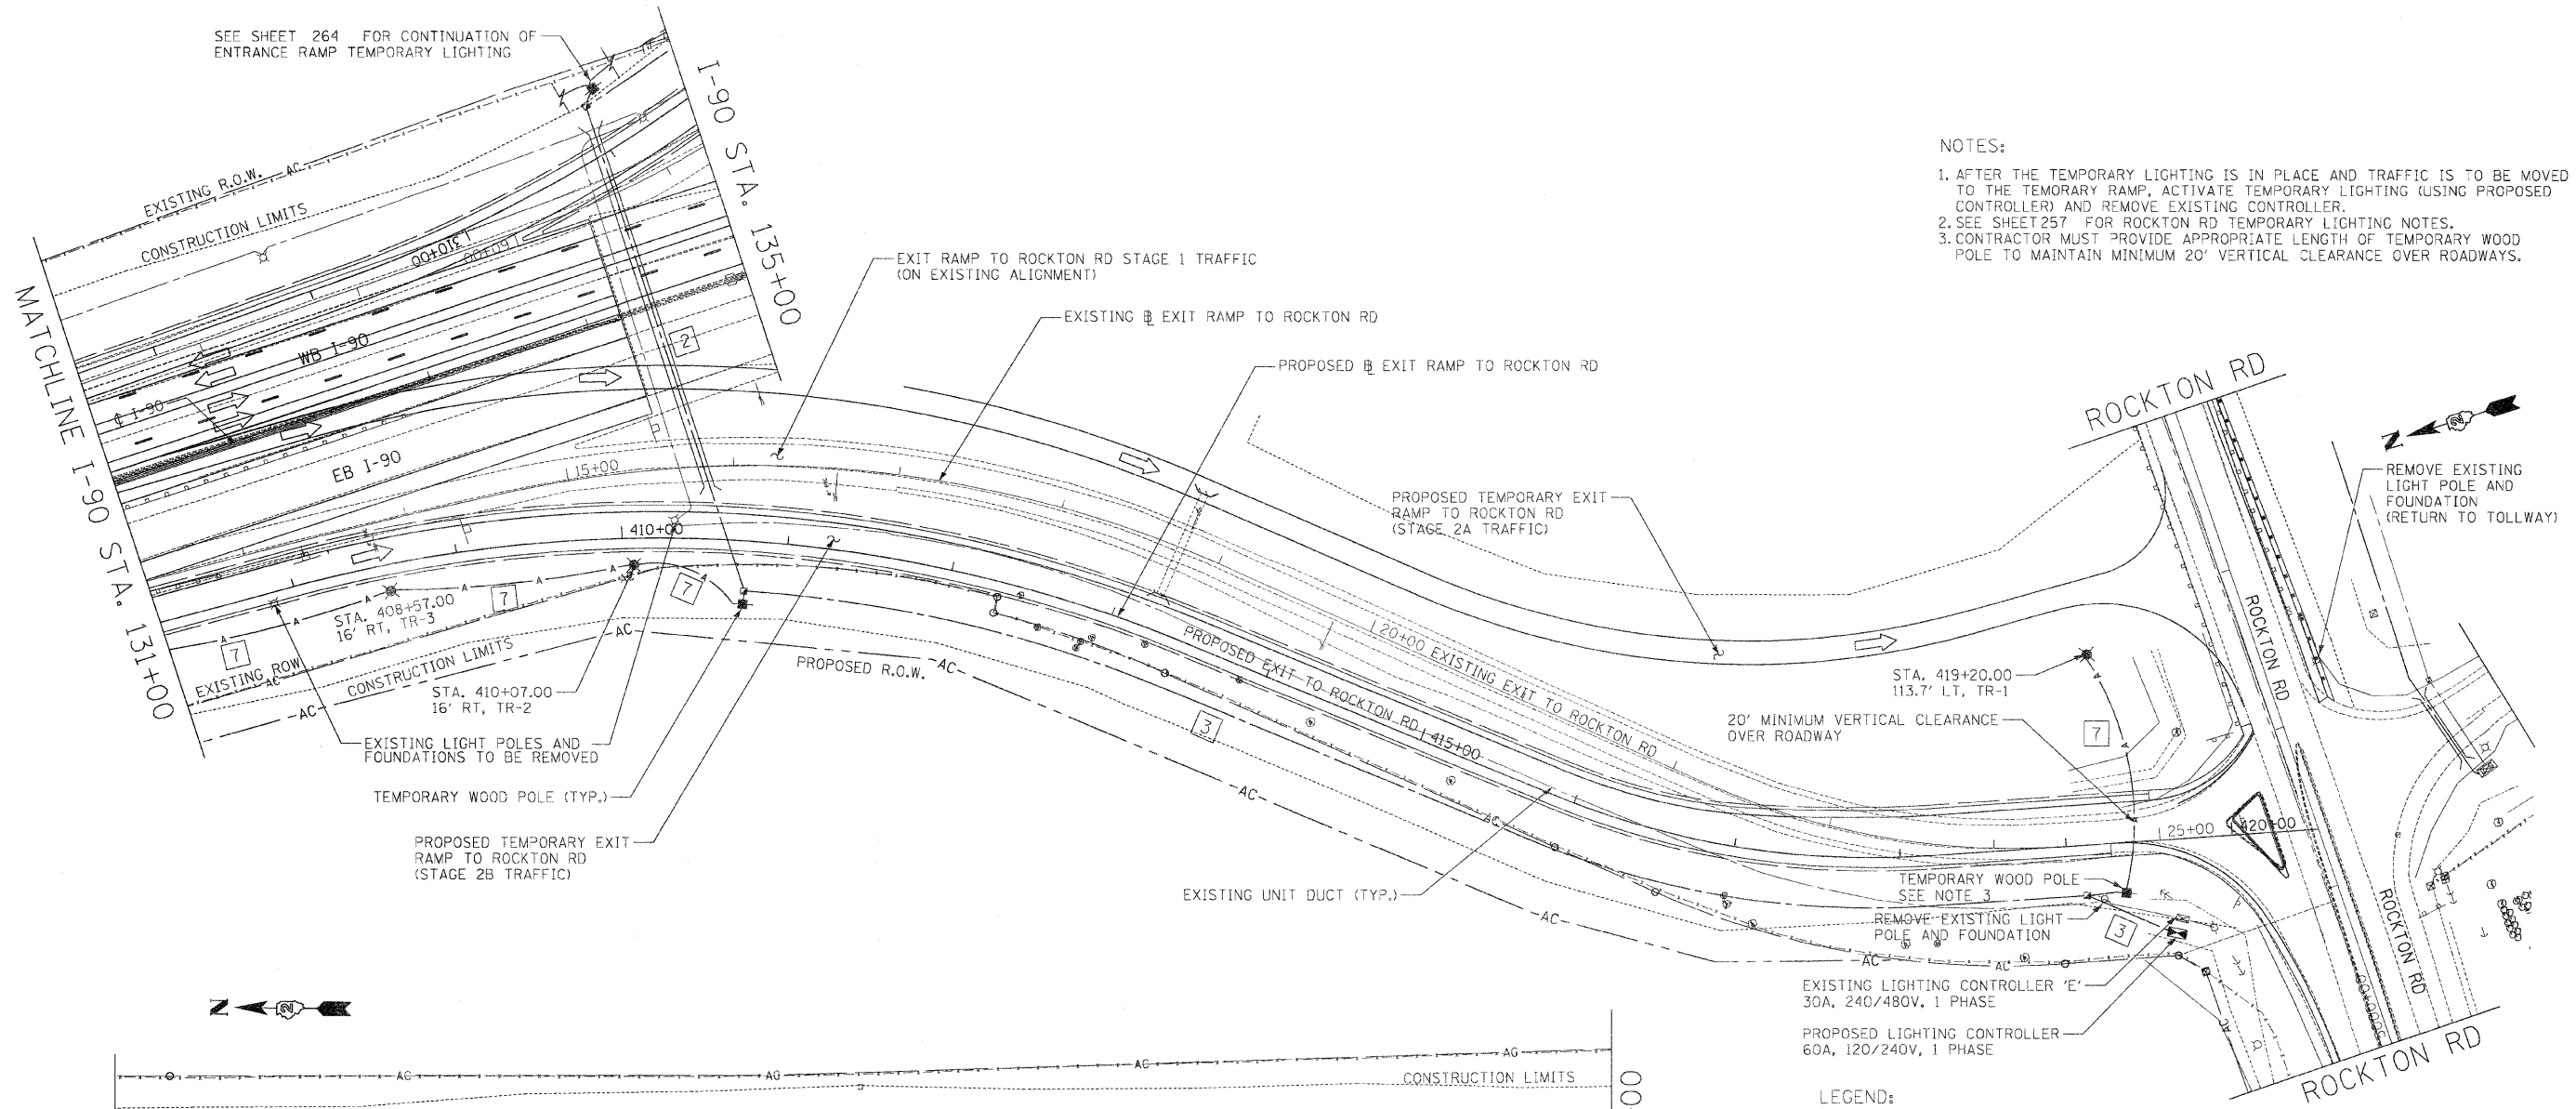

- NOTES:
1. AFTER THE TEMPORARY LIGHTING IS IN PLACE AND TRAFFIC IS TO BE MOVED TO THE TEMPORARY RAMP, ACTIVATE TEMPORARY LIGHTING (USING PROPOSED CONTROLLER) AND REMOVE EXISTING CONTROLLER.
 2. SEE SHEET 257 FOR ROCKTON RD TEMPORARY LIGHTING NOTES.
 3. CONTRACTOR MUST PROVIDE APPROPRIATE LENGTH OF TEMPORARY WOOD POLE TO MAINTAIN MINIMUM 20' VERTICAL CLEARANCE OVER ROADWAYS.

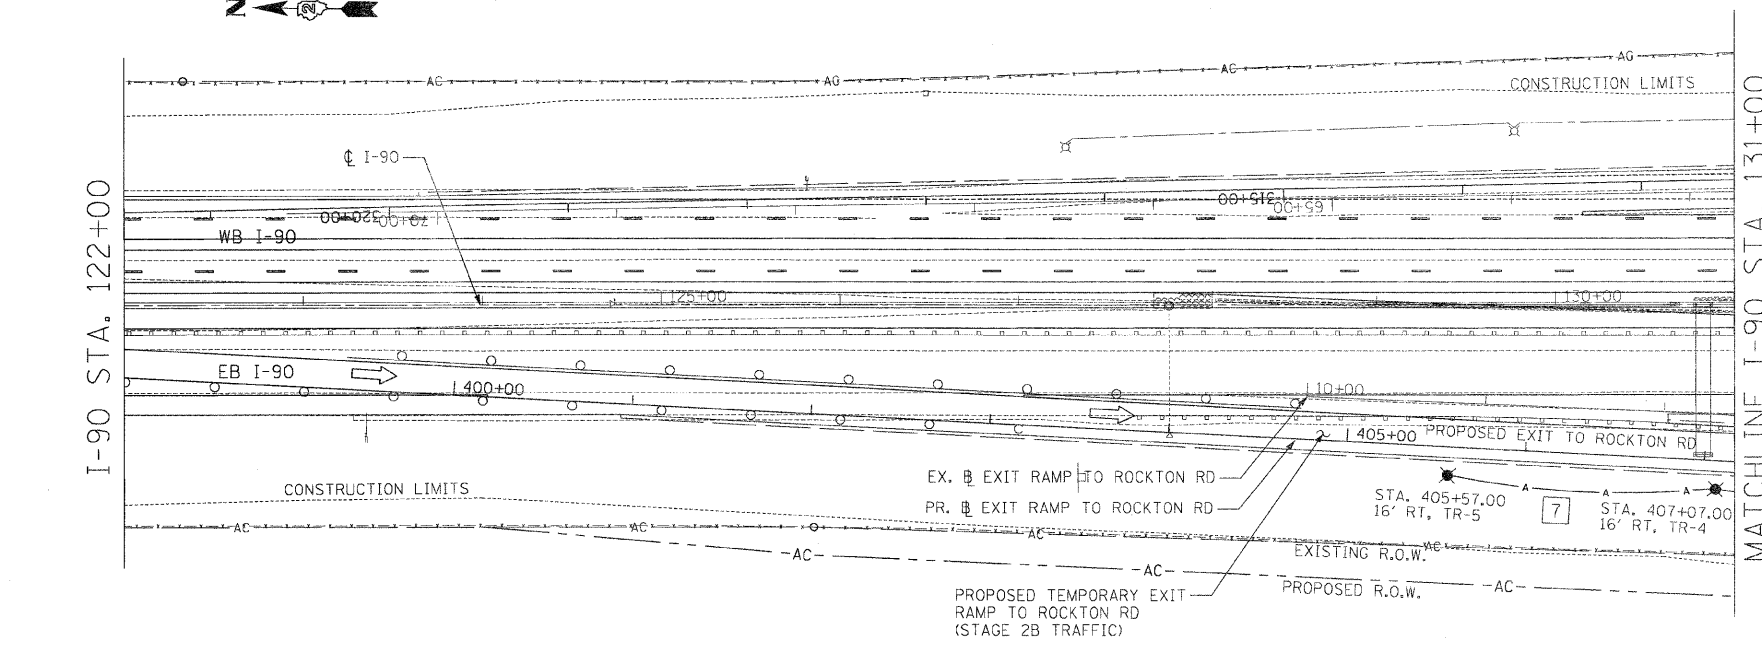

 - LEGEND:
- EXISTING UNIT DUCT
 - PROPOSED TEMPORARY LIGHTING AERIAL CABLE
 - ⊗ EXISTING LIGHT POLE TO REMAIN UNLESS NOTED OTHERWISE
 - ⊗ EXISTING LIGHTING CONTROLLER
 - ⊗ PROPOSED LIGHTING CONTROLLER
 - ⊗ PROPOSED TEMPORARY LIGHT POLE, WOOD, 45 FT. M.H. TENON MOUNT WITH (1) 250W HPS VAPOR FIXTURE
 - ⊗ PROPOSED TEMPORARY WOOD POLE, 40 FT., CLASS 4
 - ⊗ PROPOSED HAND HOLE
 - 1 UNIT DUCT, 600V, 2-1C NO.6, 1/C NO.6 GROUND, (XLP-TYPE USE), 1" DIA. POLYETHYLENE
 - 2 UNIT DUCT, 600V, 2-1C NO.2, 1/C NO.2 GROUND, (XLP-TYPE USE), 1 1/4" DIA. POLYETHYLENE
 - 3 UNIT DUCT, 600V, 4-1C NO.2, 1C NO.4 GROUND, (XLP-TYPE USE), 1 1/2" DIA. POLYETHYLENE
 - 7 AERIAL CABLE, 2-1/C NO.6 WITH MESSENGER WIRE
 - CONDUIT PUSHED, 4" DIA., PVC SCHEDULE 80 (PAID AS UNDERGROUND CONDUIT, PVC, 4" DIA.)



	USER NAME = _USERNAME_	DESIGNED - BLM	REVISED -	STATE OF ILLINOIS DEPARTMENT OF TRANSPORTATION	TEMPORARY LIGHTING PLAN ROCKTON RD EXIT RAMP	F.A.I. RTE. 90	SECTION (K2-1R)	COUNTY WINNEBAGO	TOTAL SHEETS 510	SHEET NO. 263
	PLOT SCALE = 50.0000' / IN.	CHECKED - BLM	DATE - 10/14/11			REVISED -	CONTRACT NO. 64C29	(ILLINOIS) FED. AID PROJECT		