

 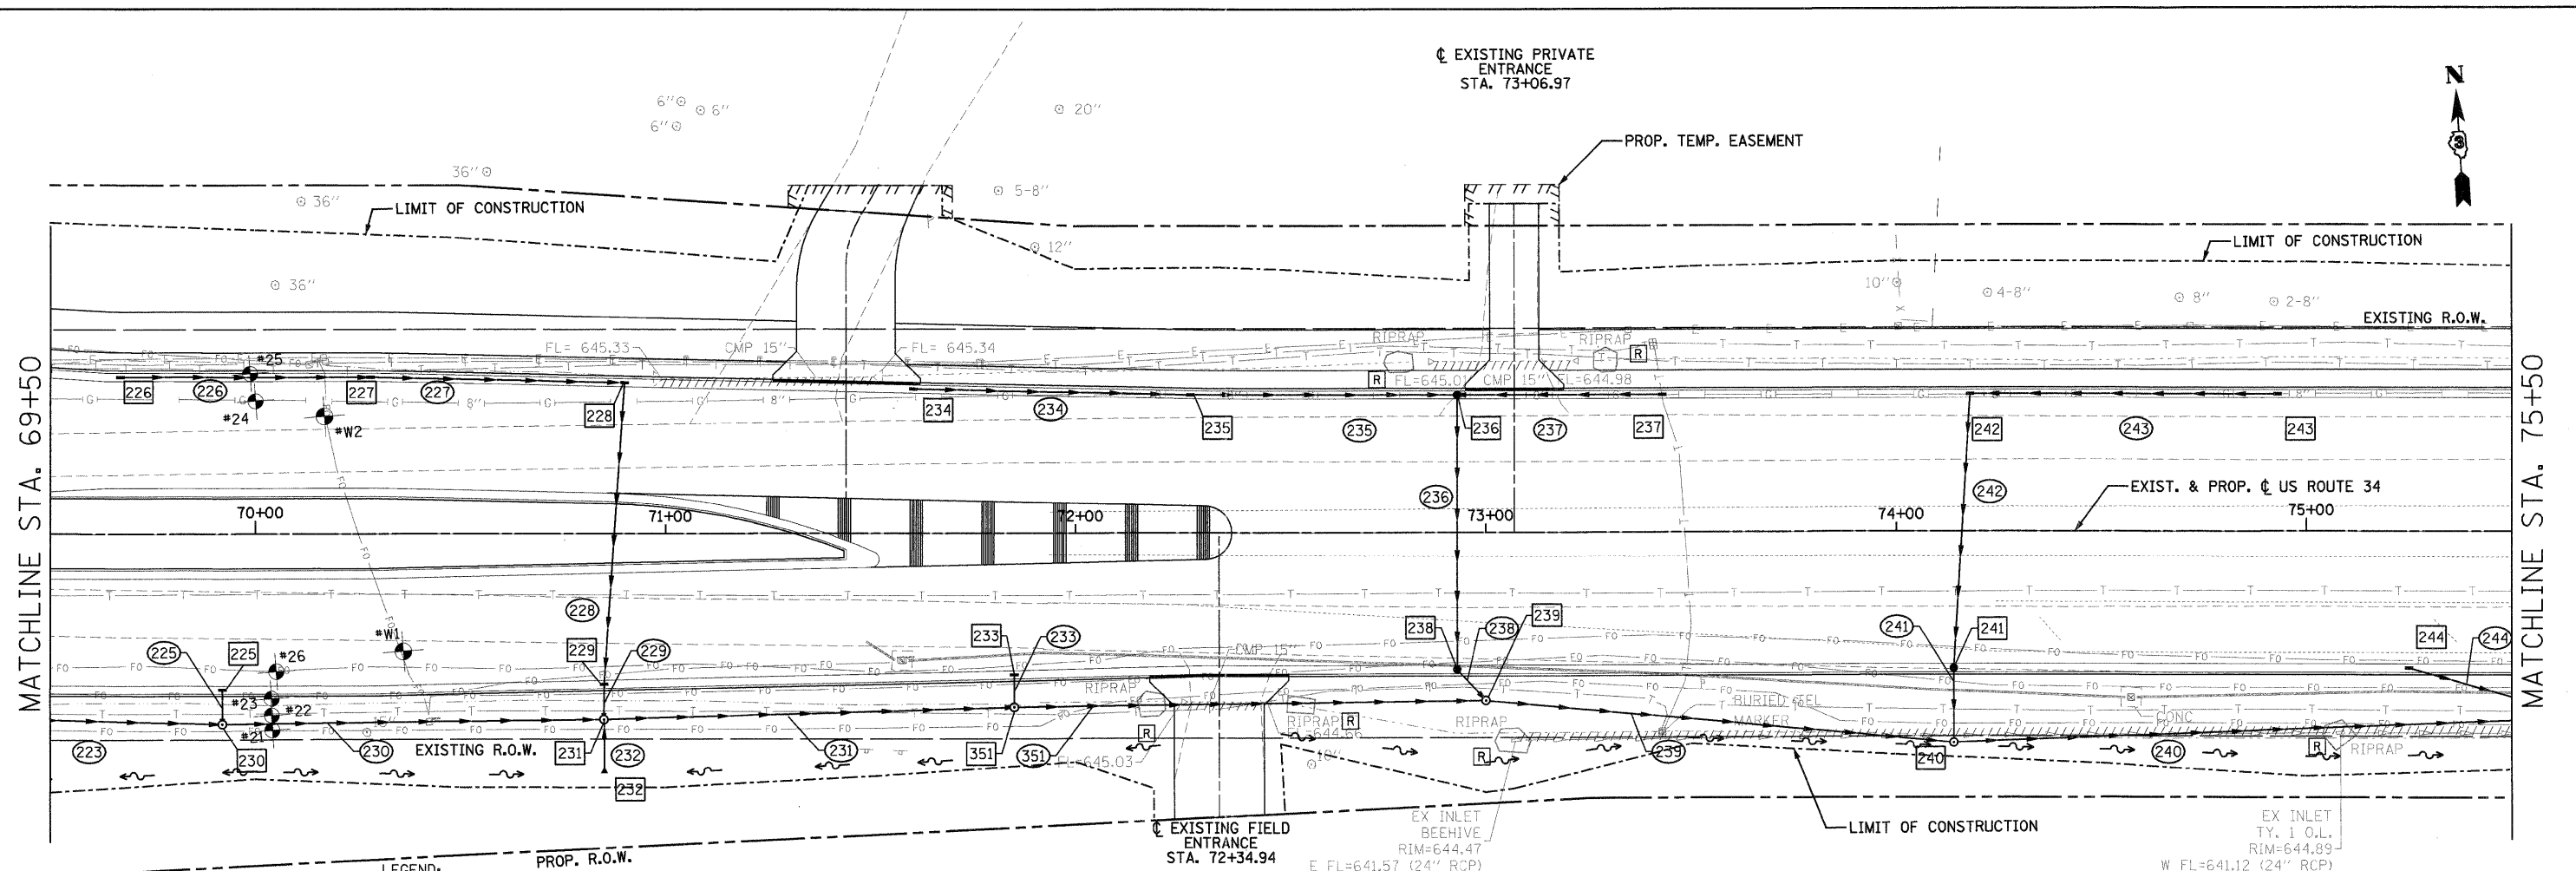


| | | |
|------|--------------------|------|
| PLAN | SURVEYED | DATE |
| | PLOTTED | |
| | CHECKED | |
| | BY | |
| | NO. OF WAY CHECKED | |
| | PAID FILE NAME | |

| | | |
|---------|--------------------|------|
| PROFILE | SURVEYED | DATE |
| | PLOTTED | |
| | CHECKED | |
| | BY | |
| | NO. OF WAY CHECKED | |
| | NOTATIONS CHKD | |

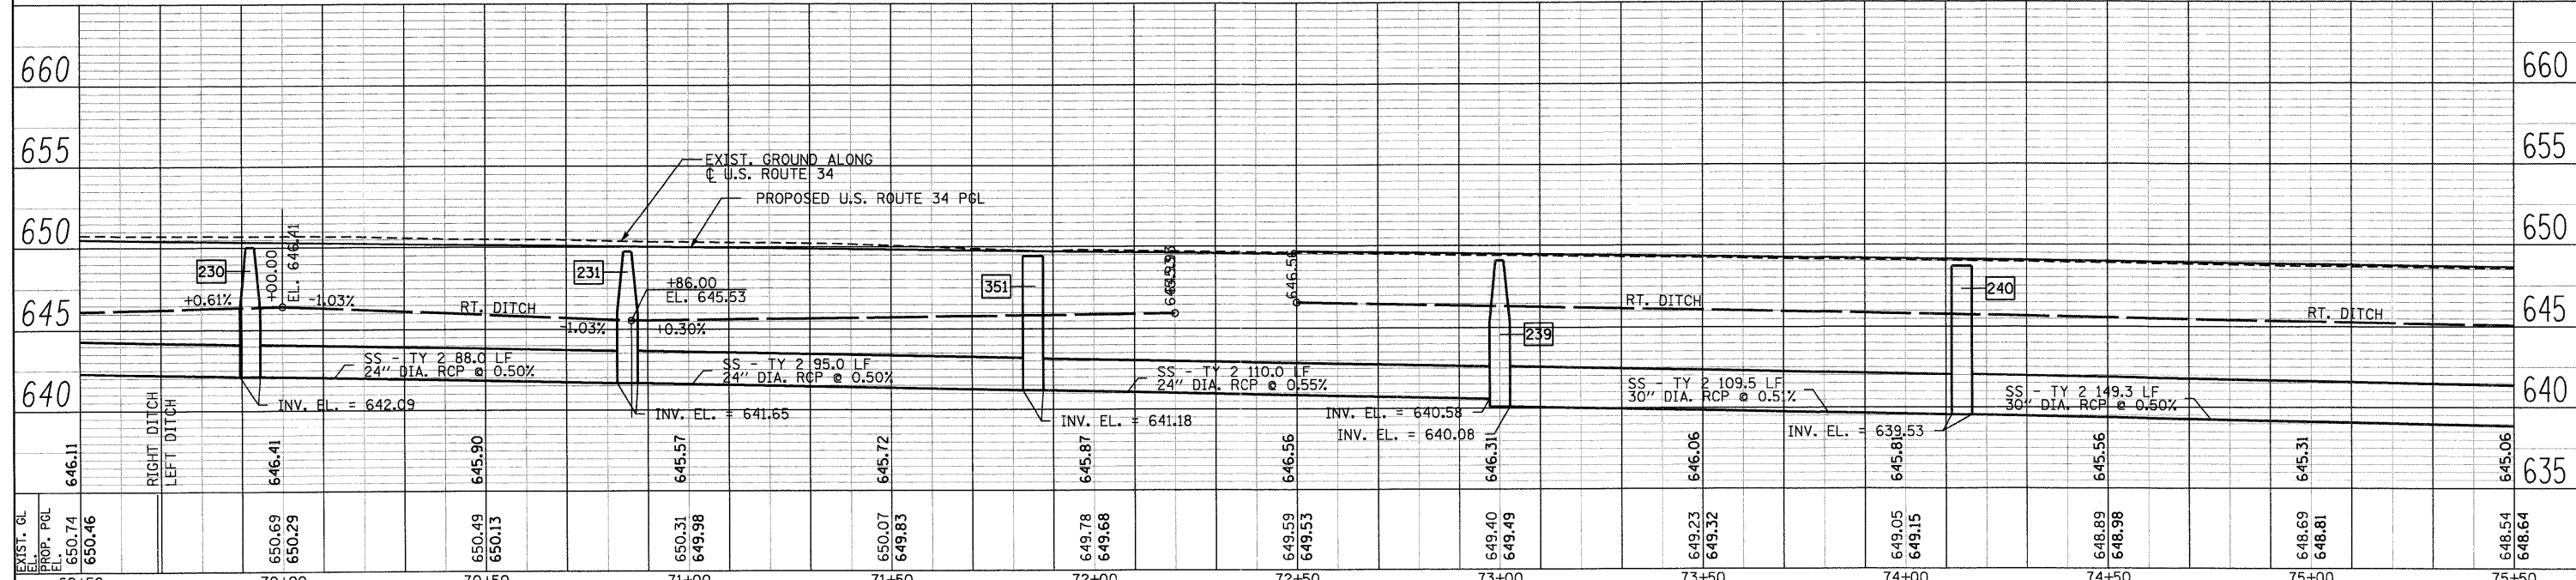

- LEGEND:**
- XXX STRUCTURE NUMBER
 - XXX PIPE NUMBER
 - ~ PROPOSED DITCH
 - //// PIPE TO BE REMOVED
 - PROPOSED CATCH BASIN
 - PROPOSED INLET
 - PROPOSED MANHOLE
 - PROPOSED STORM SEWER
 - PROPOSED UNDERDRAINS
 - ◁ PROPOSED CONCRETE HEADWALL FOR PIPE DRAIN
 - EXISTING CATCH BASIN
 - EXISTING INLET
 - EXISTING MANHOLE
 - EXISTING STORM SEWER
 - ⊙ ADJUST FRAME AND LID
 - ⊙ ADJUST FRAME AND GRATE
 - ⊙ STRUCTURE TO BE REMOVED
 - ⊙ ITEM TO BE ABANDONED
 - ⊙ UTILITY TEST HOLE (S.U.E.)



| | | | | | | | | | | | |
|---|-------------------------------------|-------------------|-----------|---|--|---------------------------|-------------|---------|---------------------------|--------------|-----------|
| PB Americas, Inc. 230 WEST MONROE STREET, SUITE 900 CHICAGO, IL 60606 (312)782-8150 | FILE NAME = D366985-shr-12drain.dgn | DESIGNED - RJD | REVISED - | STATE OF ILLINOIS DEPARTMENT OF TRANSPORTATION | DRAINAGE PLAN & PROFILE US ROUTE 34 | | F.A.P. RTE. | SECTION | COUNTY | TOTAL SHEETS | SHEET NO. |
| | PLOT SCALE = | DRAWN - RJD | REVISED - | | 591 | 13R-214R-1 & BR-1(1)15R-1 | KENDALL | 429 | 175 | | |
| | PLOT DATE = 19-AUG-2011 08:21 | CHECKED - PMK | REVISED - | | FINAL SUBMITTAL | | | | CONTRACT NO. 66985 | | |
| | DATE = 08-18-2011 | DATE = 08-18-2011 | REVISED - | | SCALE: AS SHOWN DRNG - 12 OF 28 STA. 69+00 TO STA. 75+00 | | | | ILLINOIS FED. AID PROJECT | | |