


DATE	
BY	
PLAN	SURVEYED
	PLOTTED
	CHECKED
	NO. OF WAY CHECKED
	CADD FILE NAME
	NO.

DATE	
BY	
PROFILE	SURVEYED
	PLOTTED
	CHECKED
	GRADES CHECKED
	STRUCTURE NOTATIONS CHKD
	NO.



MATCHLINE STA. 87+50

MATCHLINE STA. 93+50

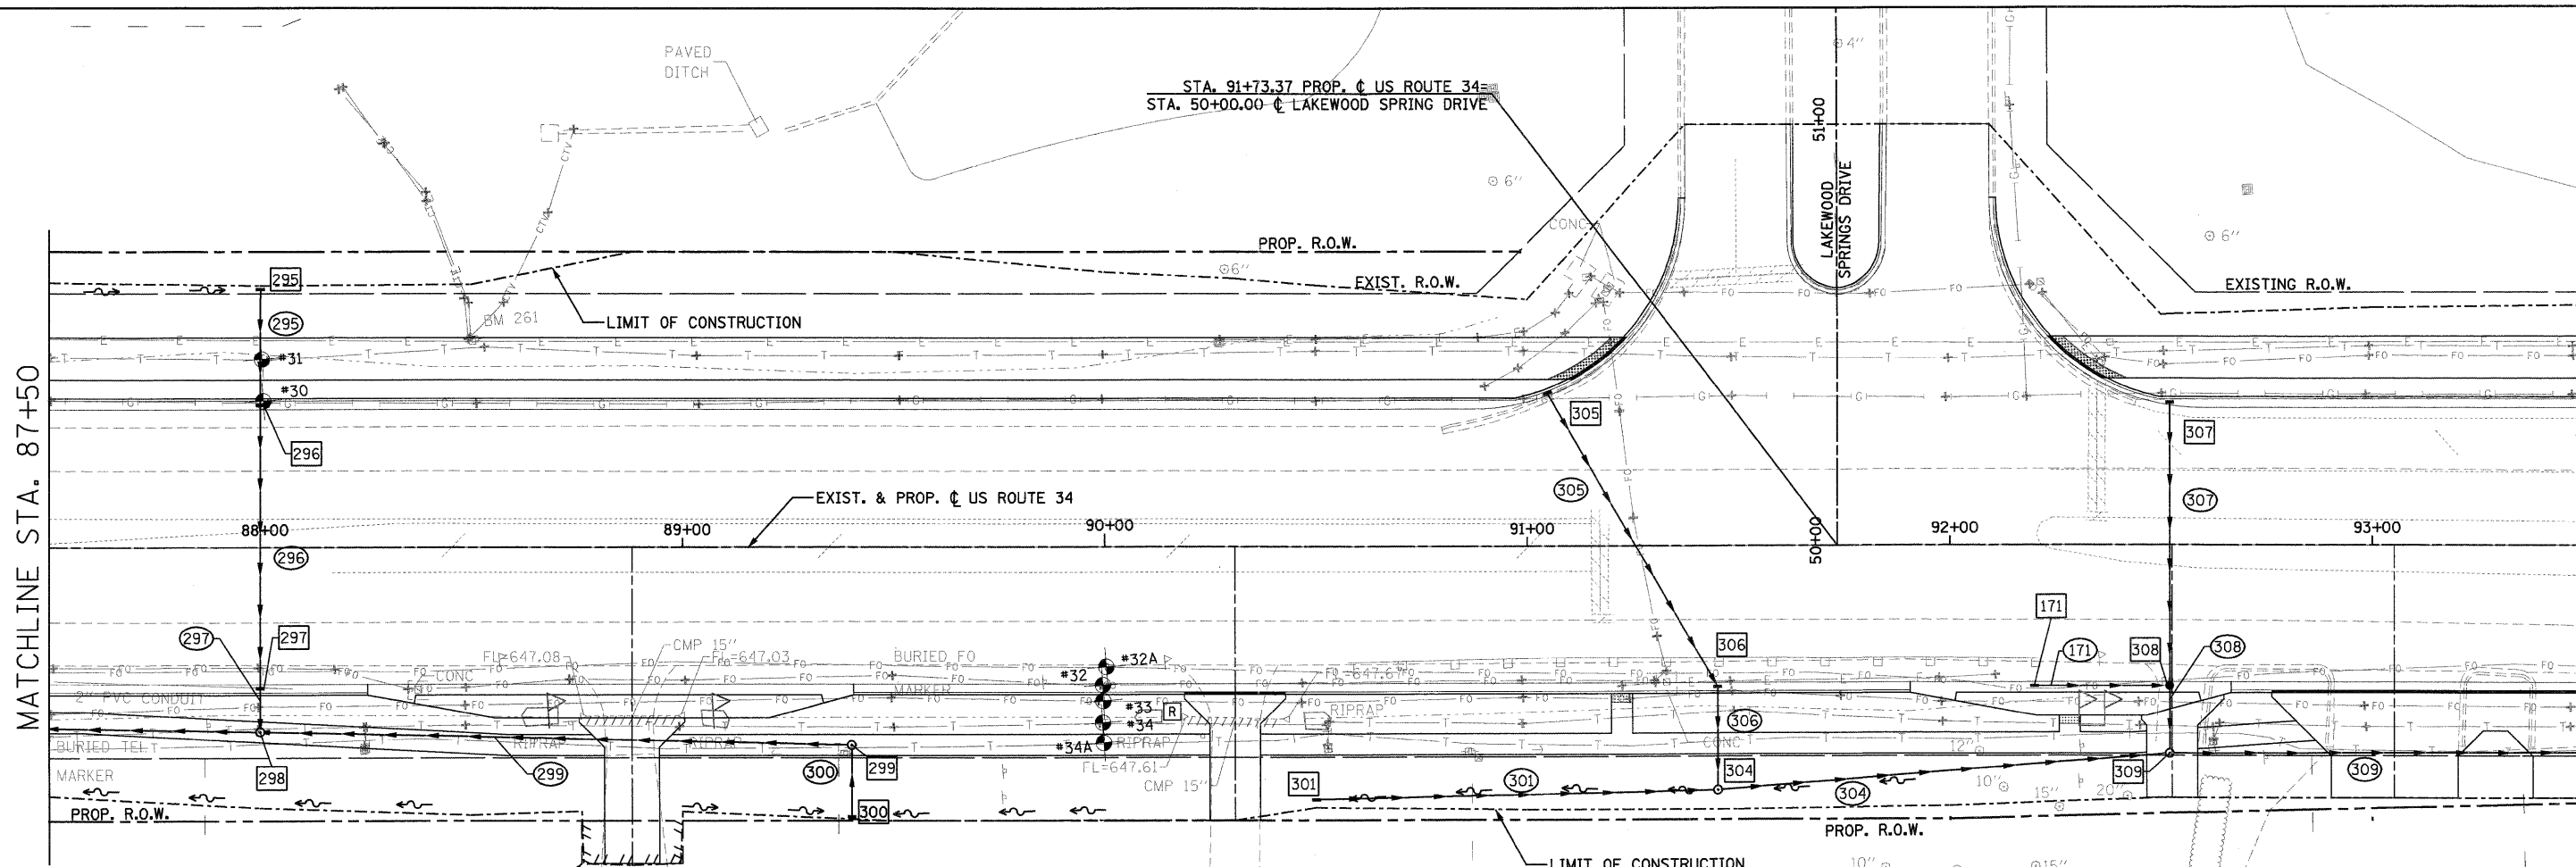

LEGEND:

XXX	STRUCTURE NUMBER	●	PROPOSED CATCH BASIN	○	EXISTING CATCH BASIN	⊗	ADJUST FRAME AND LID
XXX	PIPE NUMBER	■	PROPOSED INLET	□	EXISTING INLET	⊠	ADJUST FRAME AND GRATE
—	PROPOSED DITCH	○	PROPOSED MANHOLE	○	EXISTING MANHOLE	⊠	STRUCTURE TO BE REMOVED
////	PIPE TO BE REMOVED	—	PROPOSED STORM SEWER	—	EXISTING STORM SEWER	⊠	ITEM TO BE ABANDONED
		—	PROPOSED UNDERDRAINS	⊠	UTILITY TEST HOLE (S.U.E.)		
		⊠	PROPOSED CONCRETE HEADWALL FOR PIPE DRAIN				

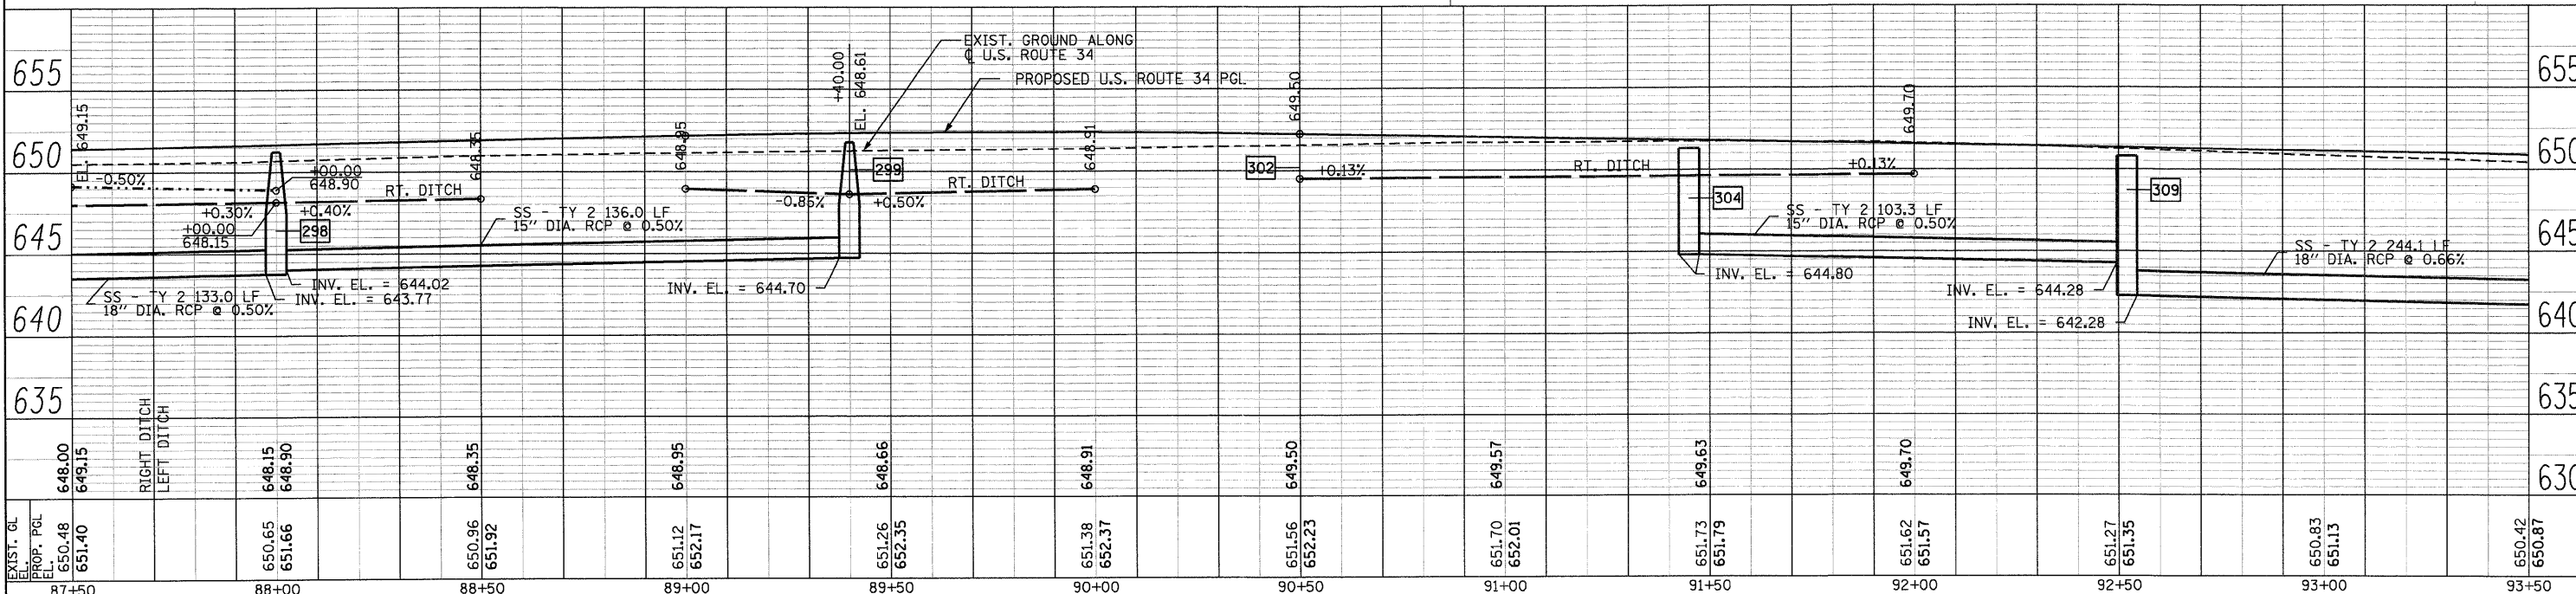 

EXIST. G.L. PROP. PGL EL.	648.00 648.15	648.15 648.90	648.35 648.90	648.35 648.95	648.95 648.95	648.65 648.65	648.91 648.91	649.50 649.50	649.57 649.57	649.63 649.63	649.70 649.70	649.70 649.70	651.27 651.35	650.83 651.13	650.42 650.87
87+50	88+00	88+50	89+00	89+50	90+00	90+50	91+00	91+50	92+00	92+50	93+00	93+50			

FILE NAME = D366985-shr-15dra-rindgn
 DESIGNED - RJD
 DRAWN - RJD
 CHECKED - PMK
 DATE - 08-18-2011

REVISIONS
 REVISED -
 REVISED -
 REVISED -
 REVISED -

STATE OF ILLINOIS
 DEPARTMENT OF TRANSPORTATION

DRAINAGE PLAN & PROFILE
 US ROUTE 34
 SCALE: AS SHOWN DRNG - 15 OF 28 STA. 87+50 TO STA. 93+50

F.A.P. RTE.	SECTION	COUNTY	TOTAL SHEETS	SHEET NO.
591	13R-2:14R-1 & BR-1(1):15R-1	KENDALL	429	178
FINAL SUBMITTAL			CONTRACT NO. 66985	
ILLINOIS FED. AID PROJECT				

PR
 230 WEST MONROE STREET,
 SUITE 900
 CHICAGO, IL 60606
 (312)782-8150