 




DATE	
BY	
PLAN	
SURVEYED	
PLOTTED	
GRADES CHECKED	
STRUCTURE NOTATION	
NO.	
FILE NAME	

DATE	
BY	
PROFILE	
SURVEYED	
PLOTTED	
GRADES CHECKED	
STRUCTURE NOTATION	
NO.	
FILE NAME	

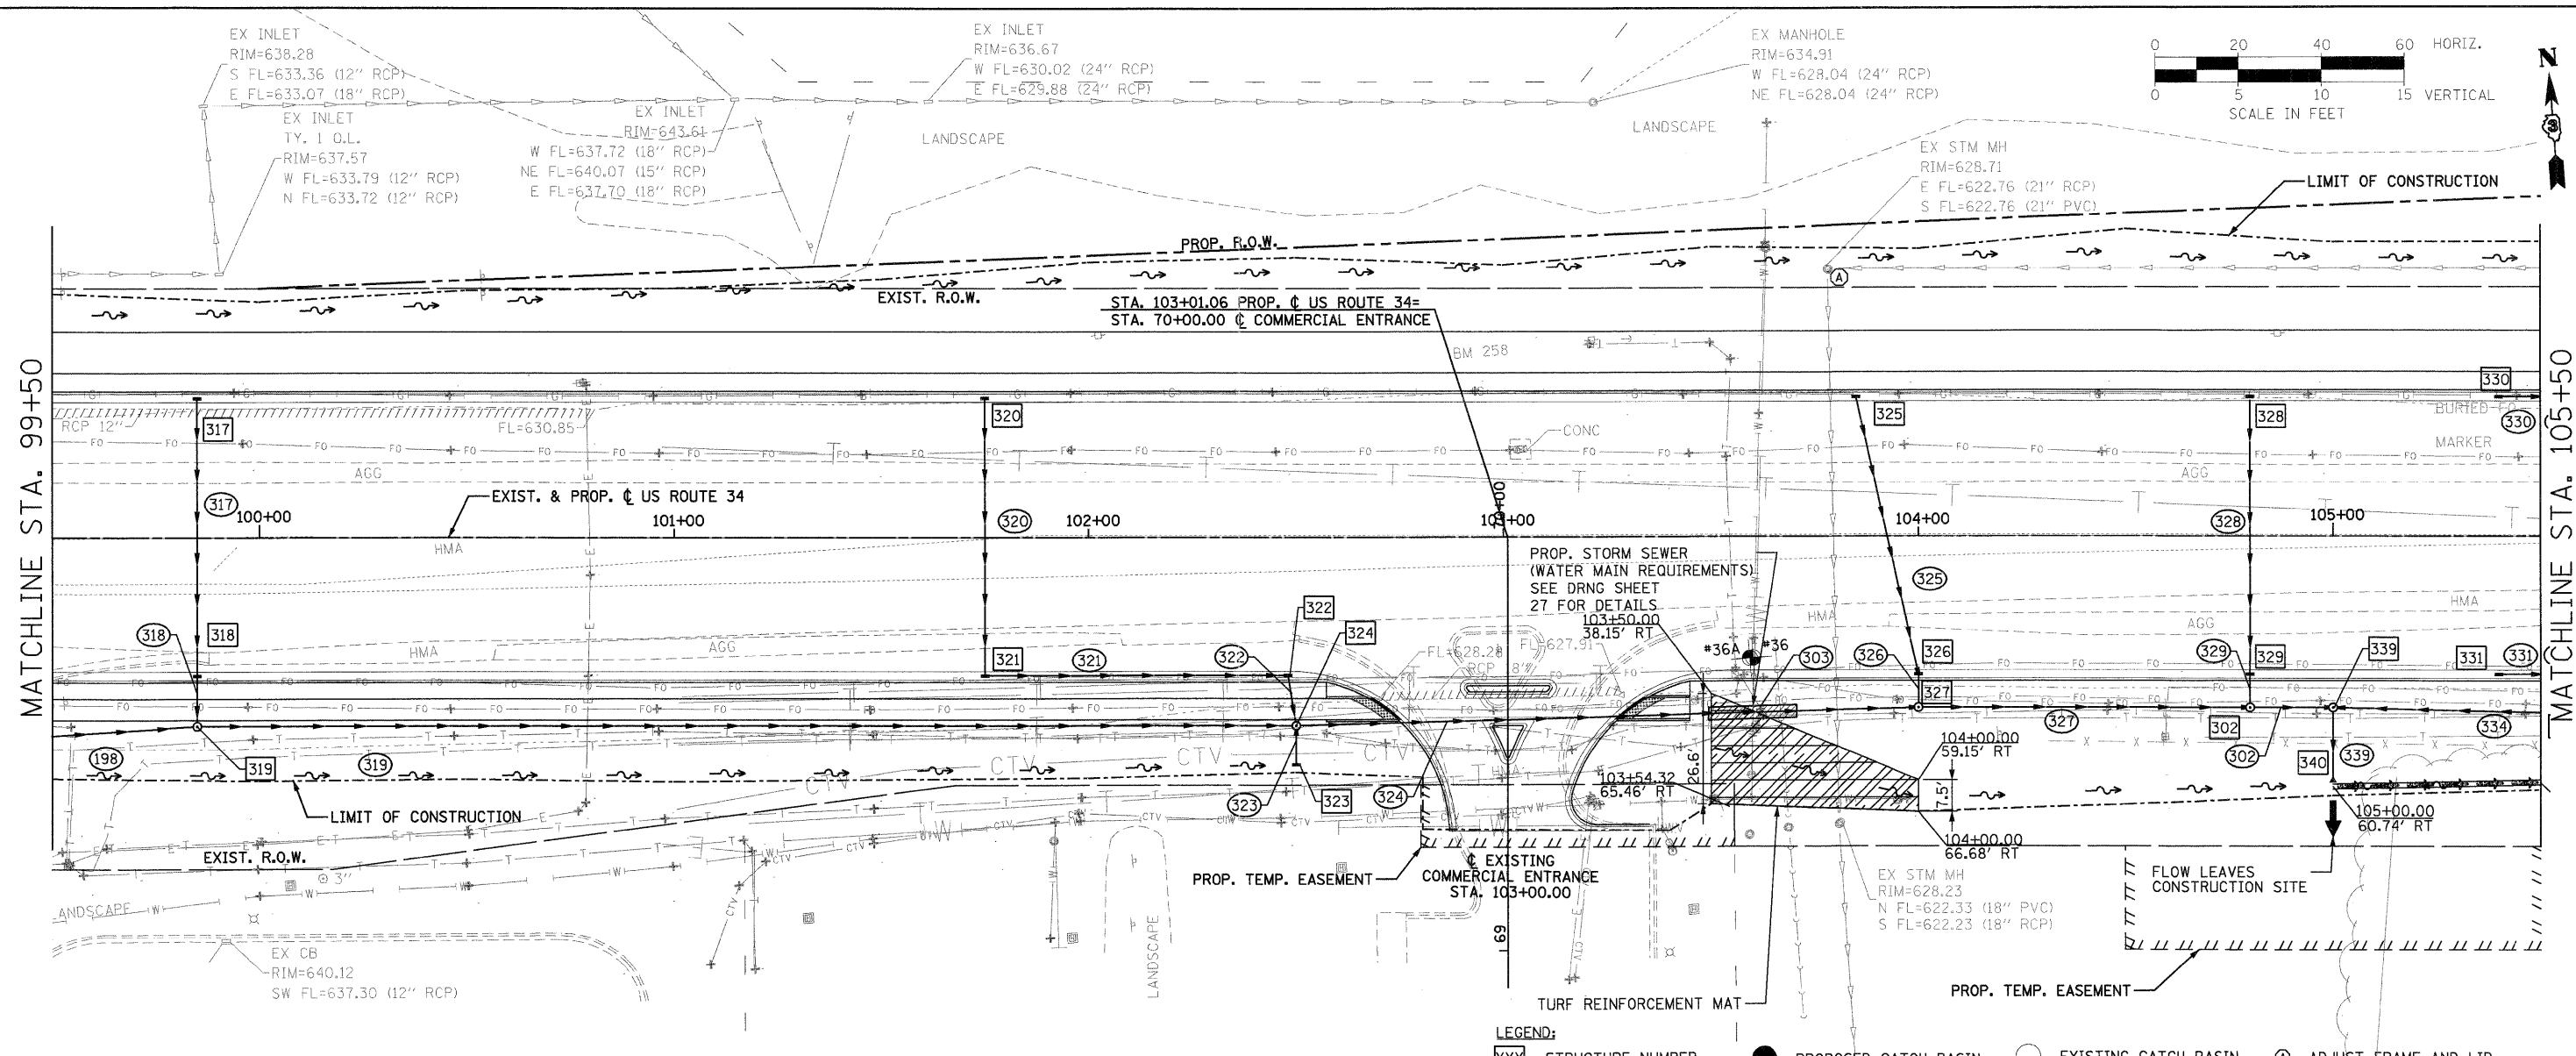

- LEGEND:
- XXX STRUCTURE NUMBER
  - XXX PIPE NUMBER
  - PROPOSED DITCH
  - PIPE TO BE REMOVED
  - PROPOSED UNDERDRAINS
  - PROPOSED CATCH BASIN
  - PROPOSED INLET
  - PROPOSED MANHOLE
  - PROPOSED STORM SEWER
  - UTILITY TEST HOLE (S.U.E.)
  - EXISTING CATCH BASIN
  - EXISTING INLET
  - EXISTING MANHOLE
  - EXISTING STORM SEWER
  - PROPOSED CONCRETE HEADWALL FOR PIPE DRAIN
  - ADJUST FRAME AND LID
  - ADJUST FRAME AND GRATE
  - STRUCTURE TO BE REMOVED
  - ITEM TO BE ABANDONED

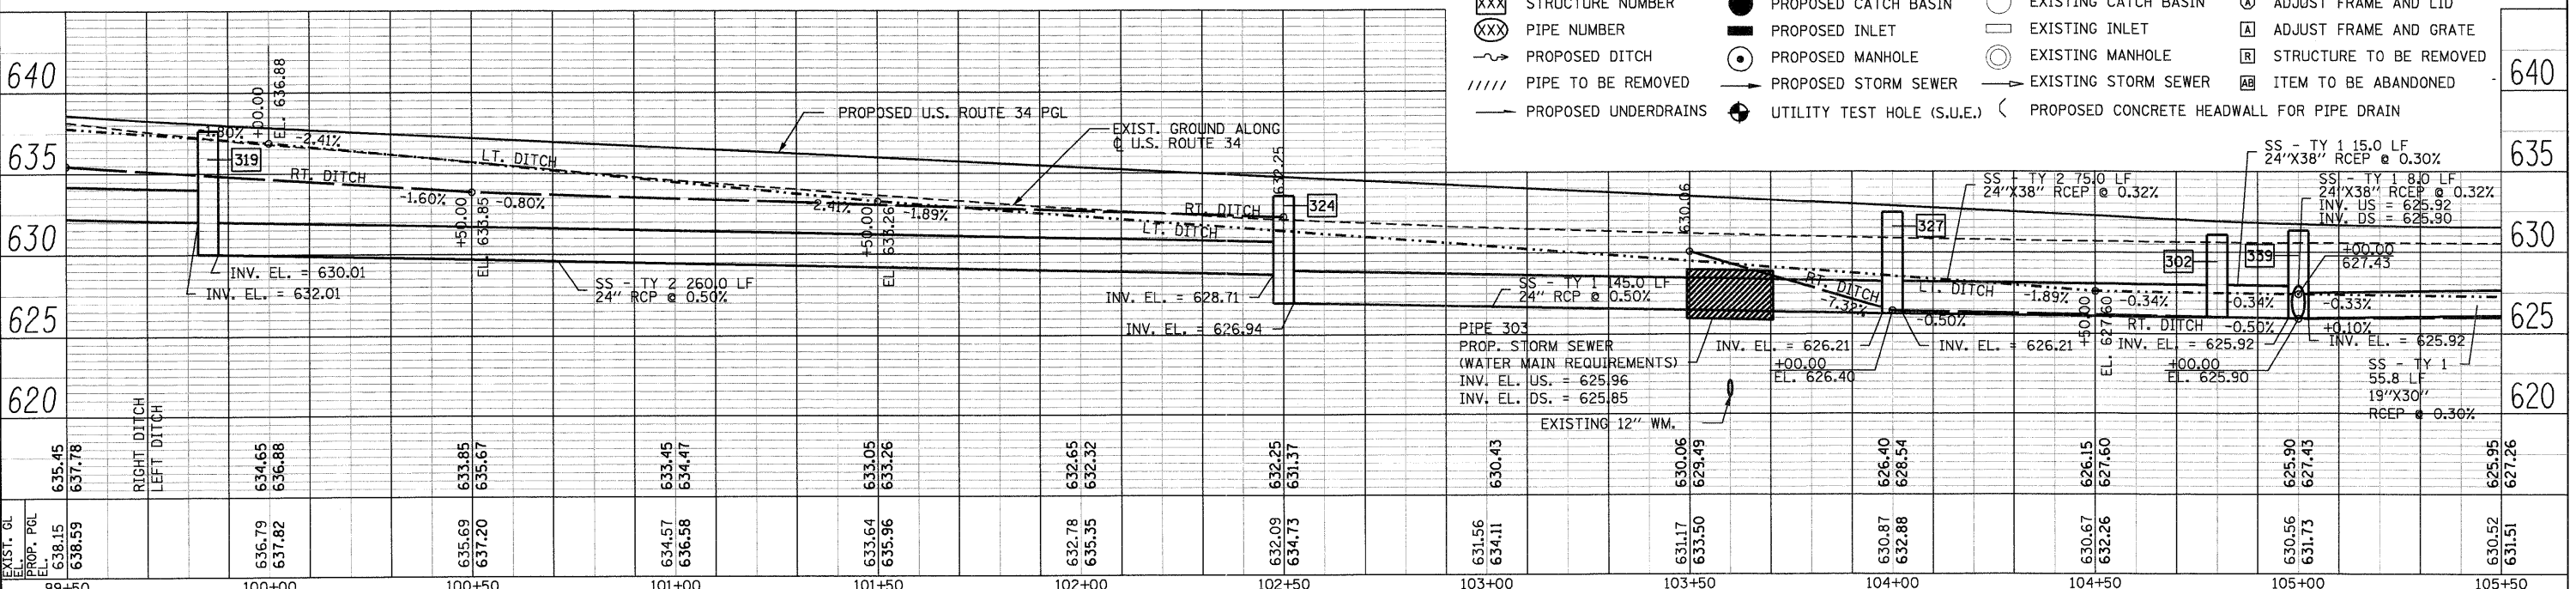

EXIST. GL	635.45	637.78		633.85	635.67	634.45	634.47	633.05	633.26	632.65	632.52	632.09	634.73	631.56	634.11	630.06	629.49	626.40	628.54	626.15	627.60	625.90	627.43	625.95	627.26
PROP. PGL	638.15	638.59		637.82	637.20	634.57	636.58	633.64	635.96	632.78	635.35	632.09	634.73	631.56	634.11	630.06	629.49	626.40	628.54	626.15	627.60	625.90	627.43	625.95	627.26
EL.																									
FILE NAME	D366985-shr-17drain.dgn																								
DESIGNED	RJD																								
DRAWN	RJD																								
CHECKED	PMK																								
DATE	08-18-2011																								
REVISIONS	-																								
REVISIONS	-																								
REVISIONS	-																								
REVISIONS	-																								
REVISIONS	-																								
REVISIONS	-																								

**PB Americas, Inc.**  
 230 WEST MONROE STREET,  
 SUITE 900  
 CHICAGO, IL 60606  
 (312)782-8150

STATE OF ILLINOIS  
 DEPARTMENT OF TRANSPORTATION

DRAINAGE PLAN & PROFILE  
 US ROUTE 34

SCALE: AS SHOWN DRNG - 17 OF 28 STA. 99+50 TO STA. 105+50

F.A.P. RTE.	SECTION	COUNTY	TOTAL SHEETS	SHEET NO.
591	13R-2;14R-1 & BR-1(1);15R-1	KENDALL	429	180
FINAL SUBMITTAL		CONTRACT NO. 66985		
ILLINOIS FED. AID PROJECT				