
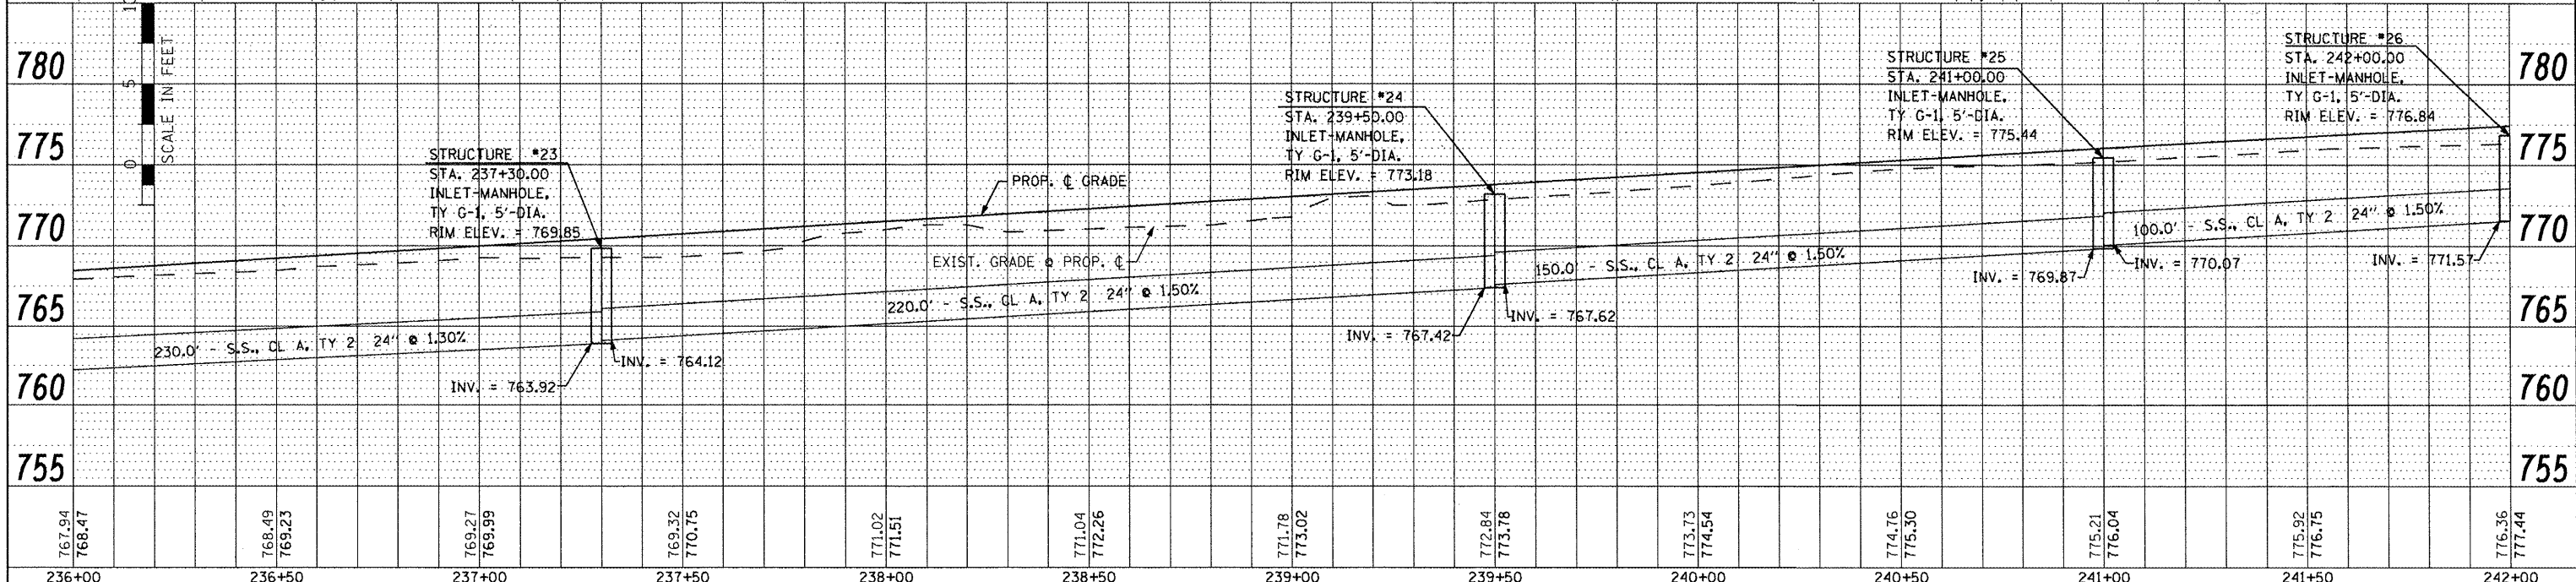


DATE	
BY	
REVISIONS	
PLANNED	
CHECKED	
RECORDED	
NO. 1	
NO. 2	
NO. 3	
NO. 4	
NO. 5	
NO. 6	
NO. 7	
NO. 8	
NO. 9	
NO. 10	

DATE	
BY	
REVISIONS	
PLANNED	
CHECKED	
RECORDED	
NO. 1	
NO. 2	
NO. 3	
NO. 4	
NO. 5	
NO. 6	
NO. 7	
NO. 8	
NO. 9	
NO. 10	

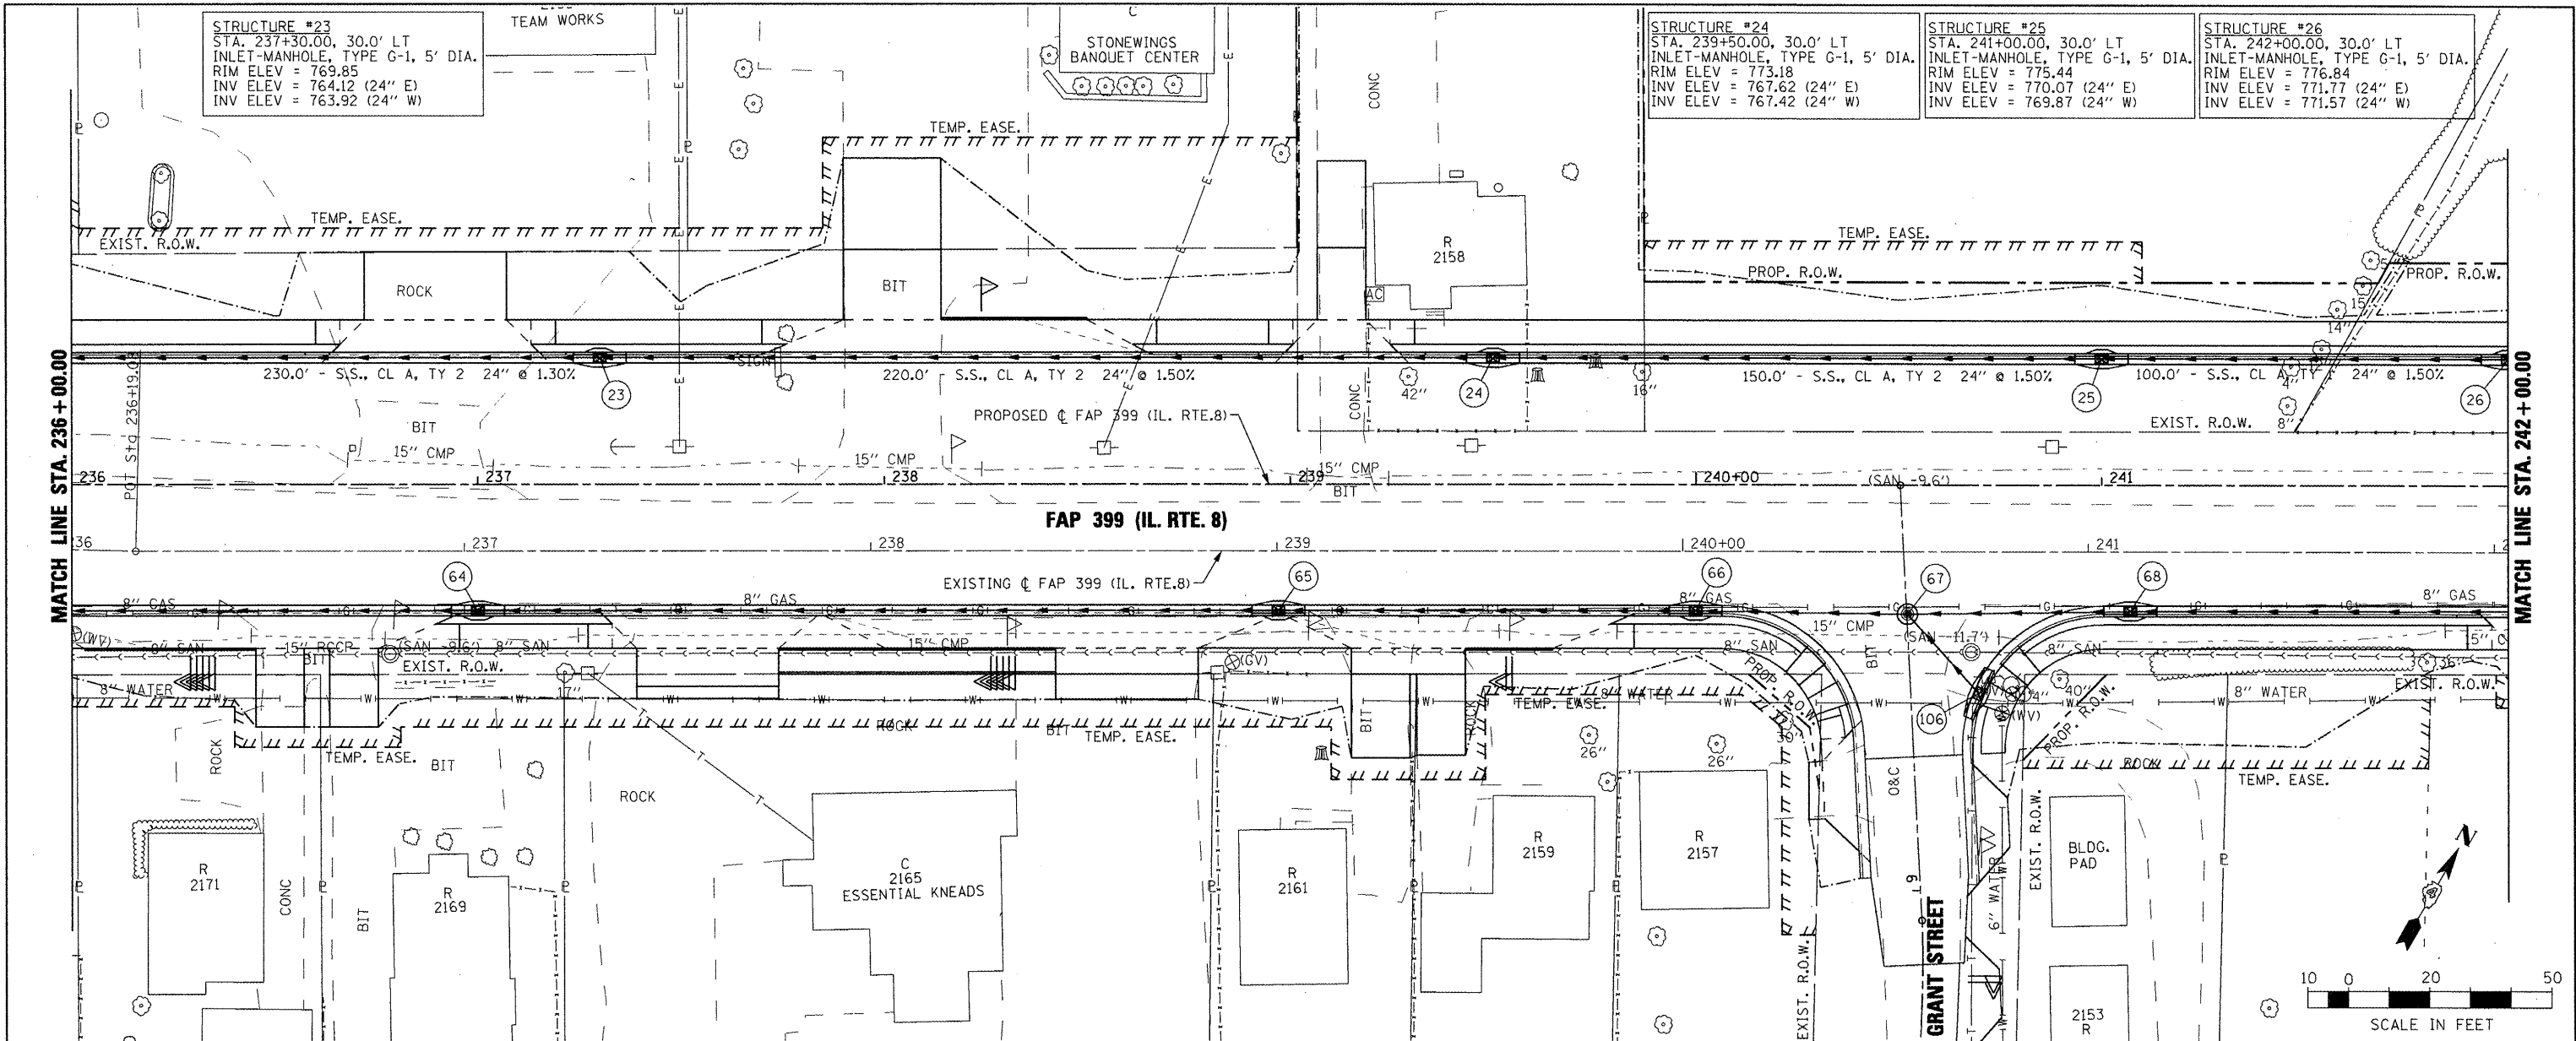

FILE NAME =	USER NAME = IDOT	DESIGNED -	REVISED -	STATE OF ILLINOIS DEPARTMENT OF TRANSPORTATION				F.A. RTE. =	SECTION	COUNTY	TOTAL SHEETS	SHEET NO.
x:\projects\200803566\dgn\04-Rte8-shv-DRN-7_NORTH.dgn		DRAWN -	REVISED -	FAP 399 (IL. RTE. 8) DRAINAGE PLAN AND PROFILE - NORTH				399	36 R-7	TAZEWELL	390	183
	PLOT SCALE = 40.0000' / IN.	CHECKED -	REVISED -	SCALE: AS SHOWN SHEET NO. OF SHEETS STA. 236+00.00 TO STA. 242+00.00				CONTRACT NO. 68370				
	PLOT DATE = 10/21/2011	DATE -	REVISED -					ILLINOIS FED. AID PROJECT				