


STA 626+35.00 LT
 PROPOSED PIPE CULVERT, CLASS A, TYPE I, 18" X 60"
 1-INLET BOX TYPE C STD 542511
 1-18" PRC FLARED END SEC STD 542301
 DITCH ELEV. 663.55
 USFL 662.55, 13.58' LT
 DSFL 661.69, 73.20' LT

CL SURVEY & CONSTRUCTION
 FAP 407 (IL 336)

IL RTE 336

CL SURVEY & CONSTRUCTION
 1250N (ADAMS STREET)

DANIEL LEE NUDD &
 KAREN E. NUDD

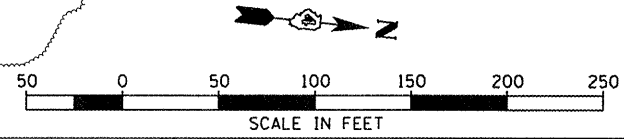

FILE NAME =	USER NAME = jwhite	DESIGNED -	REVISED -	STATE OF ILLINOIS DEPARTMENT OF TRANSPORTATION	TR 1250N (ADAMS STREET EXTENSION) DRAINAGE & UTILITY PLAN - IL 336	F.A.P. RTE.	SECTION	COUNTY	TOTAL SHEETS	SHEET NO.	
V:\Transportation\289\1250N (ADAMS) PLAN	S:\ADAMS336PlanB1.dgn	DRAWN -	REVISED -			407	55-3HB-1	McDONOUGH	103	21	
PLOT SCALE = 100.00' / IN.	CHECKED -	REVISED -	REVISED -			CONTRACT NO. 68A41					
PLOT DATE = 10/21/2011	DATE = 10/20/11	REVISED -	REVISED -			[ILLINOIS] FED. AID PROJECT					
					SCALE: 1"=50'	SHEET NO. OF SHEETS		STA. 618+00 TO STA. 632+00			