


SEE SHT. 8/16
MATCHLINE STA. 289+00

MATCHLINE STA. 297+00
SEE SHT. 10A/16


SEE SHT. 8/16
MATCHLINE STA. 2+00

SEE SHT. 6/19
MATCHLINE STA. 0+00

SEE SHT. 6/16
MATCHLINE STA. 16+50

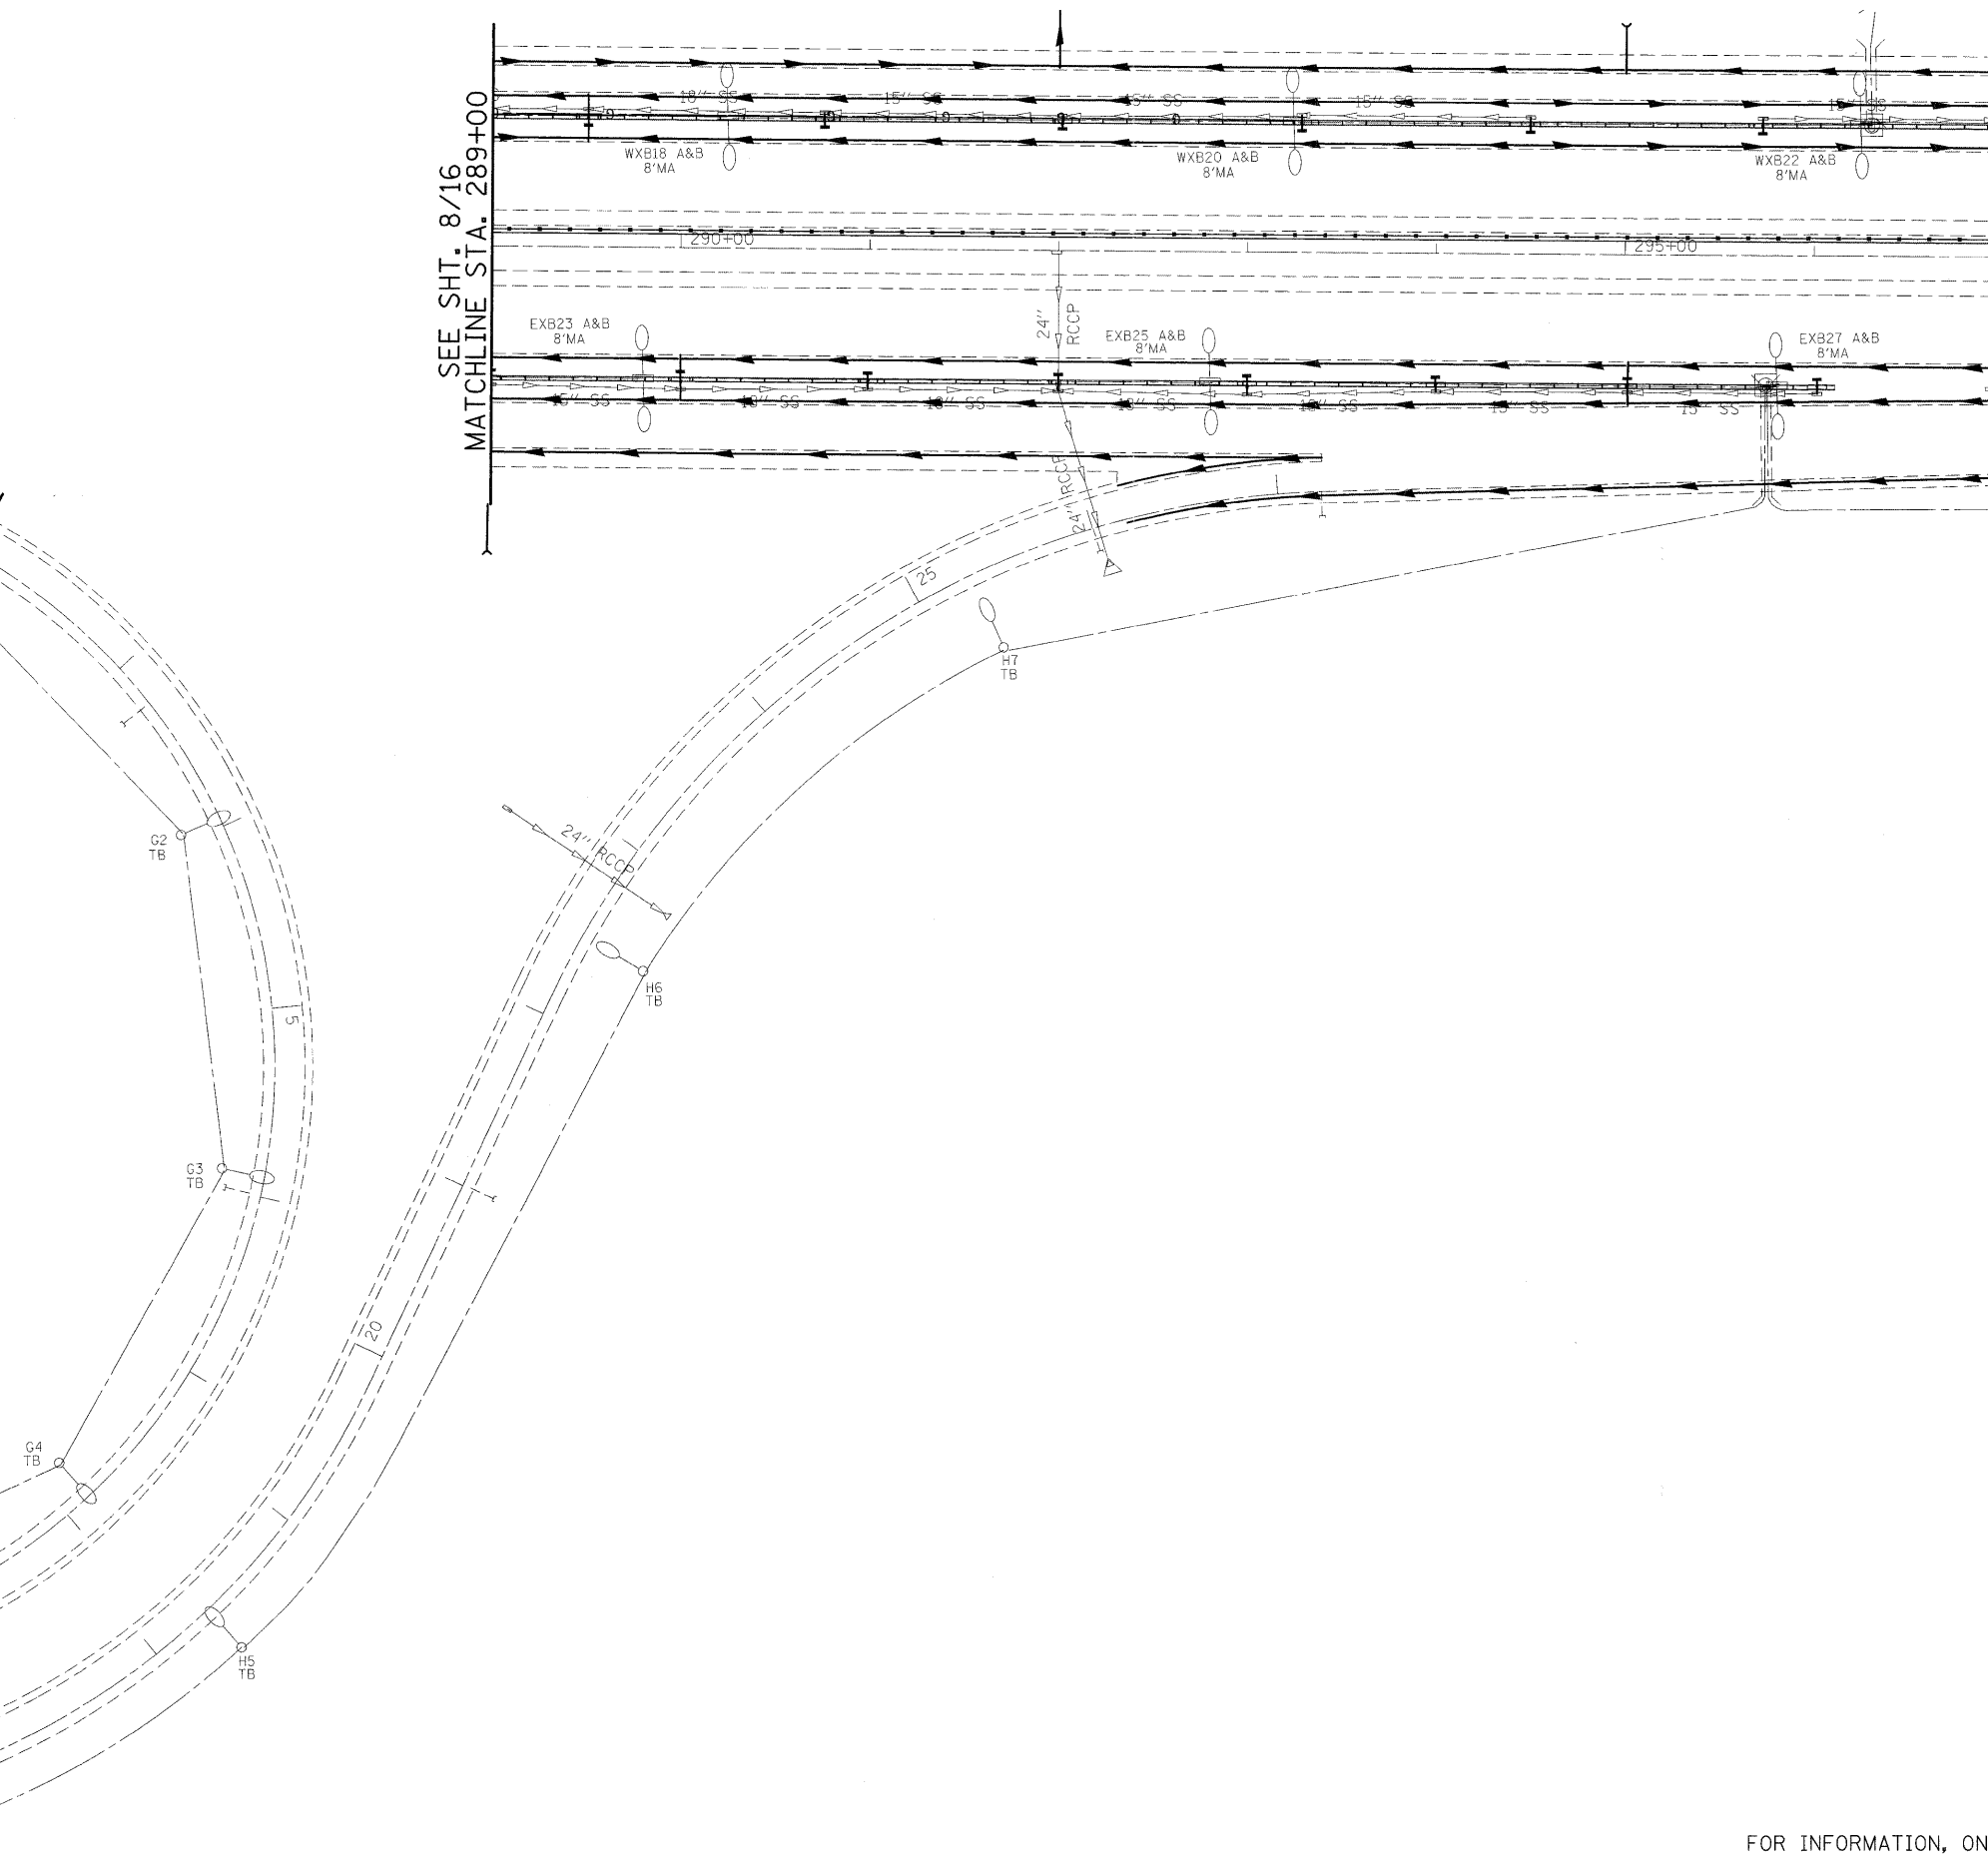

FOR INFORMATION, ONLY

 

FILE NAME = c:\pwork\pwork\burnsideem\0129244\0876415-sht-light.dgn	USER NAME = burnsideem	DESIGNED -	REVISED -	STATE OF ILLINOIS DEPARTMENT OF TRANSPORTATION	LIGHTING PLANS CONTROLLERS #18 & #19 SHTS. 6 OF 10		F.A.I. RTE. 64	SECTION 82-13-4RS	COUNTY ST. CLAIR	TOTAL SHEETS 161	SHEET NO. 93	
PLOT SCALE = 50.0249 ' / ' in.	PLOT DATE = 12/6/2011	DRAWN -	REVISED -		SCALE: _____	SHEET NO. _____ OF _____ SHEETS	STA. _____ TO STA. _____	CONTRACT NO. 76415				
		CHECKED -	REVISED -		FED. ROAD DIST. NO. - ILLINOIS FED. AID PROJECT							
		DATE -	REVISED -									