


\\FS-0044\N\VALI.LD-TRANS_07122021\28868-001\ARCH\CAD\ITS TECH SYSTEMS\SHEETS CONTRACT 11\08\CONK.11-SHT-TSPL\ANBLDGN
 10/15/2011 15:31:55
 80NDHLLD

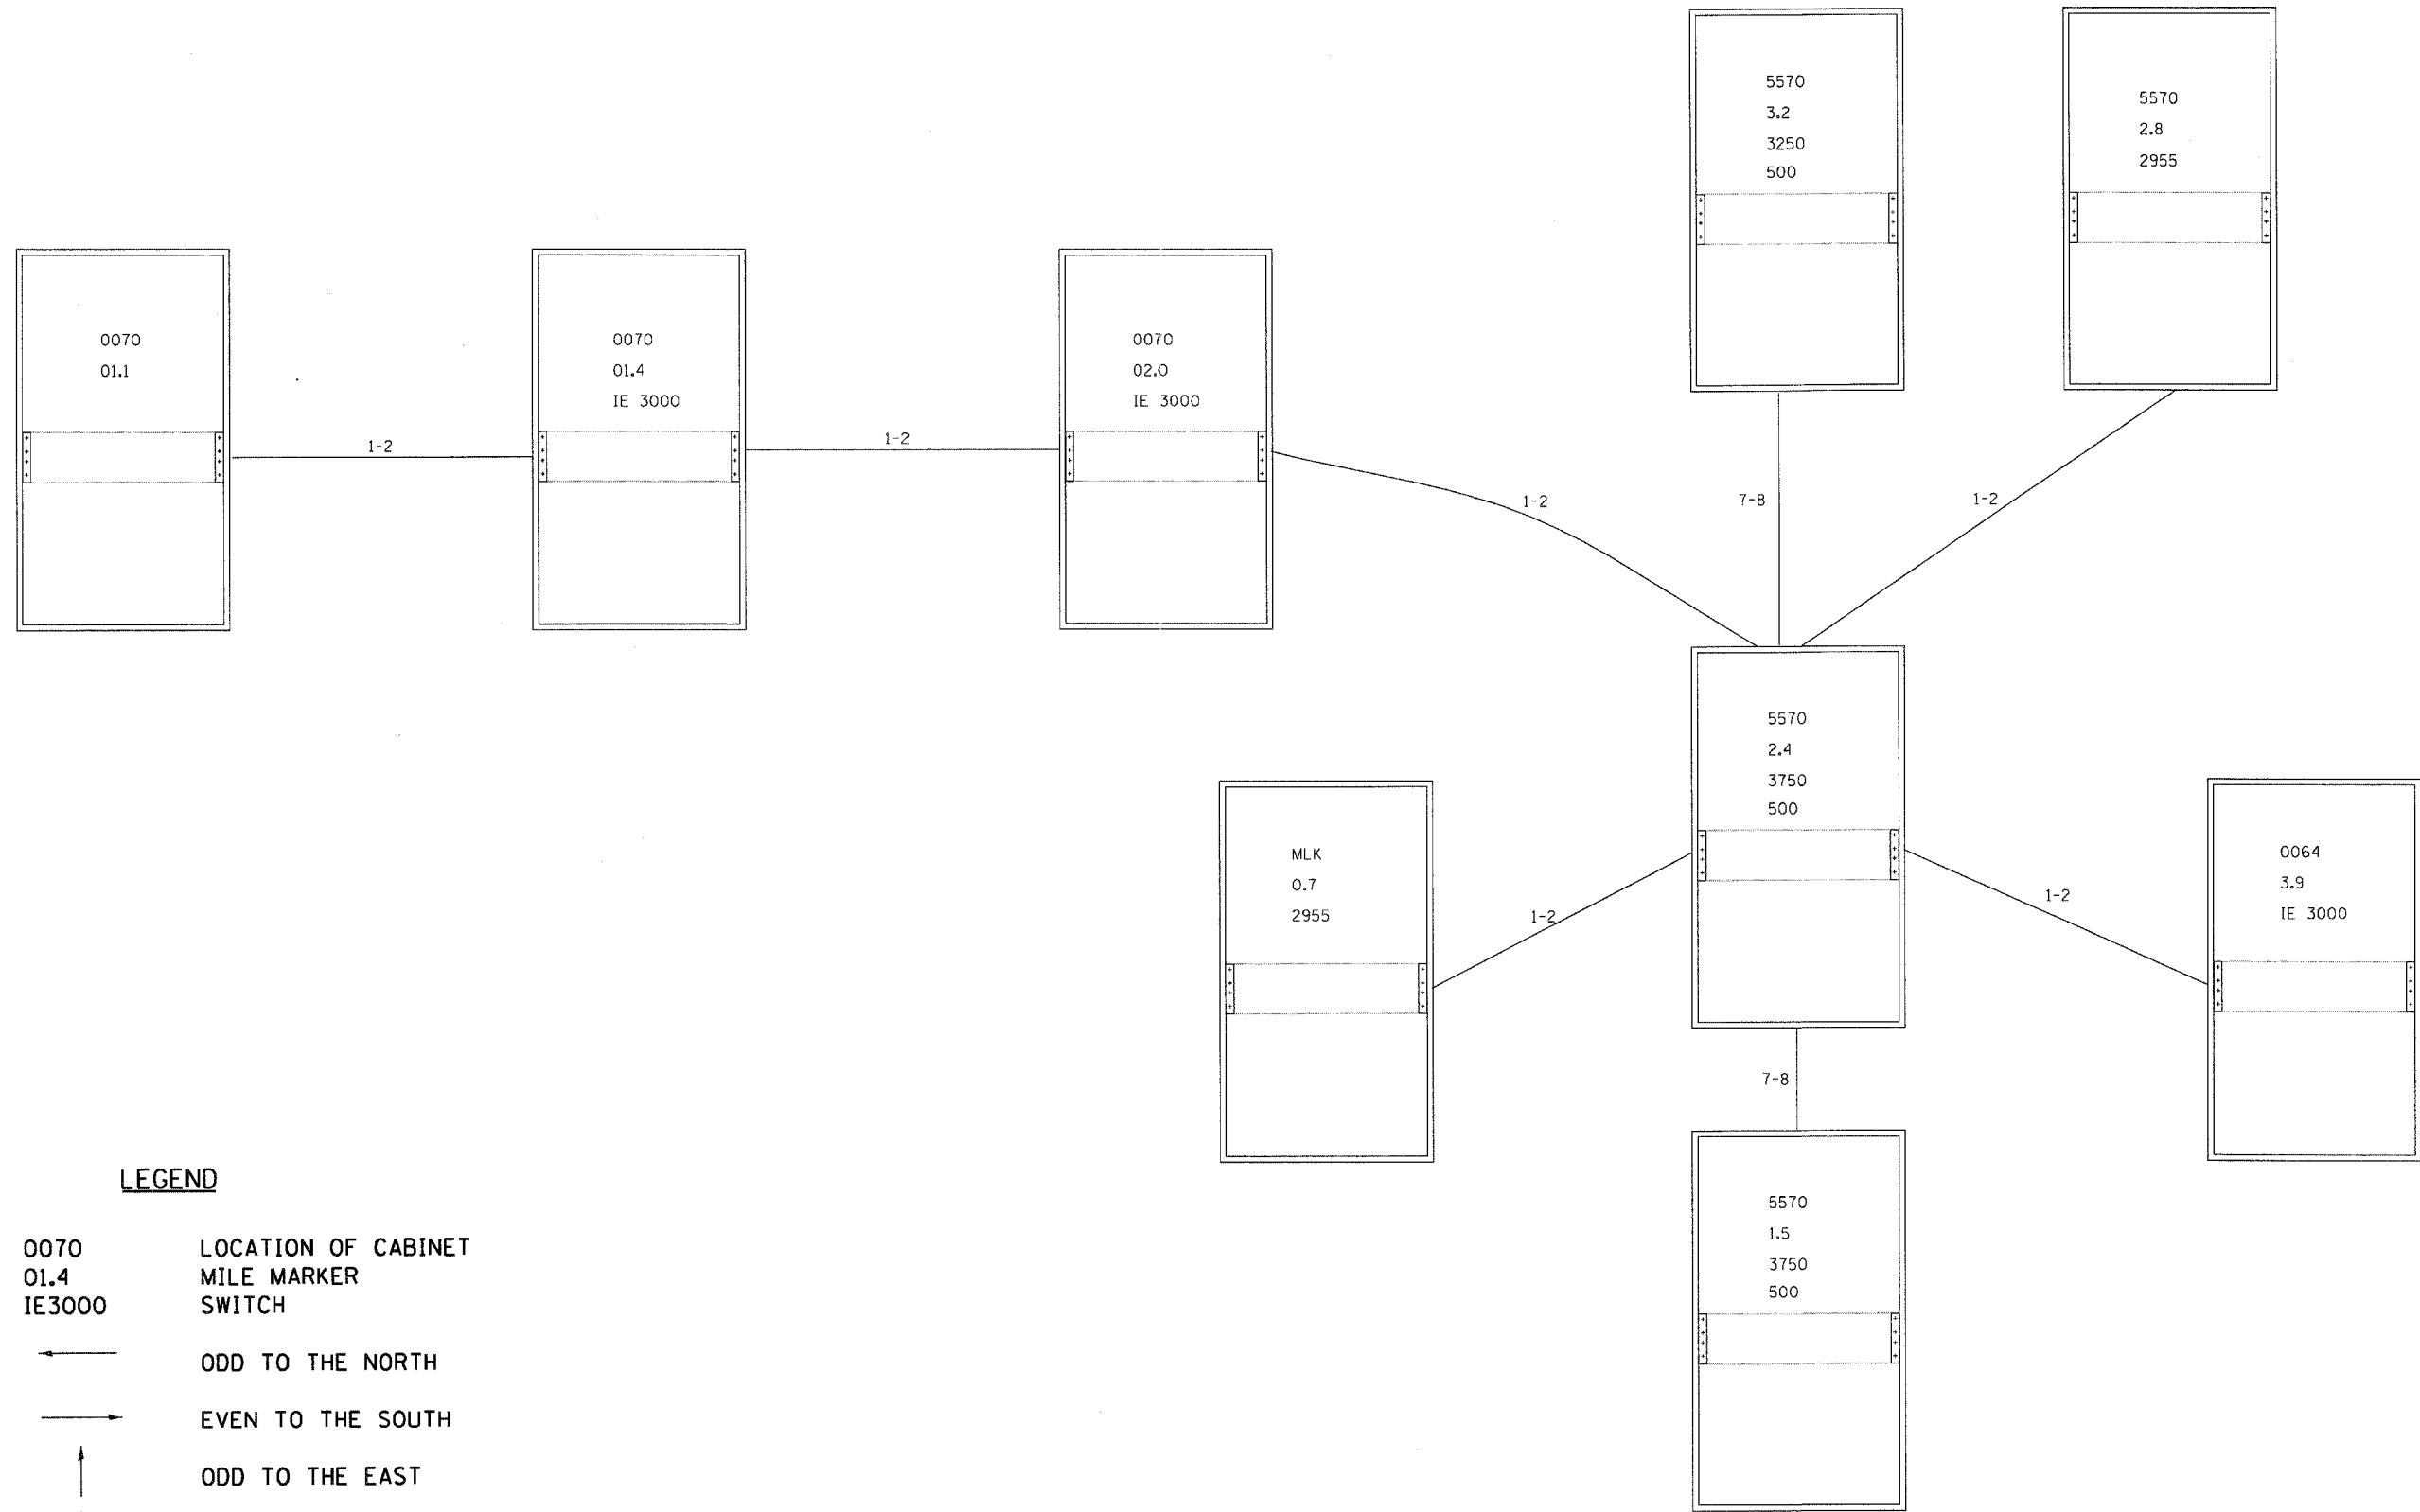

FILE NAME =	USER NAME = #USER#	DESIGNED - KRR	REVISED -
#FILE#		DRAWN - ARM	REVISED -
		CHECKED - KRR	REVISED -
		DATE - 10/21/11	REVISED -

STATE OF ILLINOIS
DEPARTMENT OF TRANSPORTATION
 PROPOSED RELOCATED IL ROUTE 3 INTERCHANGE

SCHEMATIC DIAGRAM
SHOWING CABINETS AND ONE LINE DIAGRAM OF ACTIVE FIBERS

F.A.P. RTE.	SECTION	COUNTY	TOTAL SHEETS	SHEET NO.
998	82-2-1K	ST. CLAIR	353	245
CONTRACT NO. 76E06				
FED. ROAD DIST. NO. ILLINOIS FED. AID PROJECT				



TENG & ASSOCIATES, INC.
 ENGINEERS/ARCHITECTS/PLANNERS
 CHICAGO, ILLINOIS

SCALE: N.T.S. SHEET NO. OF SHEETS STA. TO STA.