
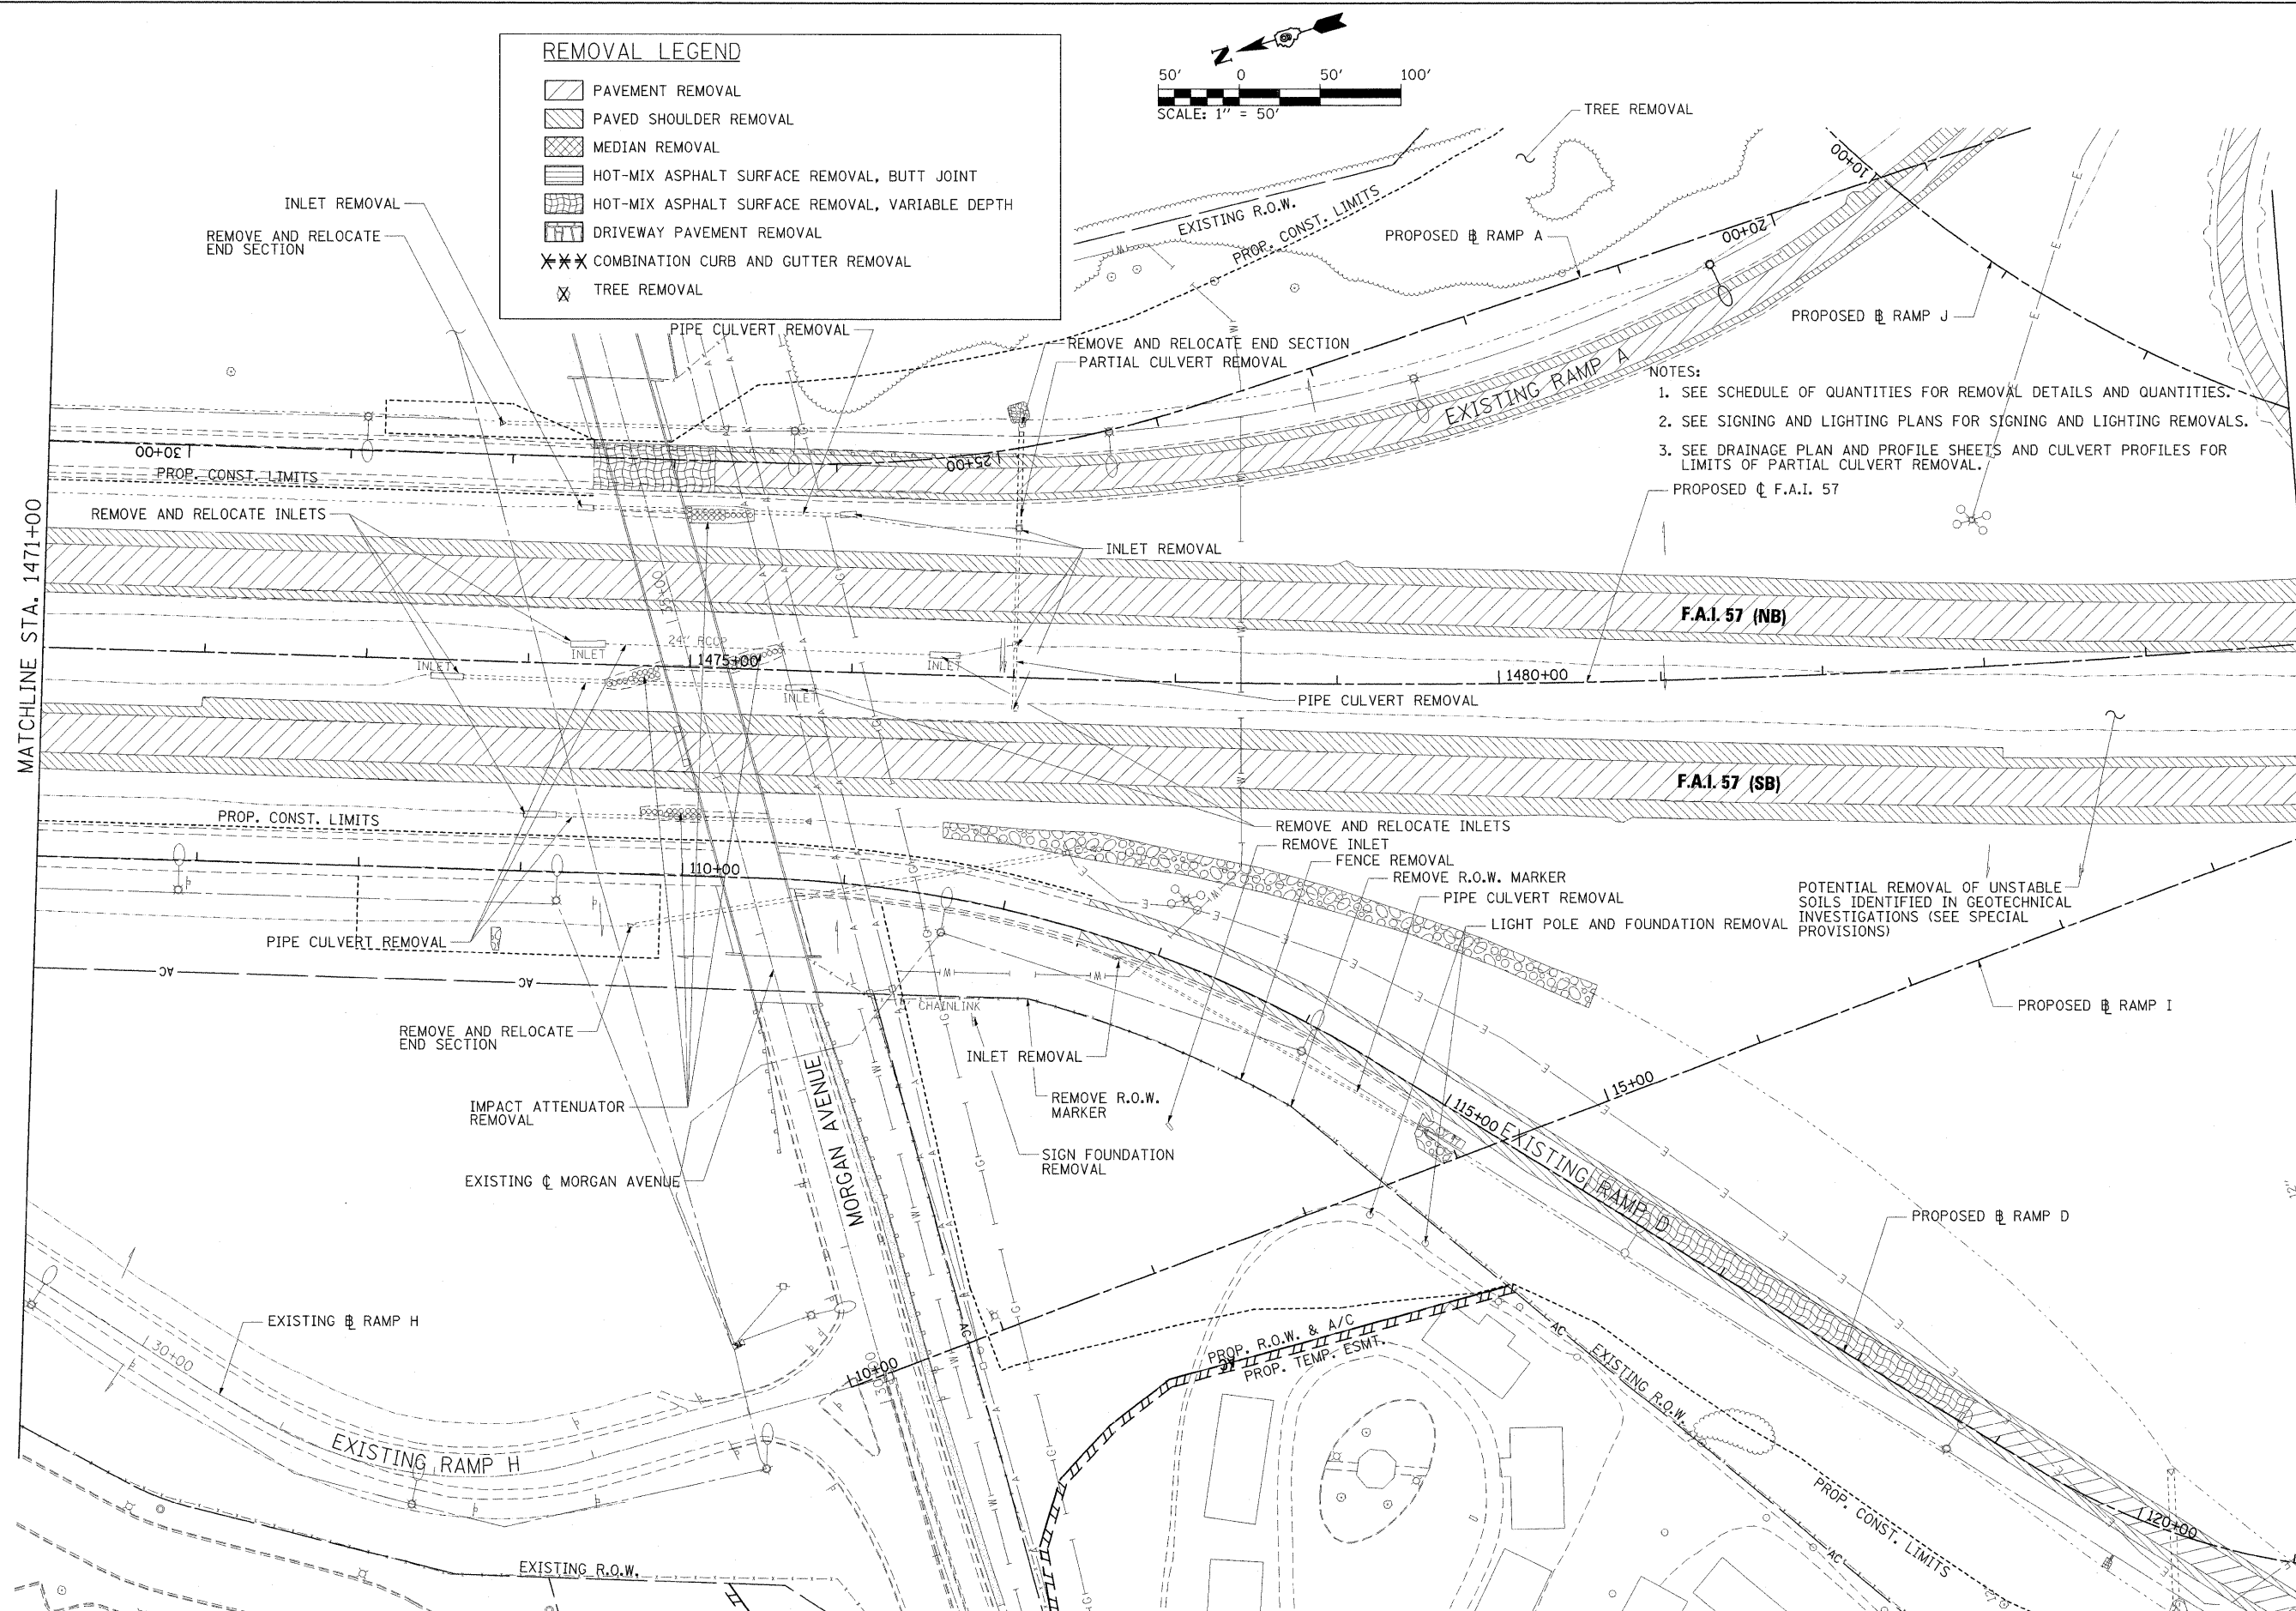


REMOVAL LEGEND

	PAVEMENT REMOVAL
	PAVED SHOULDER REMOVAL
	MEDIAN REMOVAL
	HOT-MIX ASPHALT SURFACE REMOVAL, BUTT JOINT
	HOT-MIX ASPHALT SURFACE REMOVAL, VARIABLE DEPTH
	DRIVEWAY PAVEMENT REMOVAL
	COMBINATION CURB AND GUTTER REMOVAL
	TREE REMOVAL

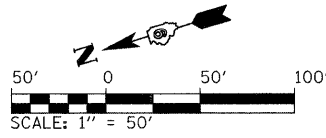

- NOTES:**
1. SEE SCHEDULE OF QUANTITIES FOR REMOVAL DETAILS AND QUANTITIES.
 2. SEE SIGNING AND LIGHTING PLANS FOR SIGNING AND LIGHTING REMOVALS.
 3. SEE DRAINAGE PLAN AND PROFILE SHEETS AND CULVERT PROFILES FOR LIMITS OF PARTIAL CULVERT REMOVAL.
- PROPOSED ϕ F.A.I. 57

POTENTIAL REMOVAL OF UNSTABLE SOILS IDENTIFIED IN GEOTECHNICAL INVESTIGATIONS (SEE SPECIAL PROVISIONS)

FILE NAME = ...D978182-shr-rem-157_004.dgn	USER NAME = Prad Downen	DESIGNED - MKW	REVISED -	STATE OF ILLINOIS DEPARTMENT OF TRANSPORTATION	REMOVAL PLAN INTERSTATE 57	F.A. RTE.	SECTION	COUNTY	TOTAL SHEETS	SHEET NO.
	PLOT SCALE = 50.0000' / IN.	DRAWN - MKW	REVISED -			* 0X1-6-2H8K-2, HB-1,2; 0X-1R-1	WILLIAMSON	968	341	
PLOT DATE = 10/12/2011	CHECKED - BJD	DATE - 10/07/11	REVISED -	SCALE: 1" = 50'		SHEET NO. OF SHEETS		STA. 1471+00 TO STA. 1485+00		CONTRACT NO. 78182
						ILLINOIS FED. AID PROJECT				