 
 
 
 



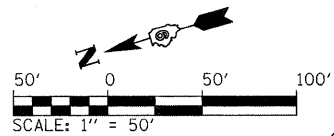


LEGEND


-  EXISTING LIGHTING UNIT TO REMAIN
-  EXISTING LIGHTING UNIT TO BE RELOCATED
-  EXISTING UNIT DUCT OR CABLE IN CONDUIT
-  EXISTING HIGH MAST TOWER TO BE REMOVED
-  EXISTING JUNCTION BOX
-  EXISTING LIGHTING CONTROLLER TO BE REMOVED
-  EXISTING LIGHTING CONTROLLER TO REMAIN

EXISTING LIGHTING CONTROLLER
INSTALLED IN CONTRACT 78194



NOTES

1. THE LOCATIONS OF EXISTING UNIT DUCT AS SHOWN ON THE PLANS ARE APPROXIMATE. THE CONTRACTOR SHALL VERIFY THE EXACT LOCATION IN THE FIELD PRIOR TO CONSTRUCTION.
2. EXISTING HIGH MAST TOWER TO BE REMOVED. THIS WORK SHALL BE PAID FOR AS "REMOVAL OF LIGHTING UNIT, NO SALVAGE" PAY ITEM. FOUNDATION REMOVAL SHALL BE PAID FOR AS "REMOVAL OF POLE FOUNDATION" PAY ITEM.

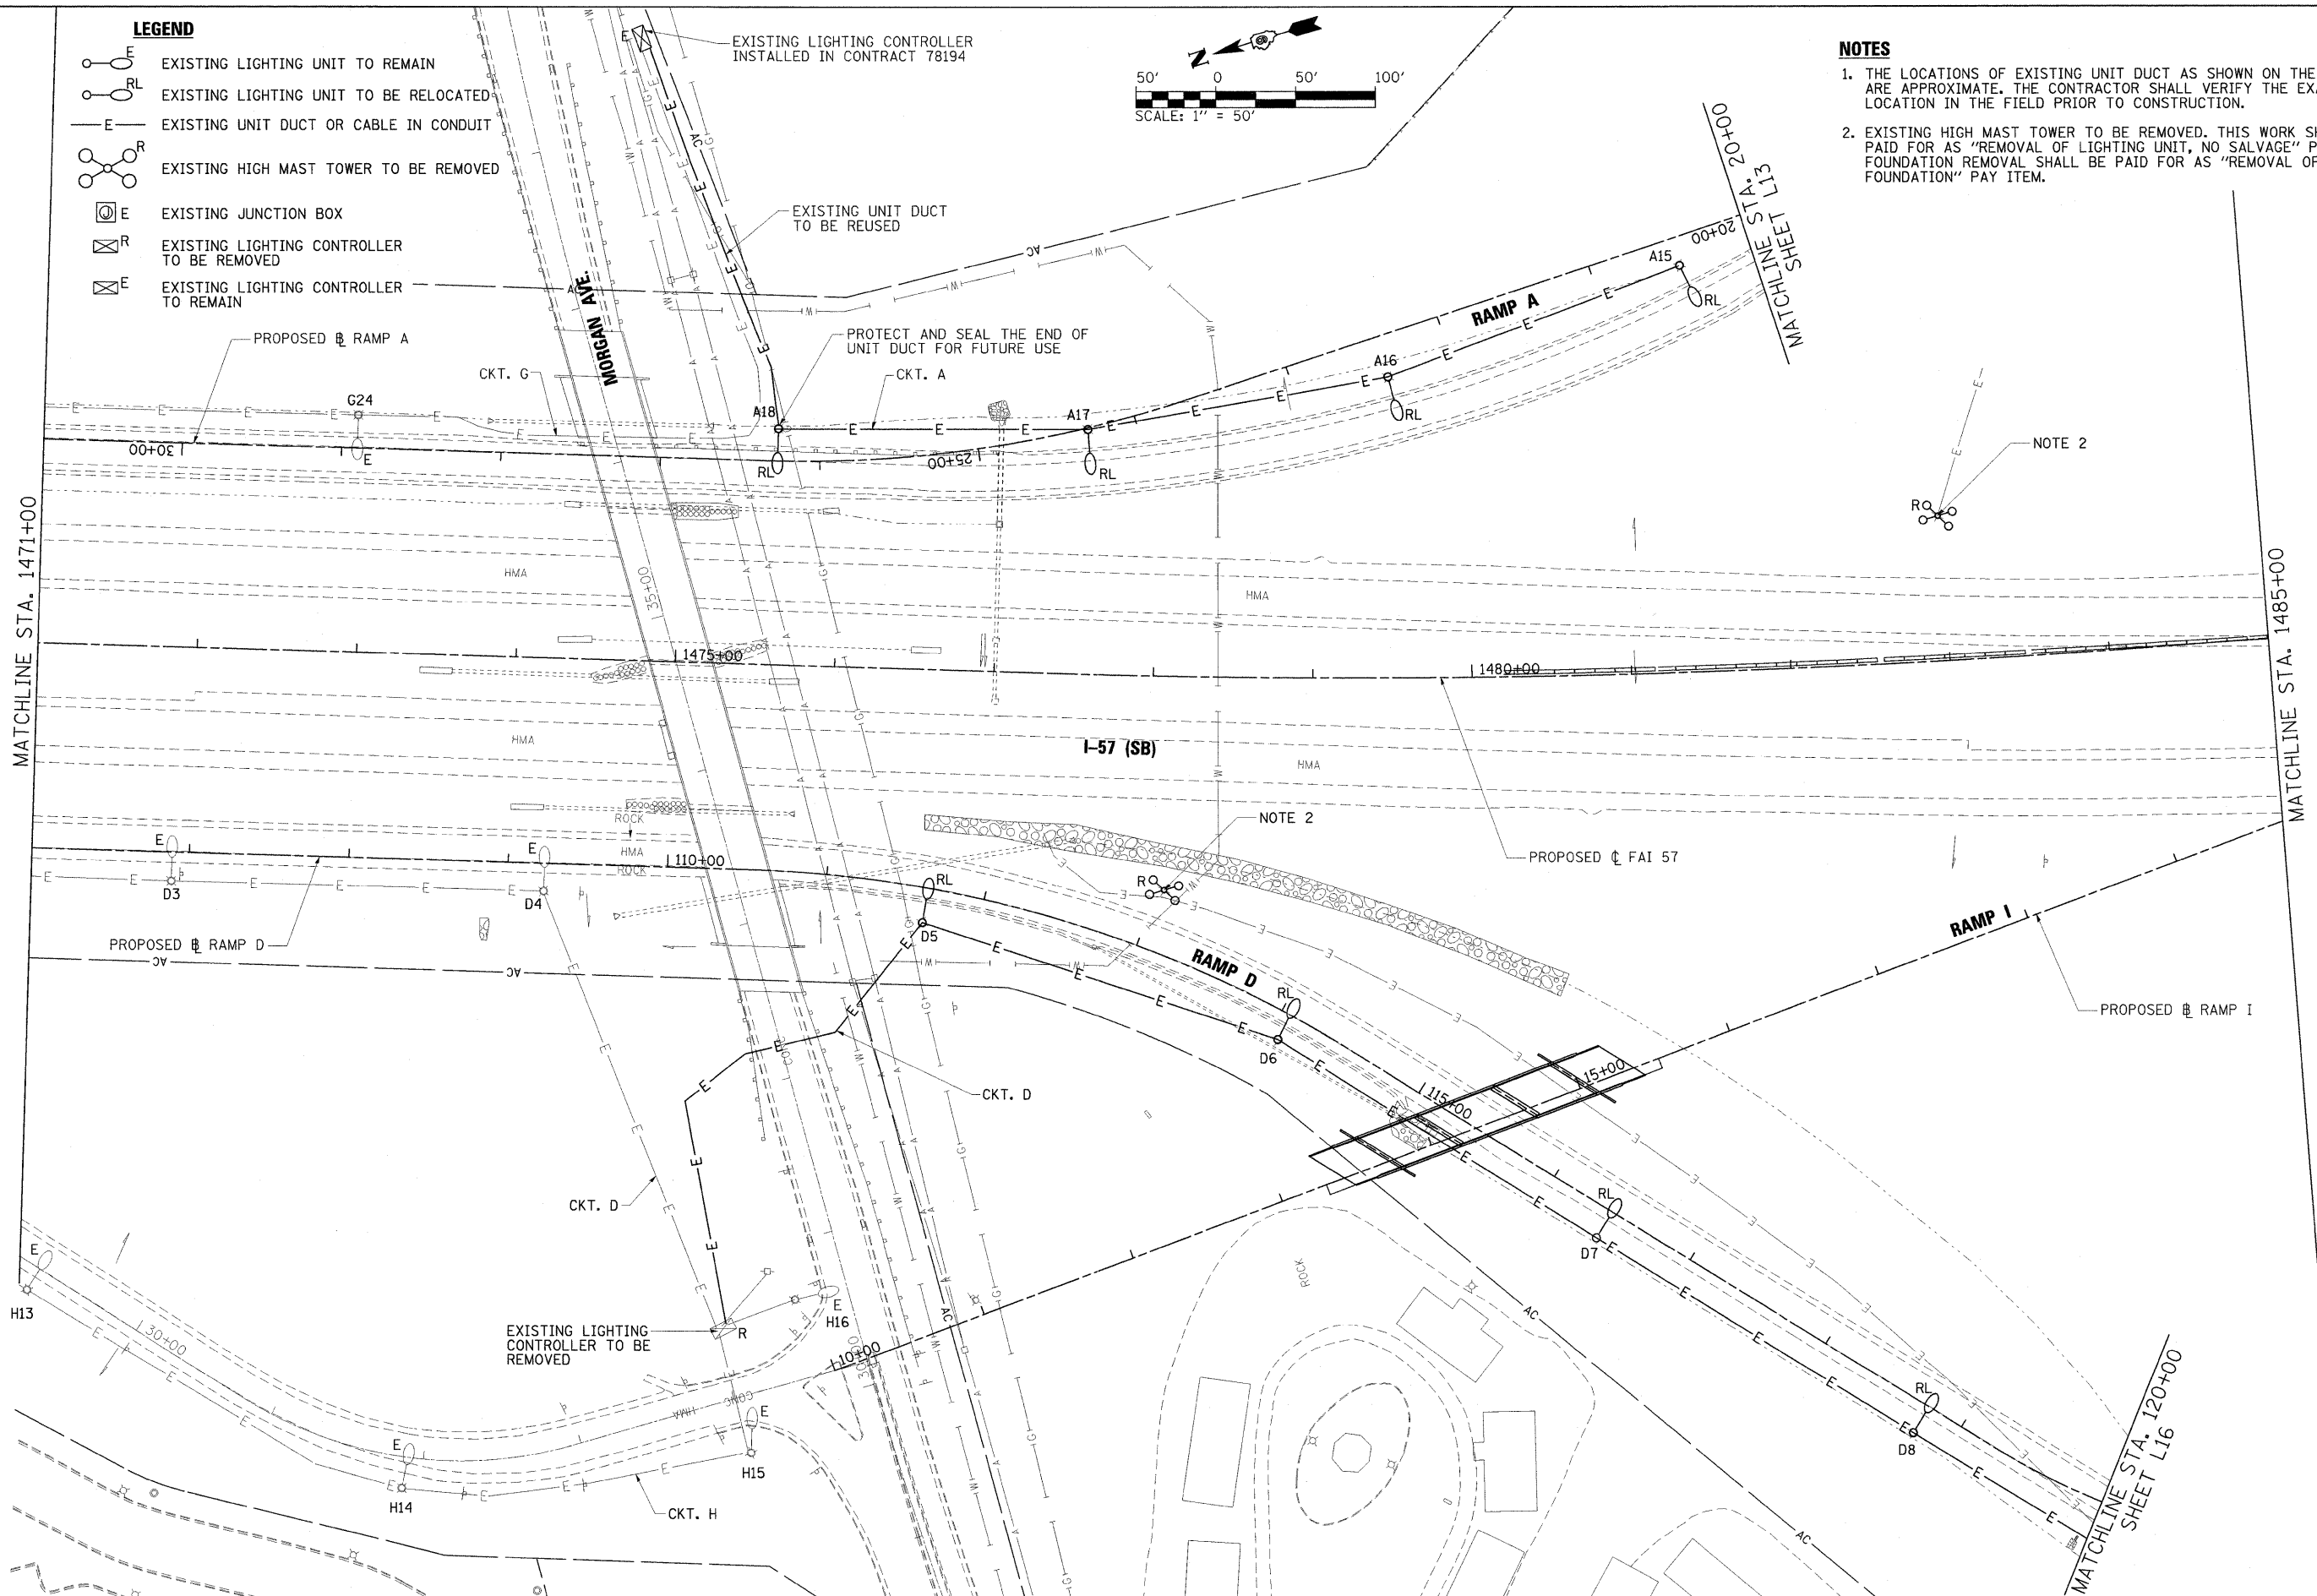

MATCHLINE STA. 1471+00

MATCHLINE STA. 1485+00

MATCHLINE STA. 120+00
SHEET L16

L5

FILE NAME = ...ND978182-shr-Light-157.004.dgn	USER NAME = Gary Davis	DESIGNED - IDOT CENTRAL OFFICE	REVISED -	STATE OF ILLINOIS DEPARTMENT OF TRANSPORTATION	EXISTING LIGHTING REMOVAL AND TEMPORARY LIGHTING PLAN INTERSTATE 57	F.A. RTE.	SECTION	COUNTY	TOTAL SHEETS	SHEET NO.
		DRAWN - GLD (CMT)	REVISED -			* (X1-6-2)HBK-2, HB-1,2; (IX-1)R-1	WILLIAMSON	968	546	
		CHECKED -	REVISED -			* F.A.I. 57 AND F.A.P. 331				CONTRACT NO. 78182
		DATE - 10/7/2011	REVISED -			SCALE: 1" = 50'	SHEET NO. L5 OF L42 SHEETS	STA. 1471+00	TO STA. 1485+00	ILLINOIS FED. AID PROJECT